



AS-BUILT DRAWING NOTE:
AS-BUILT DRAWING FOR SANITARY SEWER AND
WATERLINE IMPROVEMENTS ARE FOR AS-BUILT
PURPOSES ONLY. NO IMPROVEMENTS OTHER
THAN WATER AND SANITARY SEWER STRUCTURES
WERE AS-BUILT OR INDICATED AS SUCH ON
THE SUBJECT PLAN SET. UNDERGROUND PIPING
WAS NOT LOCATED. LOCATION SHOWN IS
APPROXIMATE BASED ON SURFACE FEATURES
AND INFORMATION PROVIDED BY CONTRACTOR.

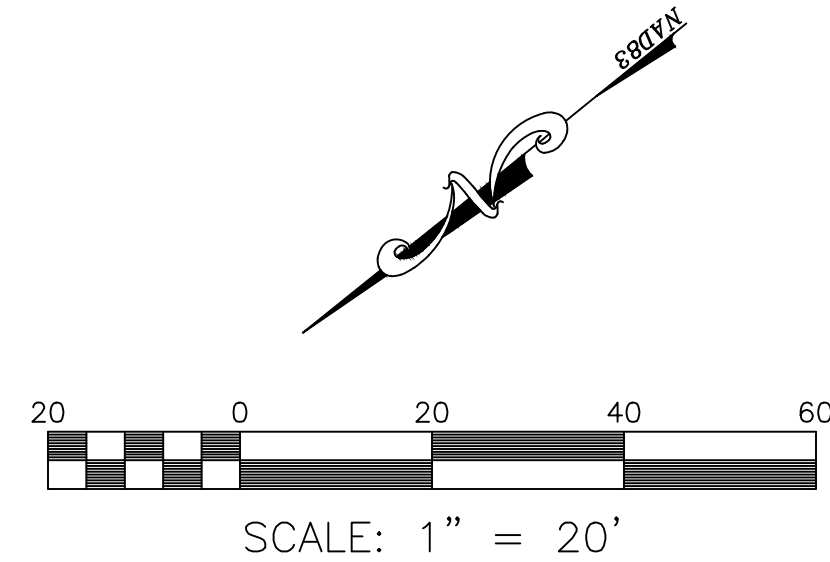

**BALZER
& ASSOCIATES**
PLANNERS / ARCHITECTS
ENGINEERS / SURVEYORS

Roanoke / Richmond
New River Valley / Staunton
Harrisonburg / Lynchburg
www.balzer.cc
1208 Corporate Circle
Roanoke, VA 24018
540.772.9580

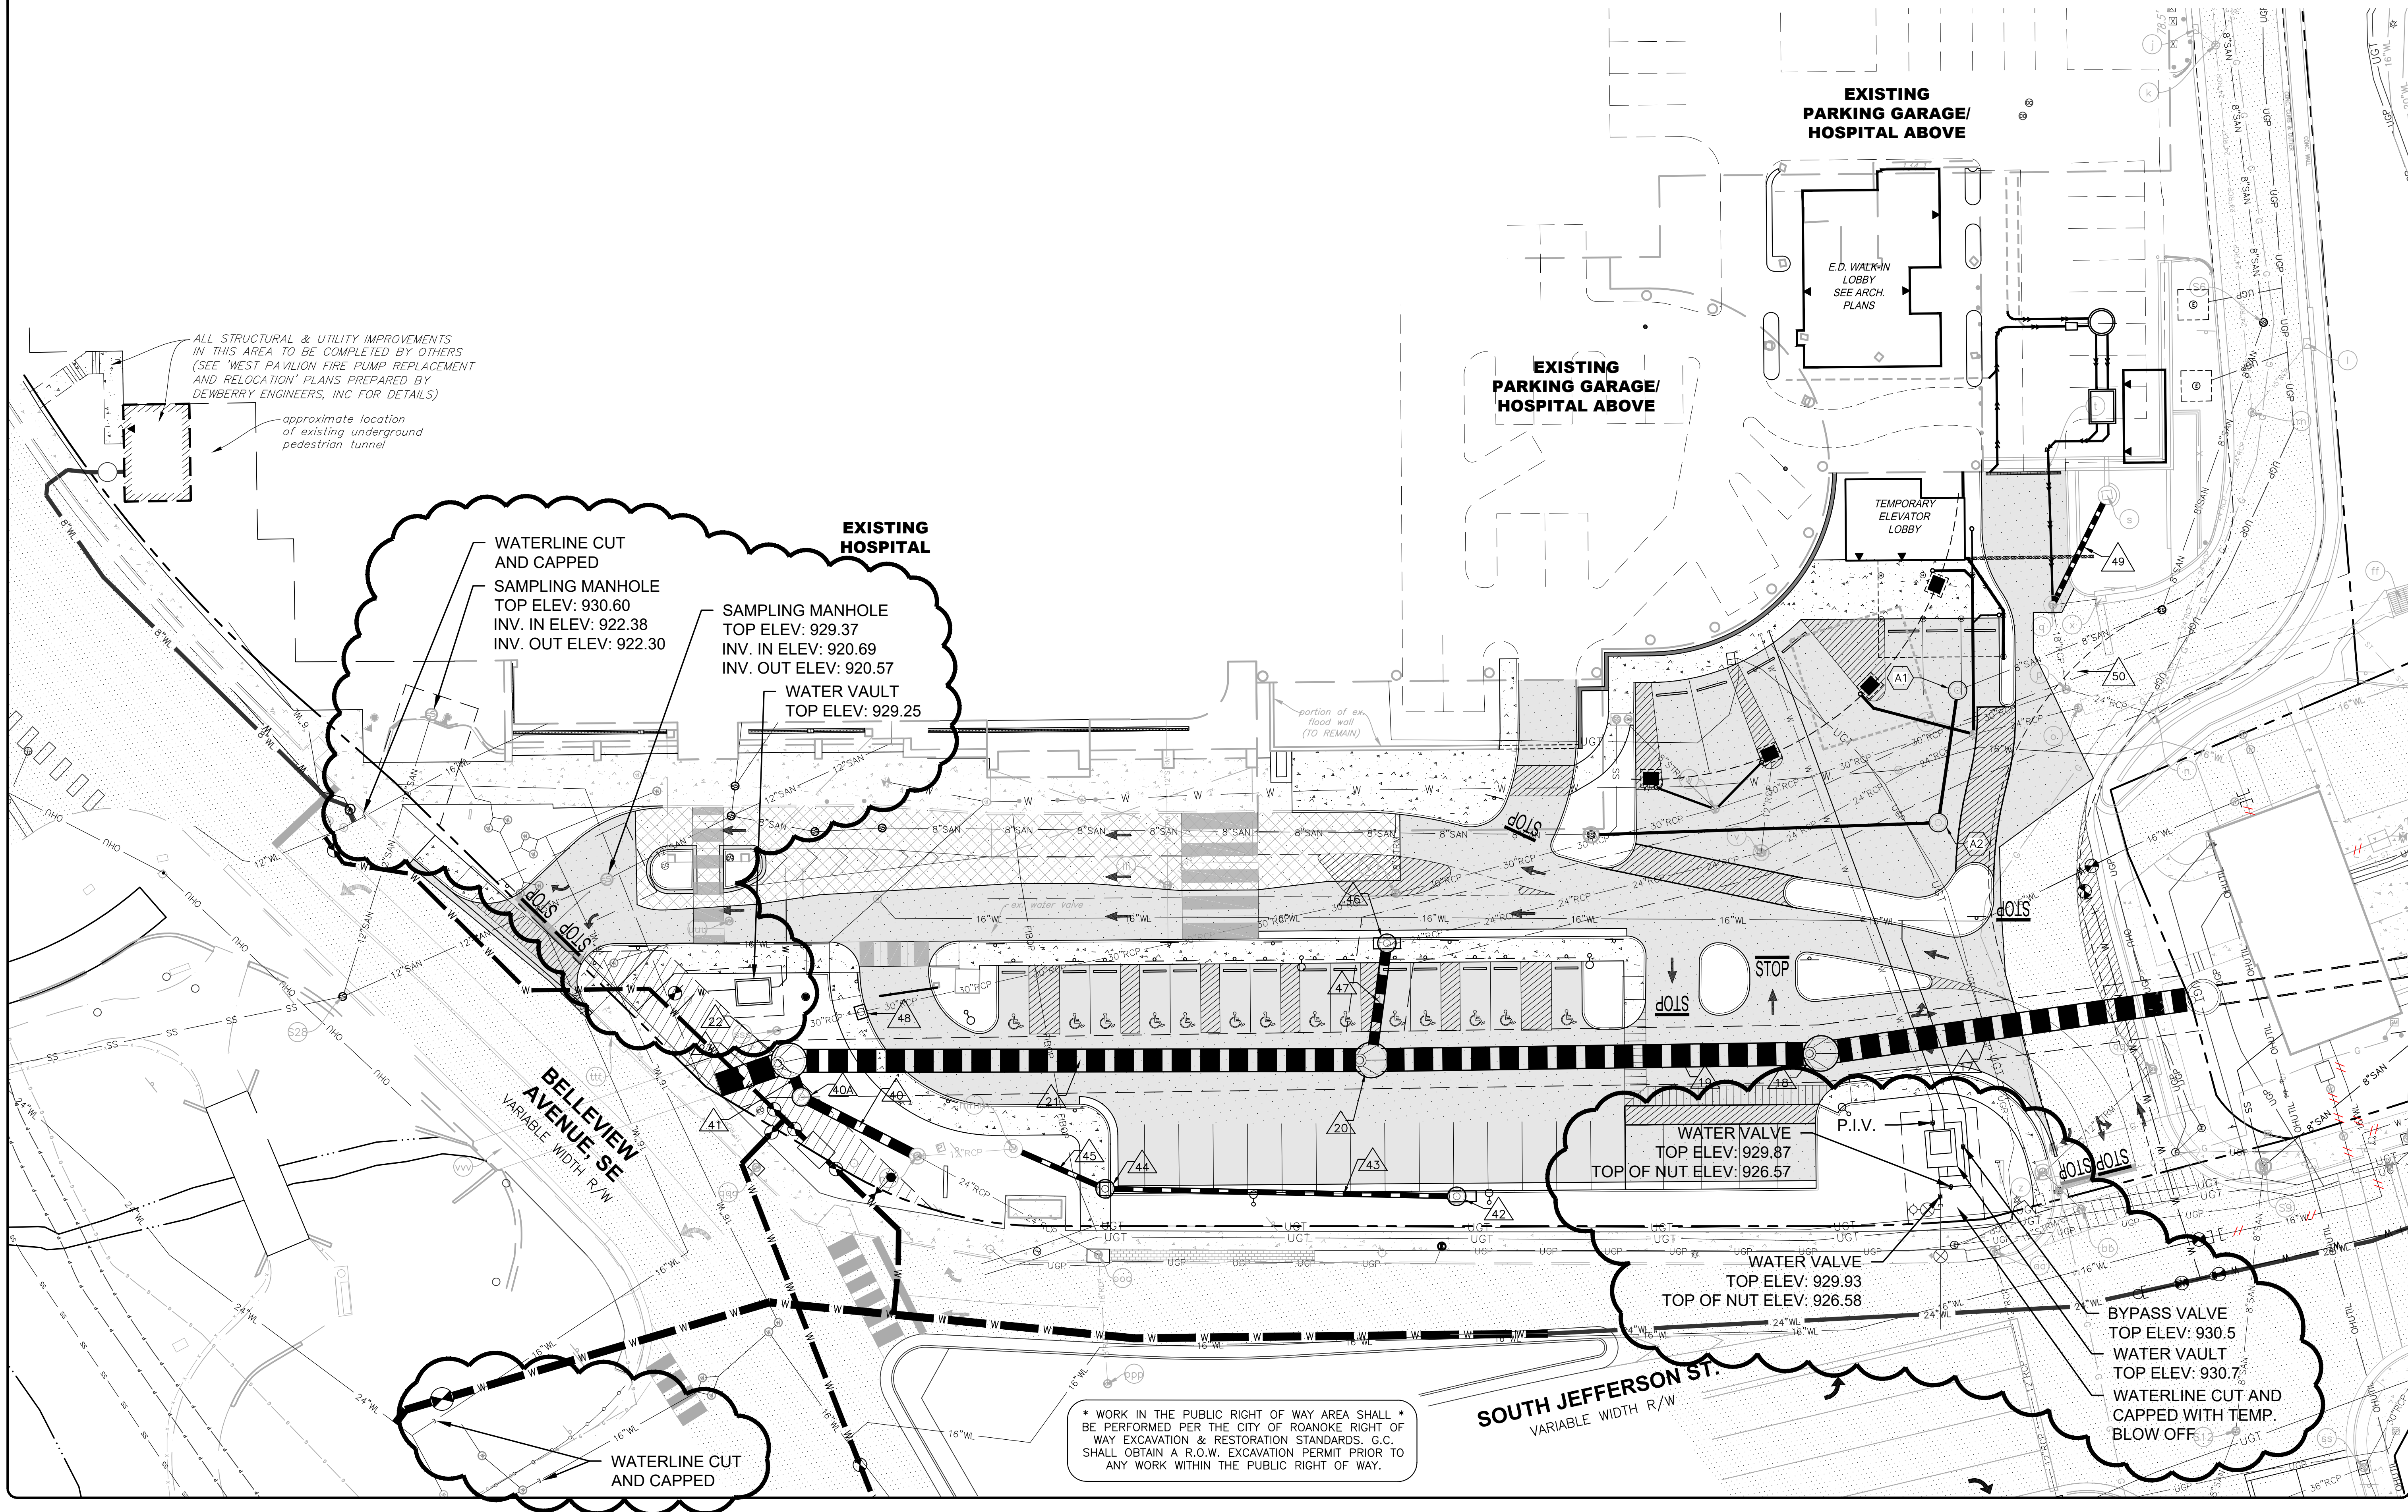

CARILION ROANOKE MEMORIAL HOSPITAL
CRYSTAL SPRING TOWER ADDITIONS & RENOVATIONS - ENABLING PROJECT #1B
UTILITY PLAN (WVWA AS-BUILT)

DRAWN BY EJP
DESIGNED BY SMH
CHECKED BY CPB
DATE 10/25/2022
SCALE 1"=20'
REVISIONS

C4T
PROJECT NO. 04190036.00