

ROANOKE, VIRGINIA
MARCH 2, 2021
COMM. NO. 4049

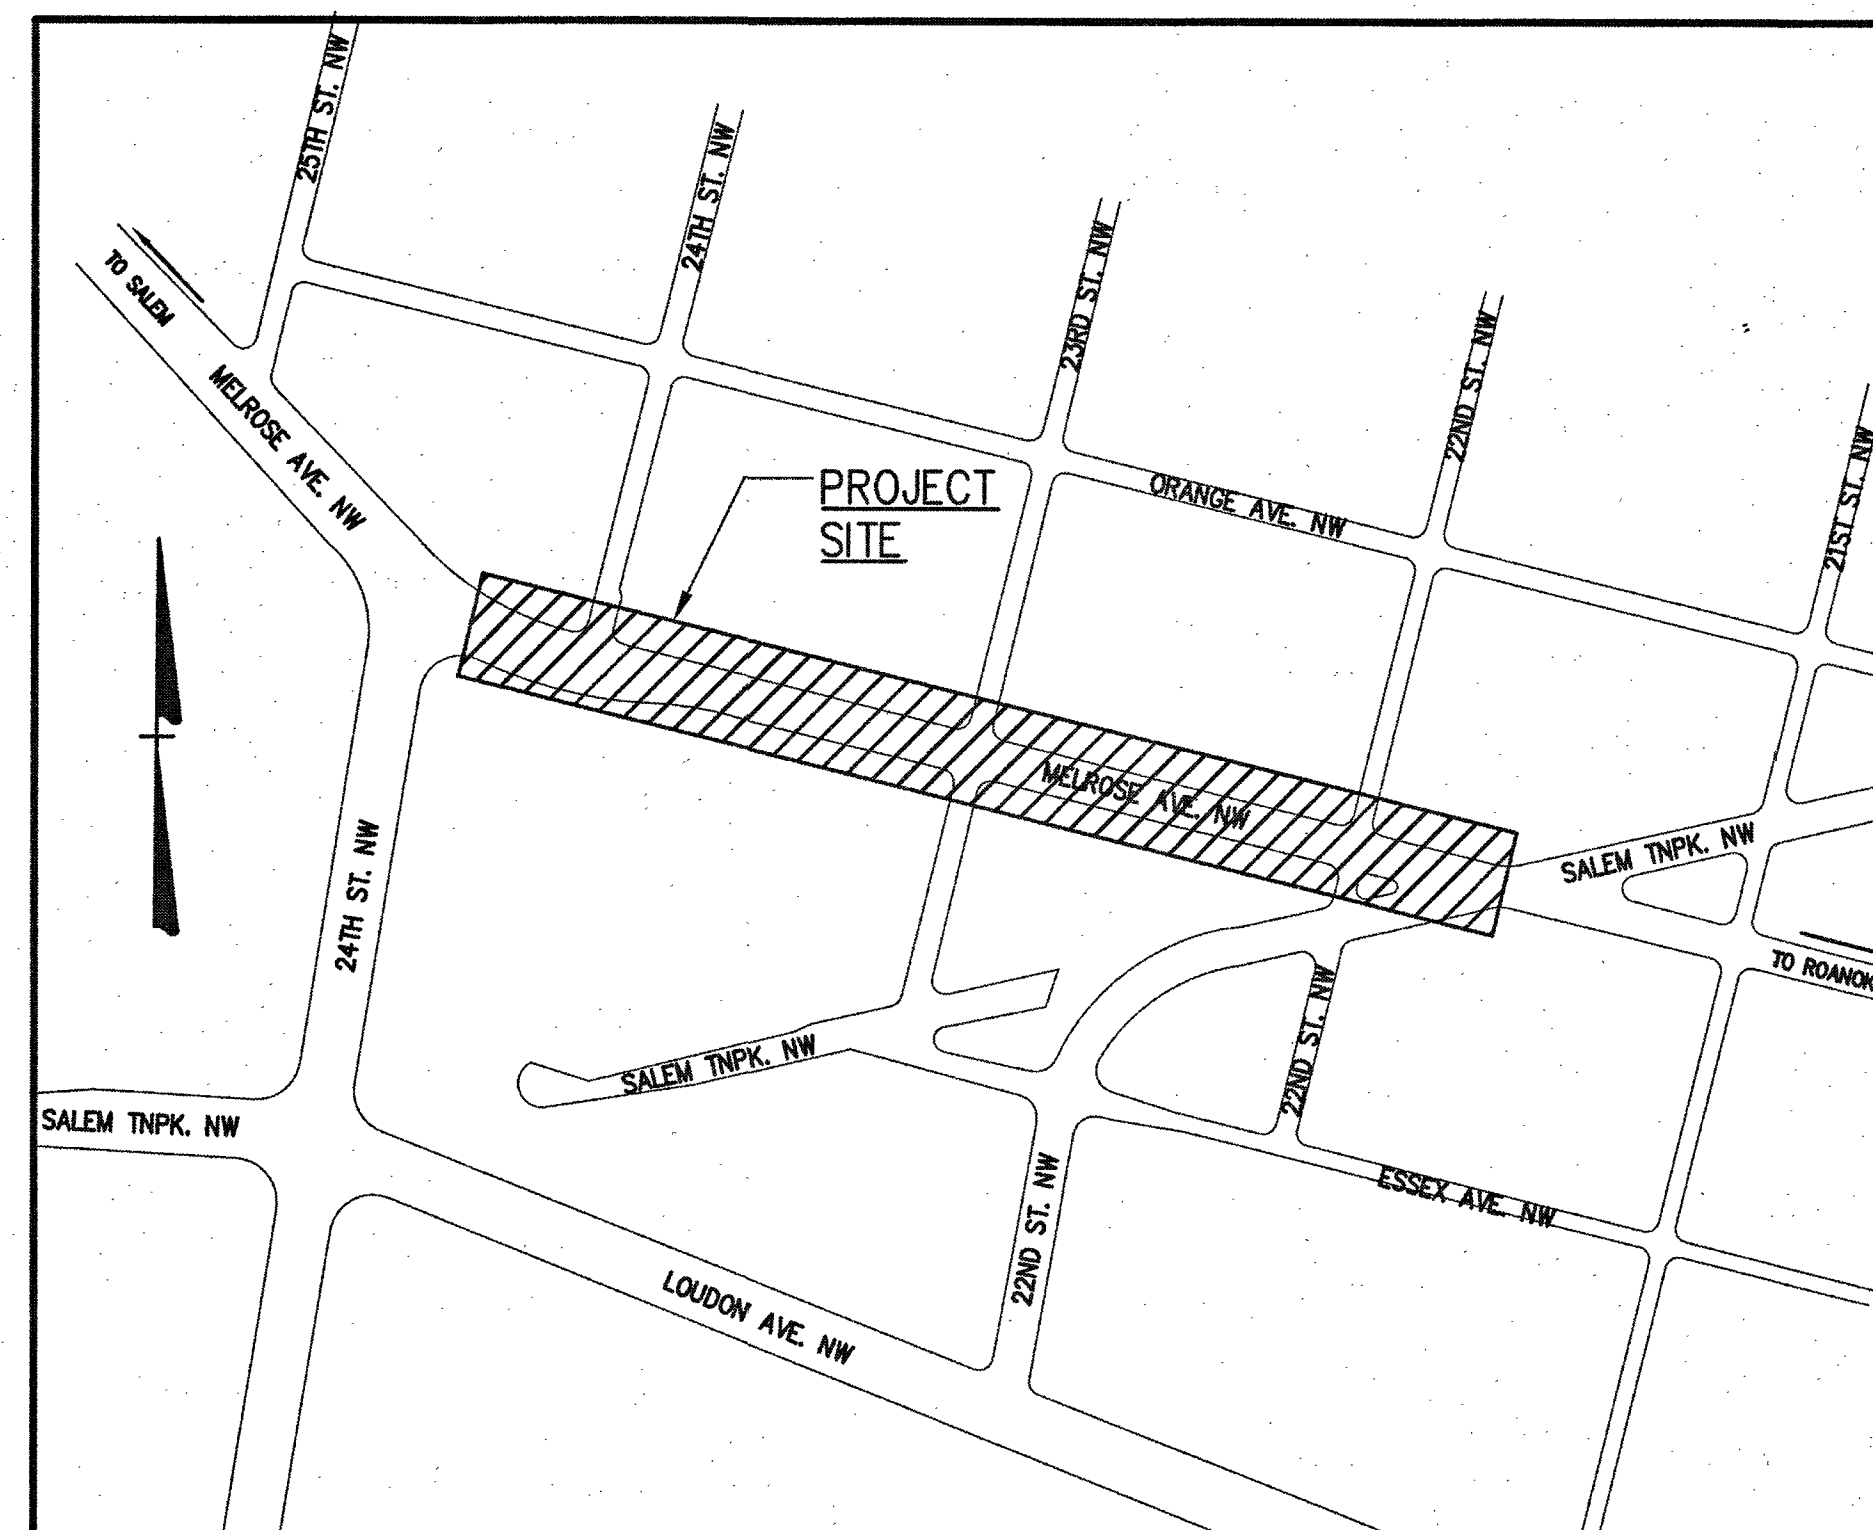
C0.1 TITLE SHEET
C0.2 OVERALL PLAN
C1.1 EXISTING CONDITIONS PLAN - AREA 'A'
C1.2 EXISTING CONDITIONS PLAN - AREA 'B'
C1.3 EXISTING CONDITIONS PLAN - AREA 'C'
C2.1 DEMOLITION AND REMOVAL/E&SC PLAN - AREA 'A'
C2.2 DEMOLITION AND REMOVAL/E&SC PLAN - AREA 'B'
C2.3 DEMOLITION AND REMOVAL/E&SC PLAN - AREA 'C'
C2.4 EROSION AND SEDIMENT CONTROL DETAILS AND MS-19 REQUIREMENTS
C3.1 LAYOUT PLAN - AREA 'A'
C3.2 LAYOUT PLAN - AREA 'B'
C3.3 LAYOUT PLAN - AREA 'C'
C3.4 ENLARGED PLANS AND SECTIONS
C3.5 TYPICAL SECTIONS AND DETAILS
C3.6 TYPICAL SECTIONS AND DETAILS
C3.7 TYPICAL SECTIONS AND DETAILS
C4.1 UTILITY AND STORM DRAINAGE PLAN - AREA 'A'
C4.2 UTILITY AND STORM DRAINAGE PLAN - AREA 'B'
C4.3 UTILITY AND STORM DRAINAGE PLAN - AREA 'C'
C4.4 STORM DRAIN PLAN AND PROFILE
C4.5 DETAILS, SECTIONS AND STORM DRAIN PROFILE
C4.6 12" SANITARY SEWER PROFILES
C4.7 8" WATERLINE PROFILES
C4.8 WATER AND SANITARY SEWER GENERAL NOTES
C4.9 SANITARY SEWER DETAILS
C4.10 SANITARY SEWER AND WATER DETAILS
C4.11 WATER DETAILS
C5.1 PAVEMENT MARKING PLAN - AREA 'A'
C5.2 PAVEMENT MARKING PLAN - AREA 'B'
C5.3 PAVEMENT MARKING PLAN - AREA 'C'
C6.1 LANDSCAPE PLAN - AREA 'A'
C6.2 LANDSCAPE PLAN - AREA 'B'
C6.3 LANDSCAPE PLAN - AREA 'C'
C7.1 POWER AND LIGHTING - AREA 'A'
C7.2 POWER AND LIGHTING - AREA 'B'
C7.3 POWER AND LIGHTING - AREA 'C'
C7.4 POWER AND LIGHTING DETAILS
C7.5 POWER AND LIGHTING DETAILS
C8.0 TRANSPORTATION MANAGEMENT PLAN NOTES
C8.1 MAINTENANCE OF TRAFFIC (M.O.T.) BICYCLE DETOUR PLAN
C8.2 MAINTENANCE OF TRAFFIC (M.O.T.) PLAN - AREA 'A' STAGE IA
C8.3 MAINTENANCE OF TRAFFIC (M.O.T.) PLAN - AREA 'B' STAGE IA
C8.4 MAINTENANCE OF TRAFFIC (M.O.T.) PLAN - AREA 'C' STAGE IA
C8.5 MAINTENANCE OF TRAFFIC (M.O.T.) STAGE IB DETOUR PLAN
C8.6 MAINTENANCE OF TRAFFIC (M.O.T.) PLAN - AREA 'A' STAGE II
C8.7 MAINTENANCE OF TRAFFIC (M.O.T.) PLAN - AREA 'B' STAGE II
C8.8 MAINTENANCE OF TRAFFIC (M.O.T.) PLAN - AREA 'C' STAGE II
C8.9 MAINTENANCE OF TRAFFIC (M.O.T.) STAGE III DETOUR PLAN

Inspector:
Bruce Peters

Contractor:
E.C. Pace

Inspector:
Bruce Peters

Contractor:
EC. Pace



VICINITY MAP
N.T.S.

 
OWNER:
OFFICE OF CITY ENGINEER
MUNICIPAL SOUTH, ROOM 350
215 CHURCH AVE., S.W.
ROANOKE, VA 24011
ATTN. MR. JOSEPHUS JOHNSON-KOROMA, P.E.
PHONE: (540) 853-2706

ENGINEER:
MATTERN AND CRAIG, INC.
701 FIRST ST., S.W.
ROANOKE, VA. 24016
ATTN. MR. TOM AUSTIN
PHONE: (540) 345-9342

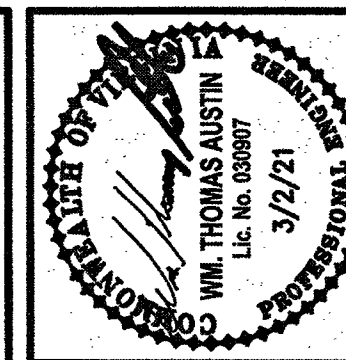
APPROVED FOR CONSTRUCTION


RONANCE CITY ENGINEER DATE 3/9/2021


DIRECTOR OF PUBLIC WORKS DATE 3/9/2021


ASSISTANT CITY MANAGER - OPERATIONS DATE 3/9/2021

CITY PLAN NO.: CP20-0050

[illegible]

Issue Date: **MARCH 2, 2021**
 Drawn By: ARB
 Designed By: ARB
 Checked By: WTA

Matter & Craig
ENGINEERS-SURVEYORS

701 FIRST STREET, S.W.
ROANOKE, VIRGINIA 24016
(540) 345-0342
FAX (540) 345-7891

ROANOKE VIRGINIA

TITLE SHEET

—
MELROSE AVE. STREETSCAPE IMPROVEMENTS —
22ND TO 24TH ST.

Vertical Scale:

Horizontal Scale: N/A

Commission Number:
4049

Sheet No.:

C0.1

As Bu. H+5 6-7-2022
Melrose Street scope