

REFER TO SHEET C3.1 FOR GENERAL NOTES.

SITE LAYOUT KEYNOTES:

- 1

NEW 5-FOOT WIDE (MINIMUM) CONCRETE SIDEWALK. REFER TO DETAIL D8 & D9 ON SHEET C3.5 AND TYPICAL SECTIONS ON SHEET C3.7 FOR ADDITIONAL INFORMATION.
- 2

NEW CONCRETE CURB & GUTTER. REFER TO VDOT STANDARD CG-2 AND CG-6 DETAILS ON SHEET C3.6 AND TYPICAL SECTIONS ON SHEET C3.7 FOR ADDITIONAL INFORMATION.
- 3

NEW CONCRETE DRIVEWAY ENTRANCE. REFER TO DETAILS D10, D11, D12 AND TYPICAL DRIVEWAY SECTIONS ON SHEET C3.5 FOR ADDITIONAL INFORMATION. ALL DRIVEWAYS SHALL CONFORM TO "SIDEWALK ENTRANCE TYPE A" UNLESS NOTED ON PLAN. NOTE THICKENED SIDEWALK DEPTH AT DRIVEWAY APRONS AS SHOWN ON DETAILS D11 AND D12.
- 4

NOT USED THIS SHEET.
- 5

NOT USED THIS SHEET.
- 6

NOT USED THIS SHEET.
- 7

NEW STORM DRAINAGE, WATER, AND SANITARY SEWER SYSTEM - REFER TO SHEETS C4.1 THRU C4.3 FOR NEW STORM DRAINAGE, WATER, AND SANITARY SEWER SYSTEM LAYOUT. NEW OPEN CUT OF PAVEMENT FOR INSTALLATION OF NEW STORM DRAINAGE, WATER, AND SANITARY SEWER SYSTEM. REFER TO DETAIL D1 SHOWN ON SHEET C4.5 FOR PIPE BEDDING AND PAVEMENT RESTORATION INFORMATION.
- 8

EXISTING UTILITY FEATURES (WATER METER, MANHOLE, FIRE HYDRANT, ETC.) SHOWN FOR COORDINATION PURPOSES. REFER TO "UTILITY AND STORM DRAINAGE PLANS" (SHEETS C4.1 THROUGH C4.3) FOR ADDITIONAL INFORMATION AND REQUIREMENTS FOR ADJUSTMENTS AND/OR RELOCATIONS.
- 9

MILL EXISTING PAVEMENT TO EXTENT INDICATED. REFER TO NOTES AND SEQUENCE OF WORK ON SUBSEQUENT SHEETS.
- 10

NEW STREET LIGHTS SHOWN FOR COORDINATION PURPOSES. REFER TO SHEET C7.1 THRU C7.3 FOR "POWER AND LIGHTING PLAN."



Date	
Revisions	

Issue Date:	MARCH 2, 2021
Drawn By:	ARB
Designed By:	ARB
Checked By:	TWA
Date:	3/2/21

Matthew & Craig

ENGINEERS/SURVEYORS

701 FIRST STREET, S.W.
ROANOKE, VIRGINIA 24016
(540) 345-9342
FAX (540) 345-7691

MELROSE AVE. STREETSCAPE IMPROVEMENTS -
22ND TO 24TH ST.

LAYOUT PLAN - AREA 'C'

ROANOKE, VIRGINIA


Vertical Scale:
N/A

Horizontal Scale:
1"= 20'

Commission Number:
4049

Sheet No.:
C3.3

MATCH LINE SEE SHEET C3.2

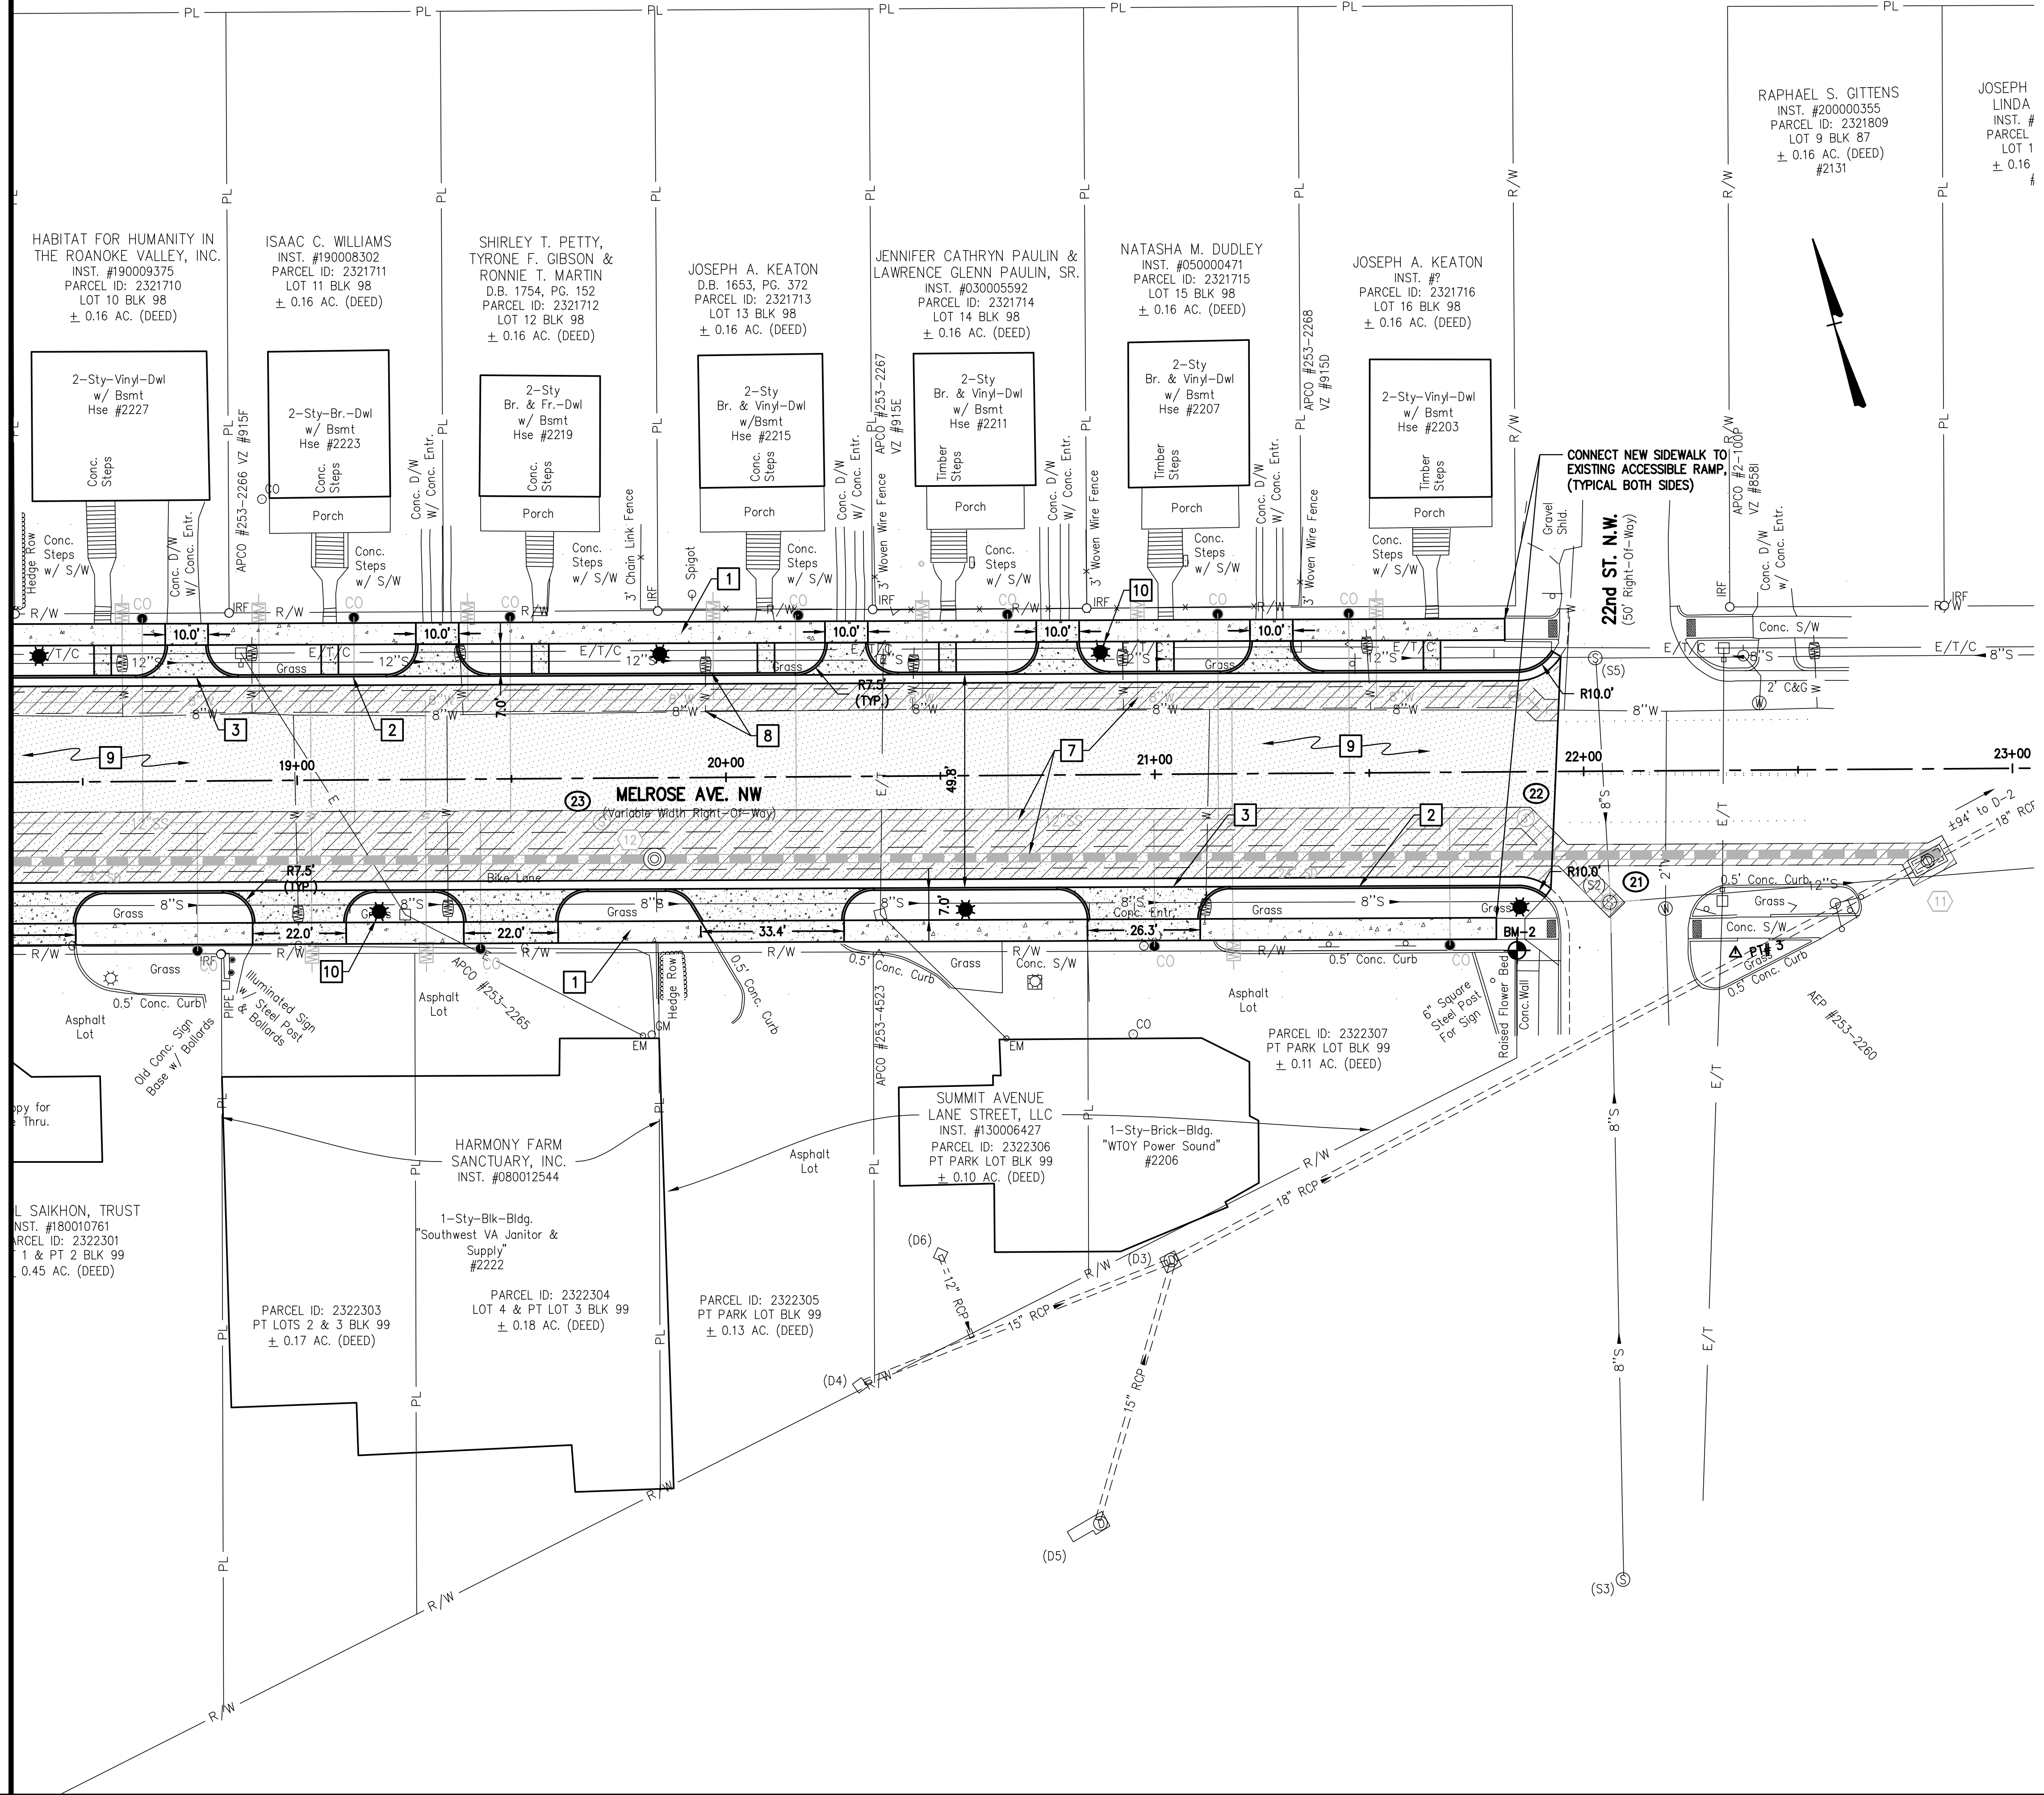

LEGEND:

- UTILITY TRENCH REPAIR

7
- PAVEMENT MILLING AND OVERLAY

9
- CONCRETE SIDEWALK

1 3
- SITE LIGHT FIXTURE (TYP.)

10

