
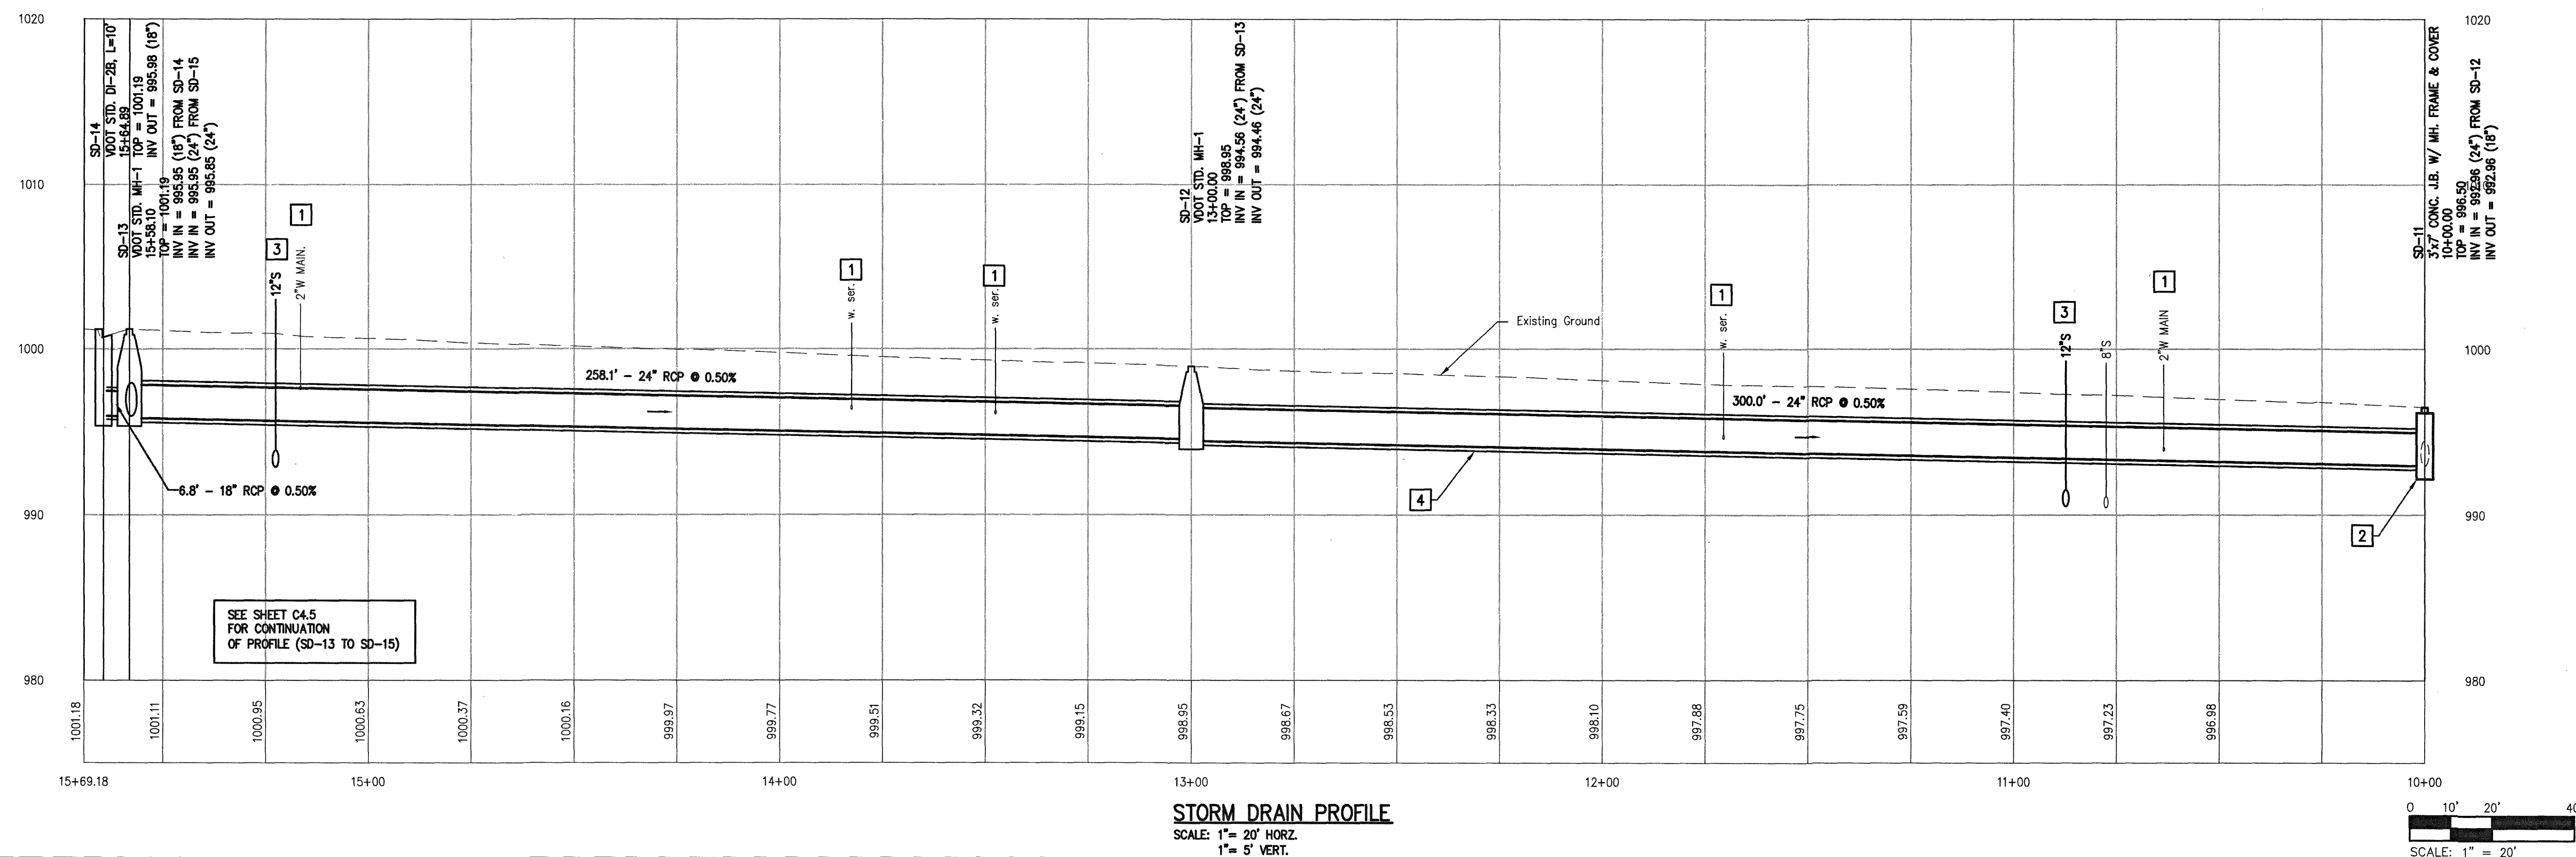
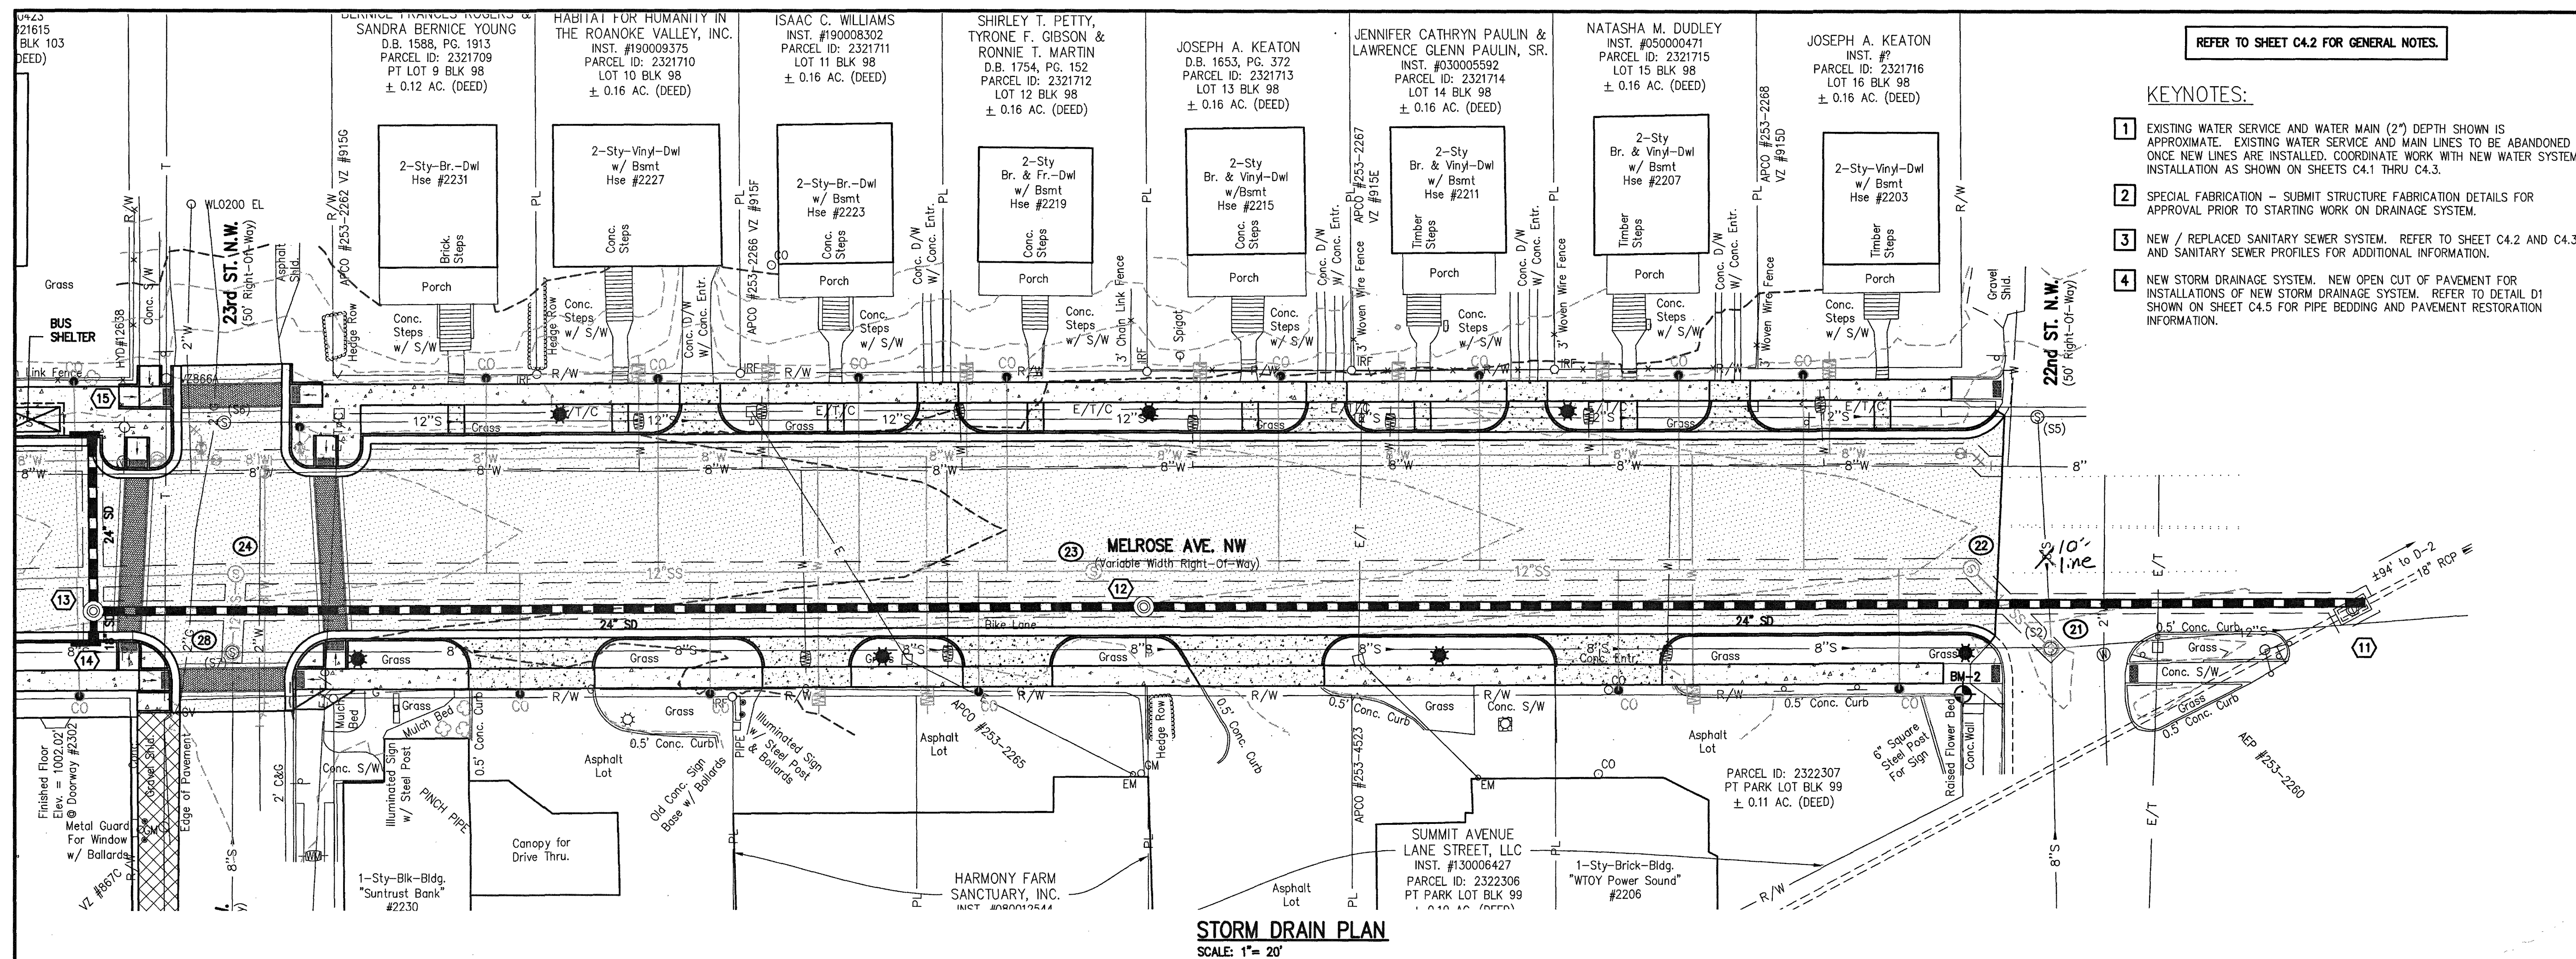


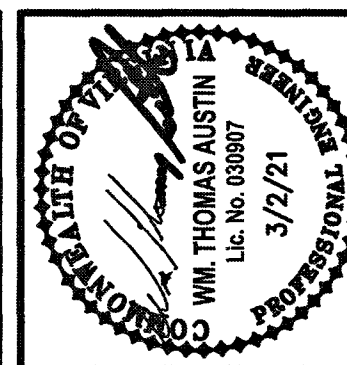

REFER TO SHEET C4.2 FOR GENERAL NOTES.

KEYNOTES:

- 1** EXISTING WATER SERVICE AND WATER MAIN (2") DEPTH SHOWN IS APPROXIMATE. EXISTING WATER SERVICE AND MAIN LINES TO BE ABANDONED ONCE NEW LINES ARE INSTALLED. COORDINATE WORK WITH NEW WATER SYSTEM INSTALLATION AS SHOWN ON SHEETS C4.1 THRU C4.3.
- 2** SPECIAL FABRICATION - SUBMIT STRUCTURE FABRICATION DETAILS FOR APPROVAL PRIOR TO STARTING WORK ON DRAINAGE SYSTEM.
- 3** NEW / REPLACED SANITARY SEWER SYSTEM. REFER TO SHEET C4.2 AND C4.3 AND SANITARY SEWER PROFILES FOR ADDITIONAL INFORMATION.
- 4** NEW STORM DRAINAGE SYSTEM. NEW OPEN CUT OF PAVEMENT FOR INSTALLATIONS OF NEW STORM DRAINAGE SYSTEM. REFER TO DETAIL D1 SHOWN ON SHEET C4.5 FOR PIPE BEDDING AND PAVEMENT RESTORATION INFORMATION.

[illegible]

Issue Date: **MARCH 2, 2021**
 Drawn By: ARB
 Designed By: ARB
 Checked By: WTA
 Date: 3/2/21

Mattern & Craig
ENGINEERS•SURVEYORS

701 FIRST STREET, S.W.
ROANOKE, VIRGINIA 24016
(540) 345-9342
FAX (540) 345-7691

MELROSE AVE., STREETSCAPE IMPROVEMENTS -
22ND TO 24TH ST.
STORM DRAIN PLAN AND PROFILE

Vertical Scale:
AS NOTED

Horizontal Scale:
1" = 20'

Commission Number:
4049

Sheet No.:

C4.4