


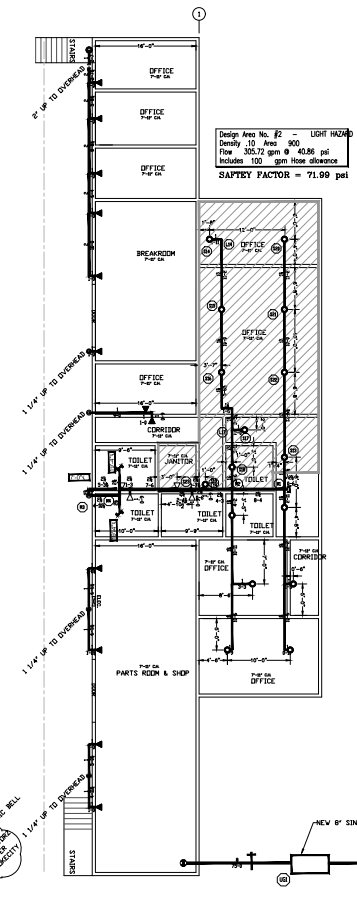

 The Virginia Department of Transportation Division of Highways 1000 North 17th Street Richmond, Virginia 23218 Telephone (800) 670-6787 Fax (800) 670-6789 This drawing was prepared by a professional engineer and is a part of a contract with the State of Virginia. It is not to be used for any other purpose without the written consent of the State of Virginia. The engineer and the State of Virginia assume no liability for the use or misuse of this drawing for any purpose other than that for which it was prepared. The engineer and the State of Virginia assume no liability for the use or misuse of this drawing for any purpose other than that for which it was prepared.	Approved by Tommy Hahn 12/20/2007 8:06:04 AM
--	---

CHECK BY: REGGIE MCGHEE NICET CERT. NO. 95963	SCALE: 1" = 1'-0"  SCALE: 1" = 1'-0"  SCALE: 1" = 1'-0" 
--	--

CLIENT: L & M PROPERTIES	
 ROANOKE SPRINKLER, INC. FIRE PROTECTION SYSTEMS	
	1334 7TH STREET N.E. ROANOKE, VIRGINIA 24012 (540) 981-0009 FAX (540) 981-1010
	SPRINKLER PLANS & DETAILS
	SHEET No. 2

JOB No.	APRIL WAY DRIVE PROJECT
DATE	8-18-21
DESIGNER	J.T.G.
SCALE	AS NOTED

3453 ARIEL WAY DRIVE ROANOKE, VA.	2 OF
--	--