
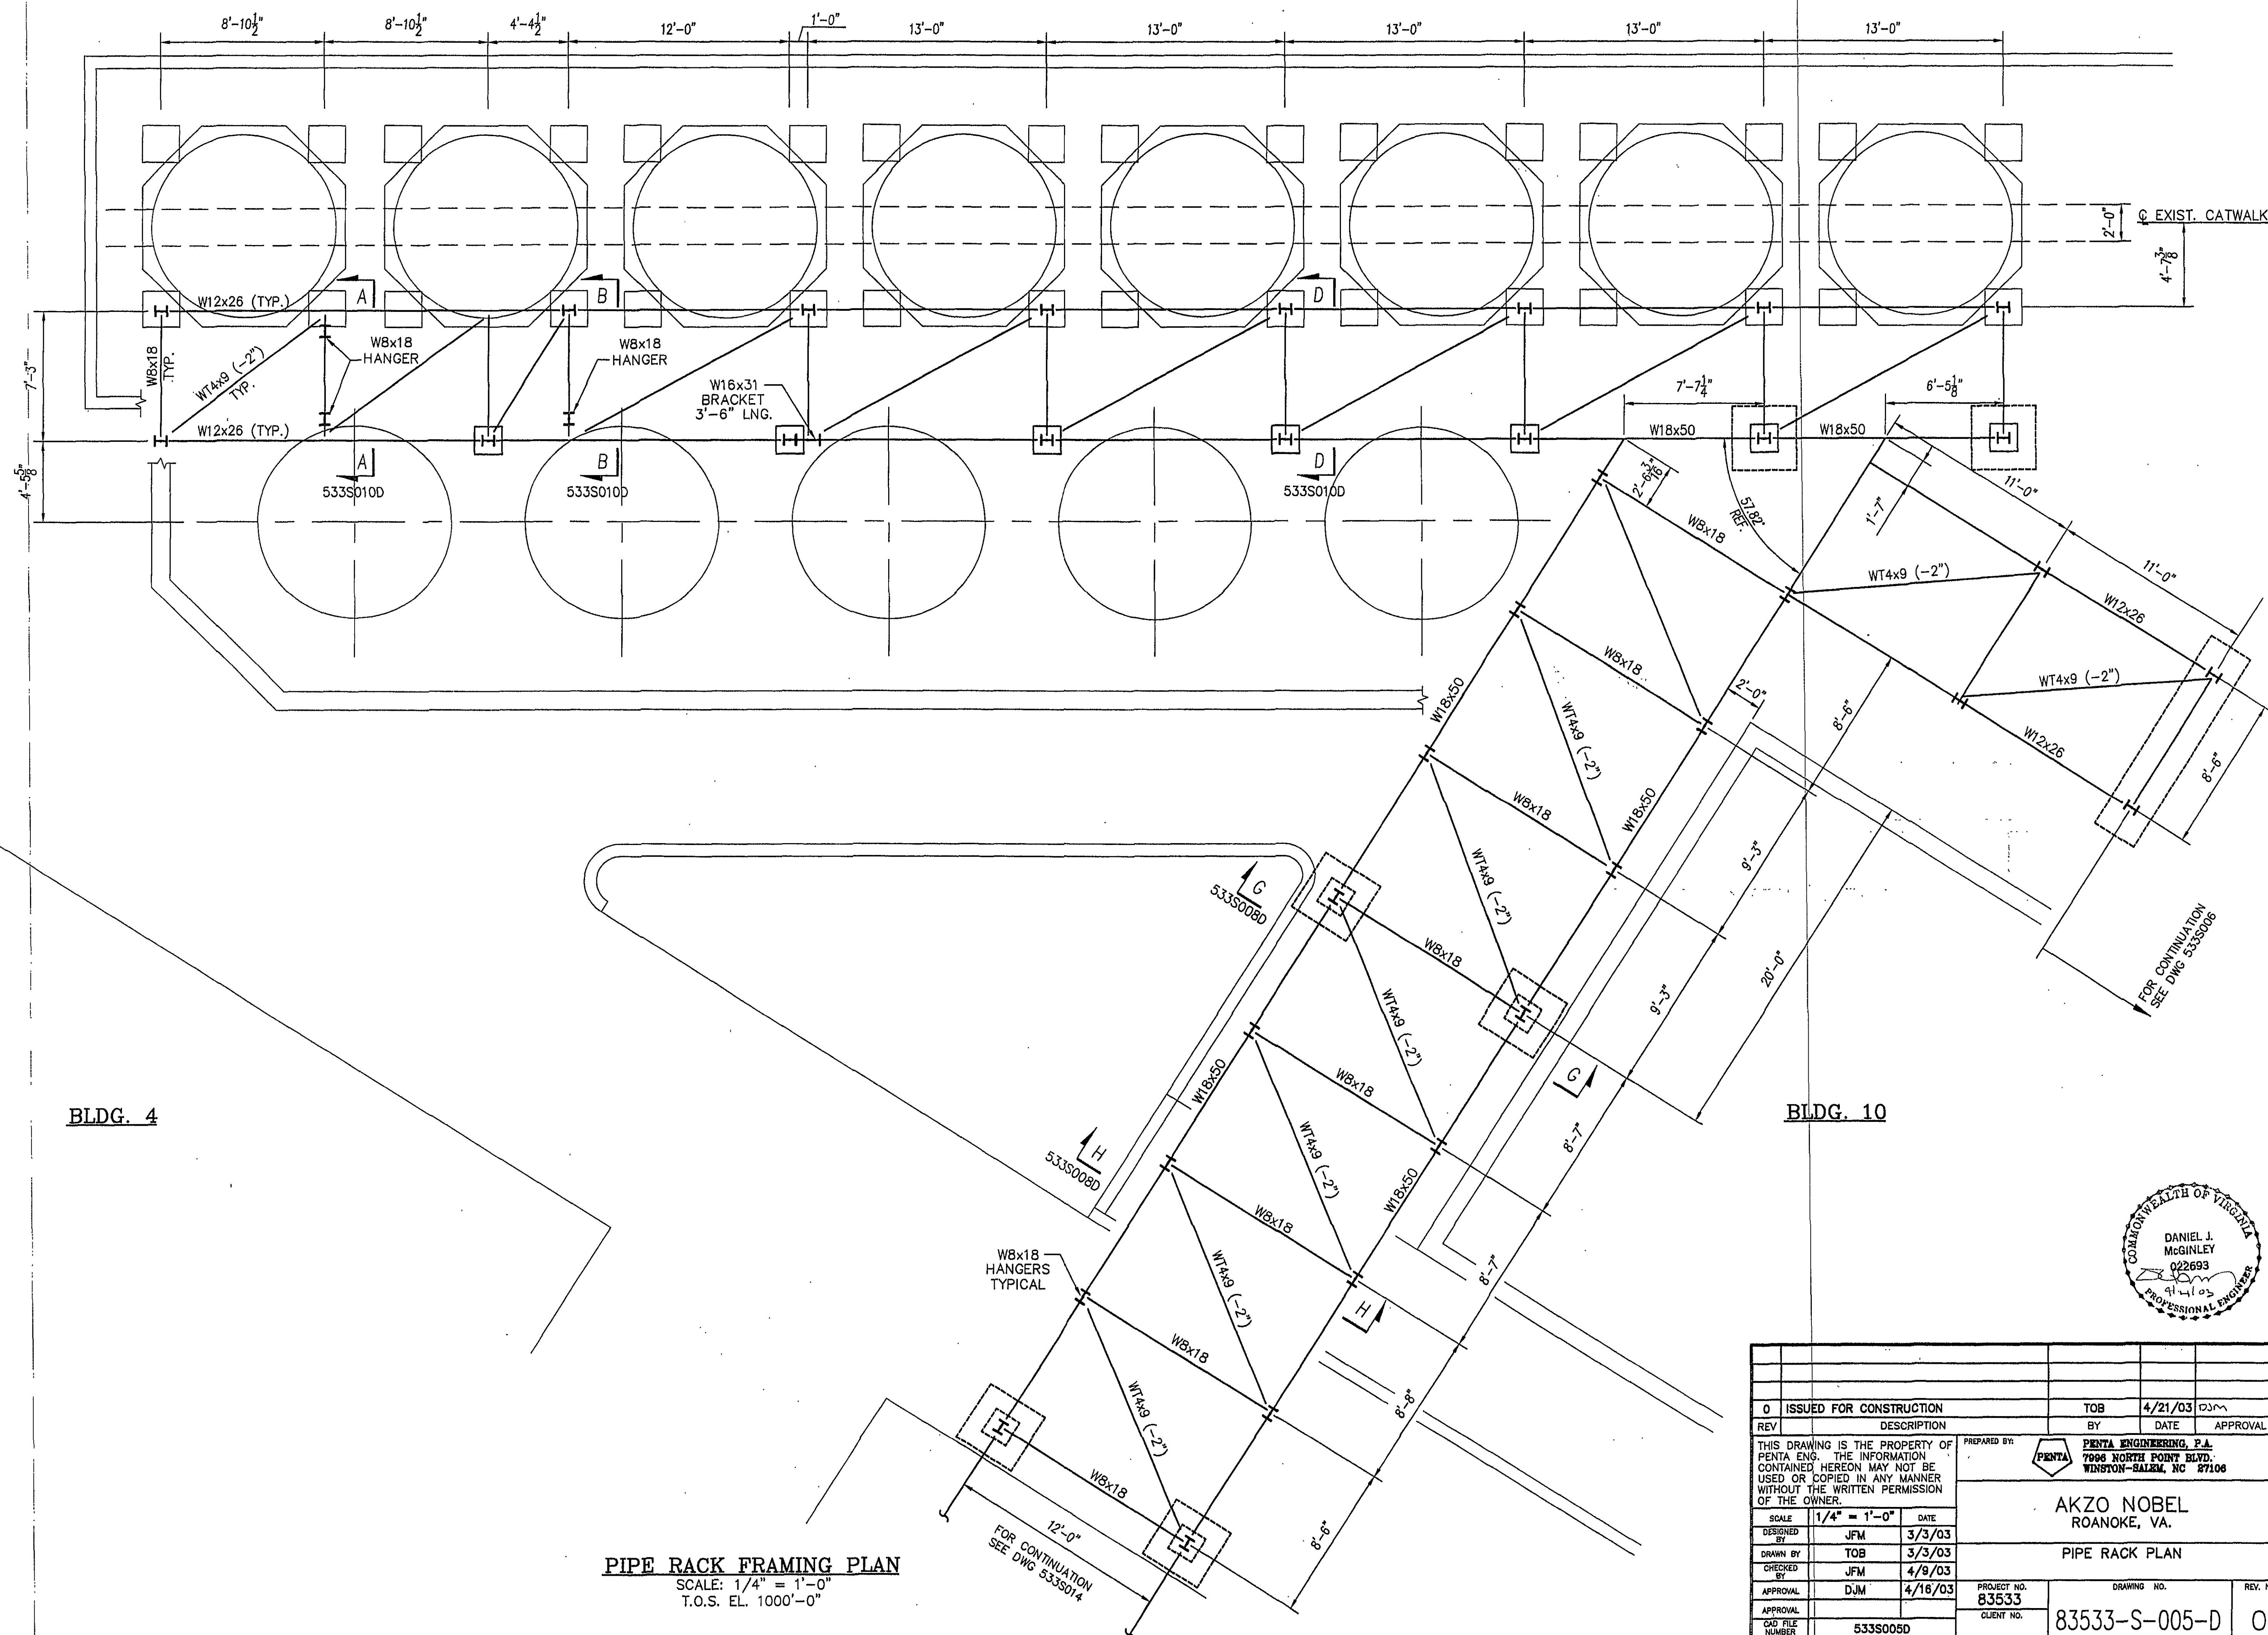


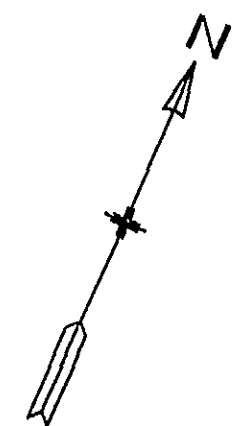

PIPE RACK FRAMING PLAN
SCALE: 1/4" = 1'-0"
T.O.S. EL. 1000'-0"

0 ISSUED FOR CONSTRUCTION		TOB	4/21/03	DJM
REV	DESCRIPTION	BY	DATE	APPROVAL
THIS DRAWING IS THE PROPERTY OF PENTA ENG. THE INFORMATION CONTAINED HEREON MAY NOT BE USED OR COPIED IN ANY MANNER WITHOUT THE WRITTEN PERMISSION OF THE OWNER.		PREPARED BY: PENTA ENGINEERING, P.A. 7090 NORTH POINT BLVD. WINSTON-SALEM, NC 27106		
SCALE	1/4" = 1'-0"	DATE	AKZO NOBEL ROANOKE, VA.	
DESIGNED BY	JFM	3/3/03	PIPE RACK PLAN	
DRAWN BY	TOB	3/3/03		
CHECKED BY	JFM	4/8/03		
APPROVAL	DJM	4/16/03		
CAD FILE NUMBER	533S005D	PROJECT NO. 83533	DRAWING NO. 83533-S-005-D	REV. NO. 0