


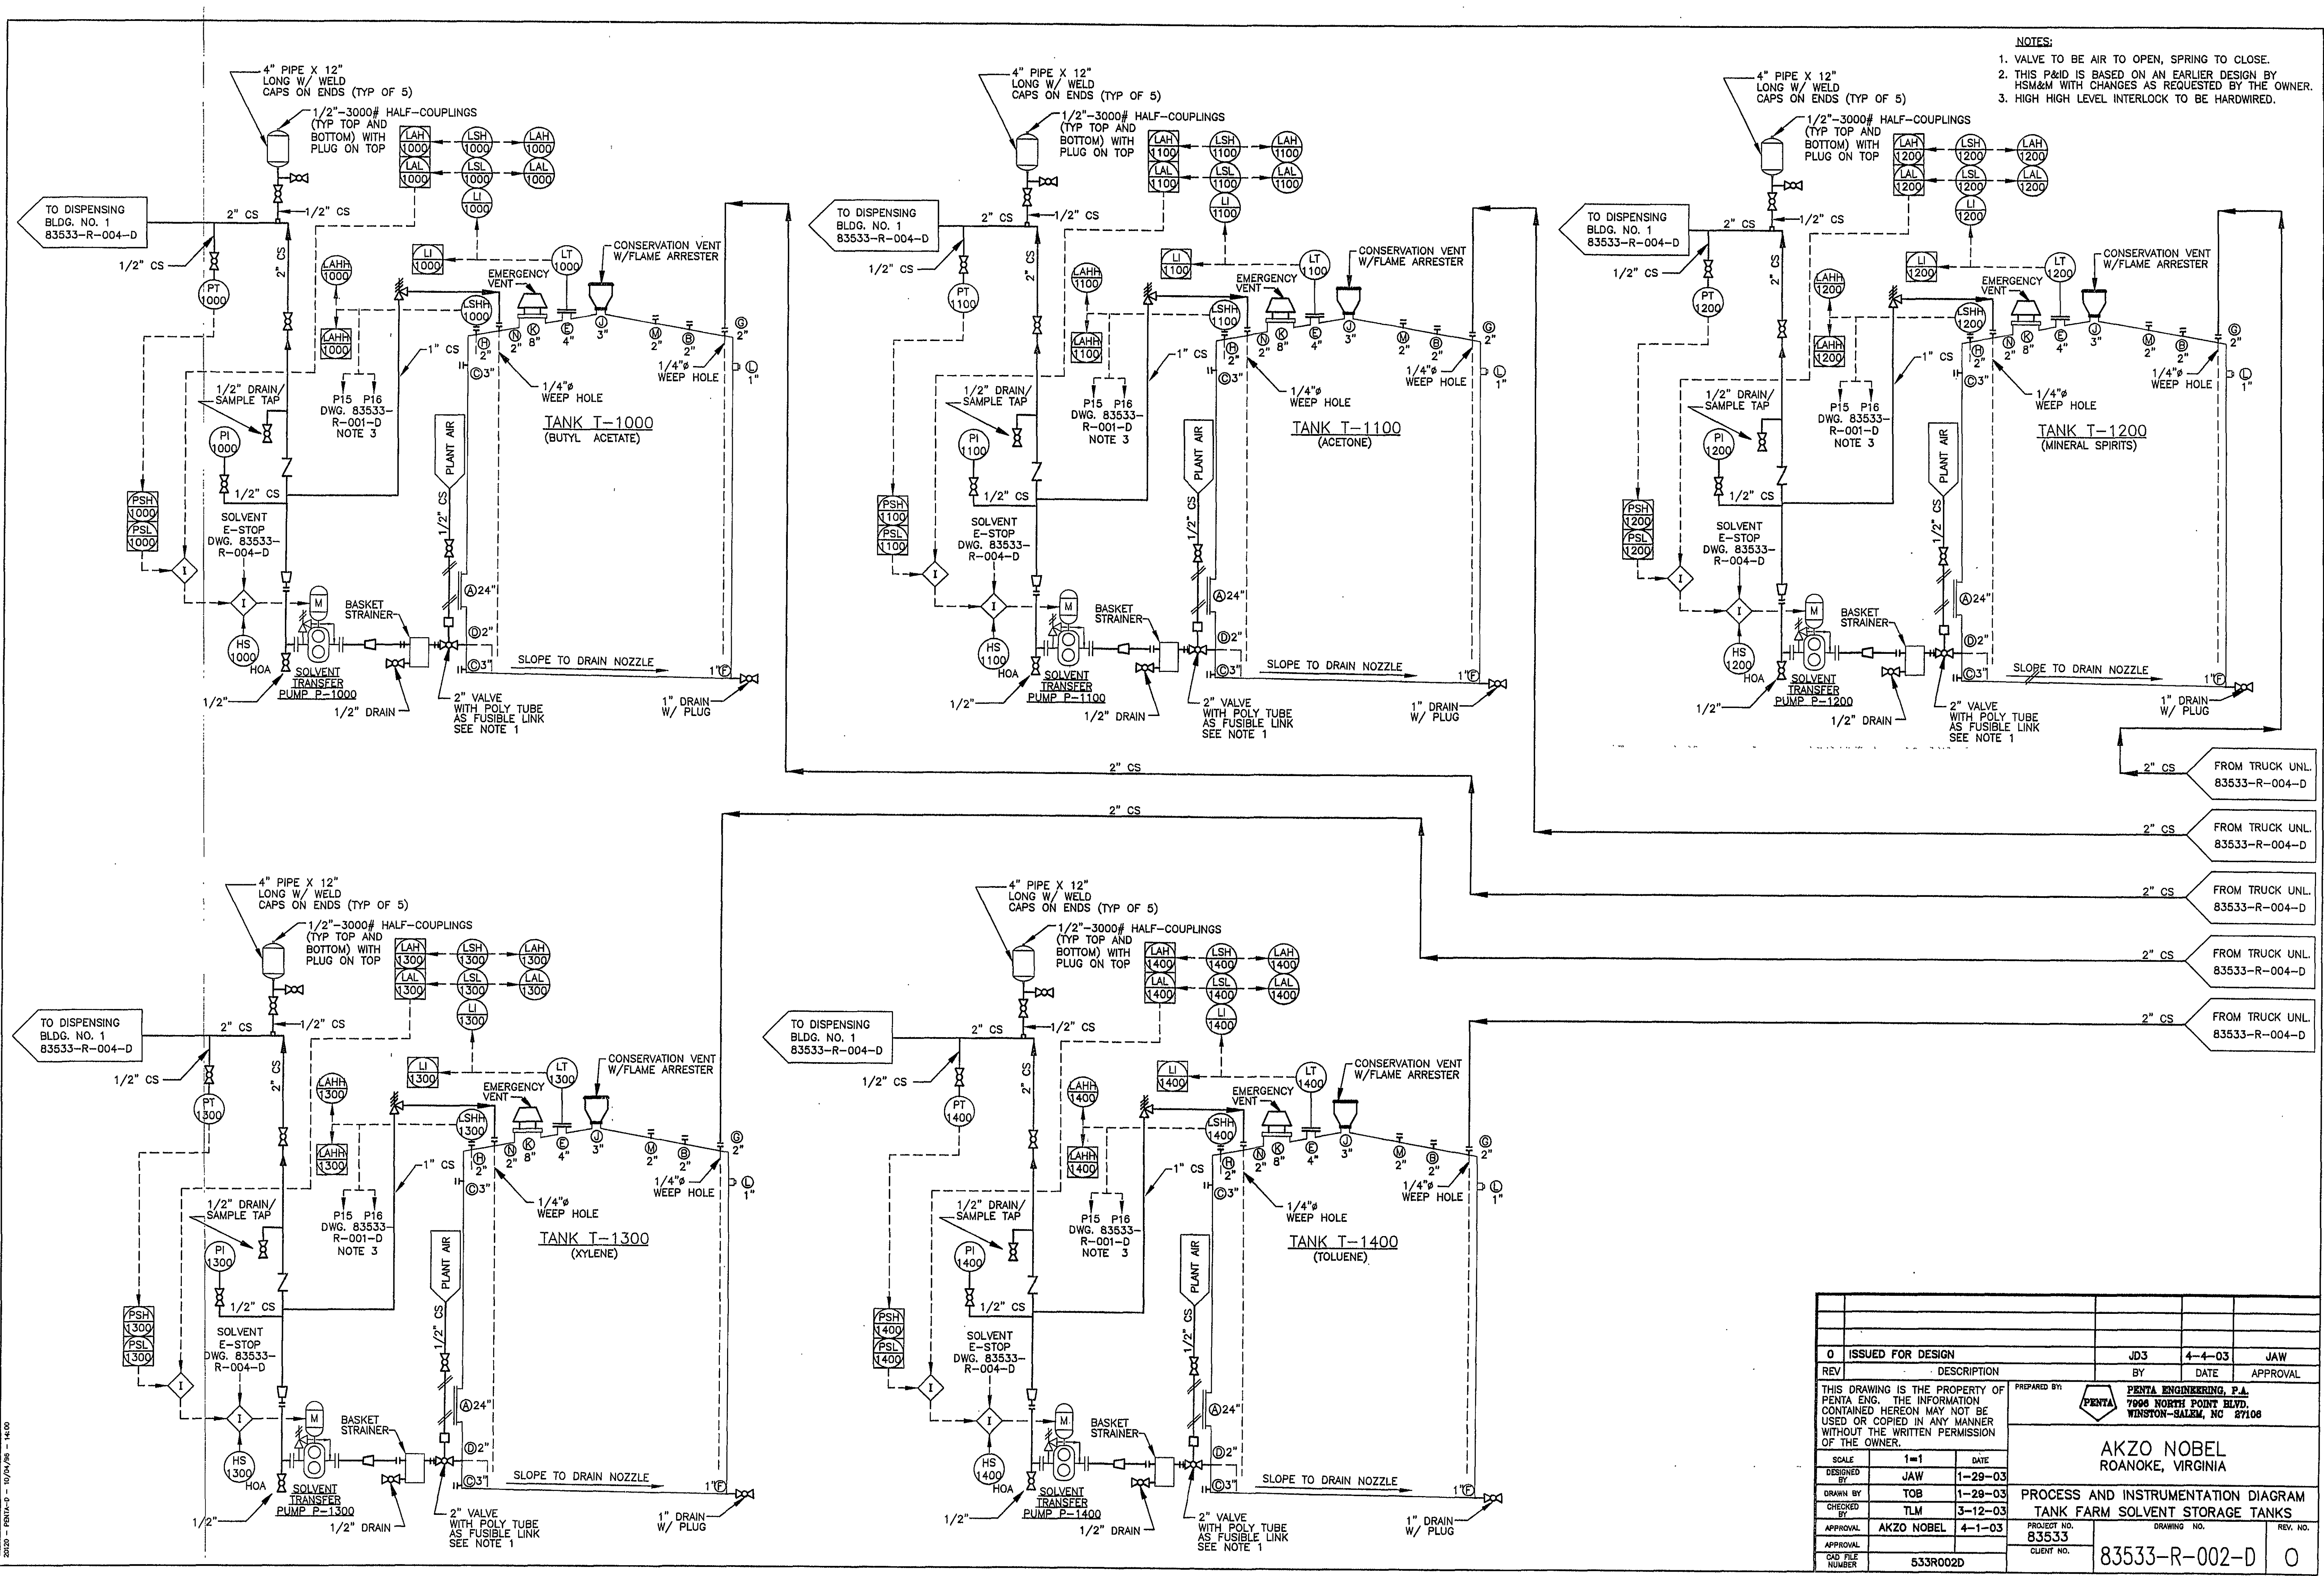

- NOTES:
1. VALVE TO BE AIR TO OPEN, SPRING TO CLOSE.
 2. THIS P&ID IS BASED ON AN EARLIER DESIGN BY HSM&M WITH CHANGES AS REQUESTED BY THE OWNER.
 3. HIGH HIGH LEVEL INTERLOCK TO BE HARDWIRED.

0	ISSUED FOR DESIGN		JD3	4-4-03	JAW
REV	DESCRIPTION		BY	DATE	APPROVAL
THIS DRAWING IS THE PROPERTY OF PENTA ENG. THE INFORMATION CONTAINED HEREON MAY NOT BE USED OR COPIED IN ANY MANNER WITHOUT THE WRITTEN PERMISSION OF THE OWNER.			PREPARED BY: PENTA ENGINEERING, P.A. 7096 NORTH POINT BLVD. WINSTON-SALEM, NC 27106		
			AKZO NOBEL ROANOKE, VIRGINIA		
SCALE	1"=1'	DATE			
DESIGNED BY	JAW	1-29-03			
DRAWN BY	TOB	1-29-03			
CHECKED BY	TLM	3-12-03			
APPROVAL	AKZO NOBEL		4-1-03		
APPROVAL					
CAD FILE NUMBER	533R002D				
			DRAWING NO.		REV. NO.
			PROJECT NO. 83533		
			CLIENT NO.		
			85333-R-002-D		0