


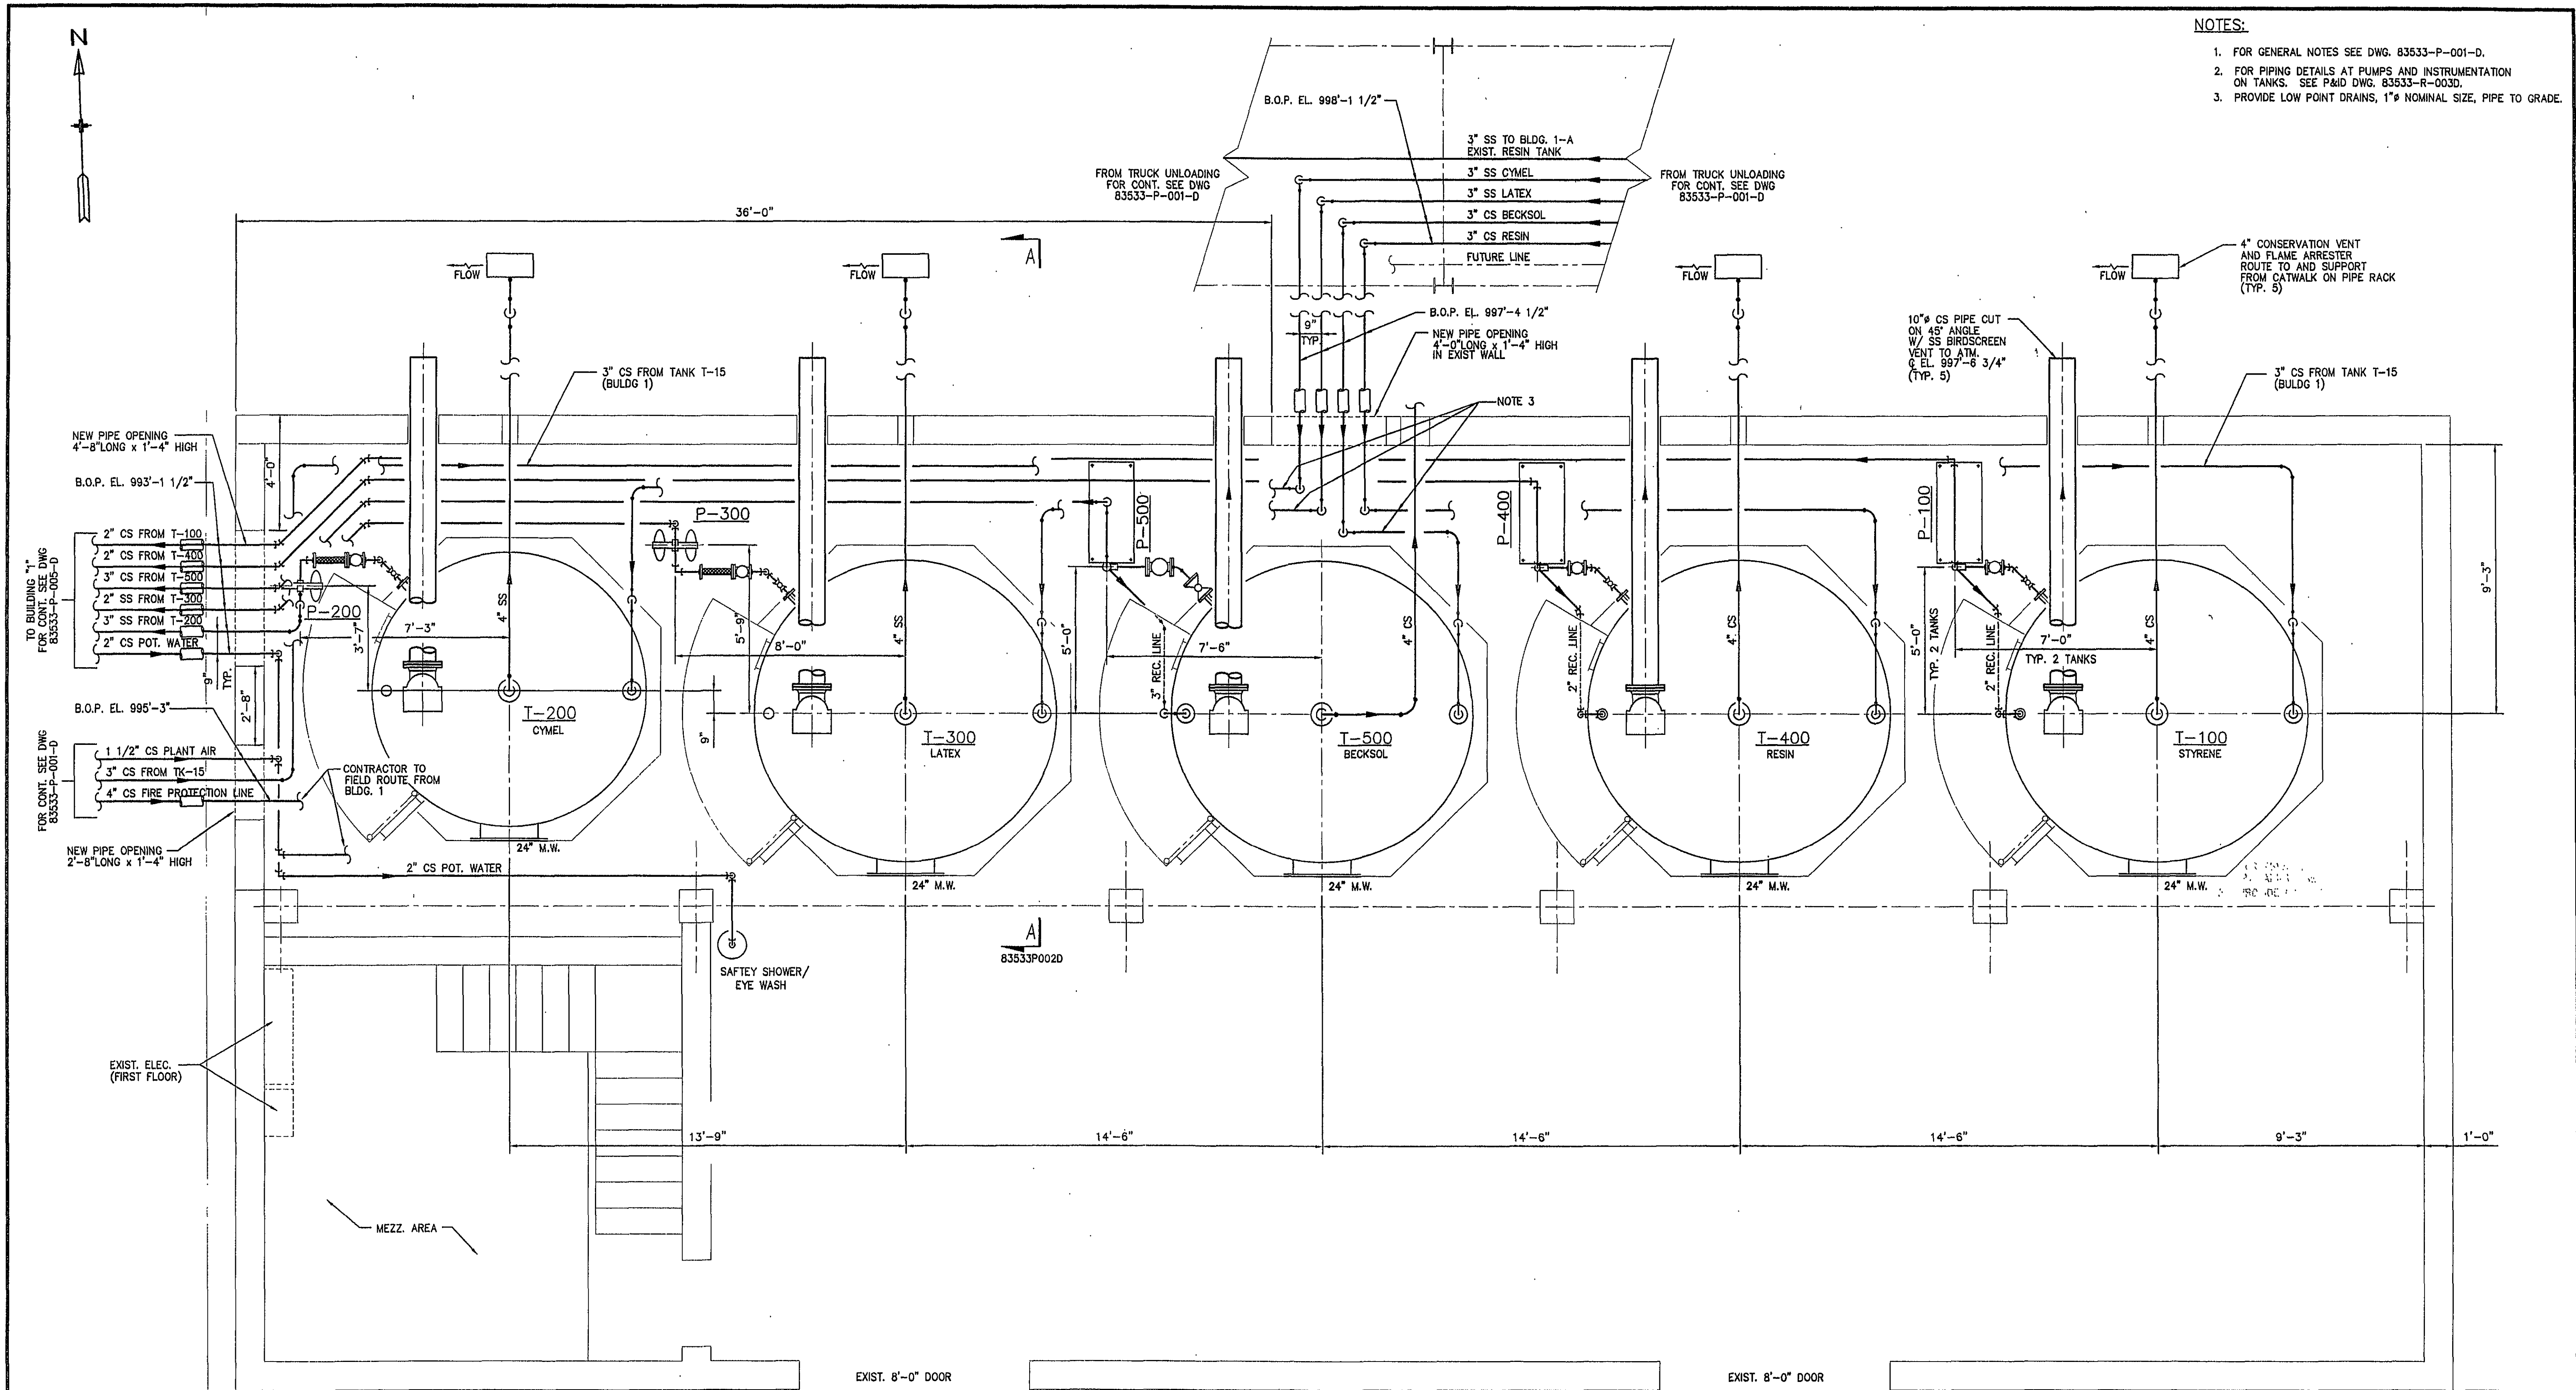

- NOTES:**
1. FOR GENERAL NOTES SEE DWG. 83533-P-001-D.
  2. FOR PIPING DETAILS AT PUMPS AND INSTRUMENTATION ON TANKS. SEE P&ID DWG. 83533-R-003D.
  3. PROVIDE LOW POINT DRAINS, 1" NOMINAL SIZE, PIPE TO GRADE.

**BUILDING "10" PLAN**  
T.O.C. EL. 97'9" - 10' 3/4"

|                                                                                                                                                                  |             |                                                                                                                                                                                                                                              |         |          |
|------------------------------------------------------------------------------------------------------------------------------------------------------------------|-------------|----------------------------------------------------------------------------------------------------------------------------------------------------------------------------------------------------------------------------------------------|---------|----------|
| 0 ISSUED FOR CONSTRUCTION                                                                                                                                        |             | JD3                                                                                                                                                                                                                                          | 4/16/03 | TLM      |
| REV                                                                                                                                                              | DESCRIPTION | BY                                                                                                                                                                                                                                           | DATE    | APPROVAL |
| THIS DRAWING IS THE PROPERTY OF PENTA ENG. THE INFORMATION CONTAINED HEREON MAY NOT BE USED OR COPIED IN ANY MANNER WITHOUT THE WRITTEN PERMISSION OF THE OWNER. |             |                                                                                                                                                                                                                                              |         |          |
| SCALE 3/8" = 1'-0"<br>DESIGNED BY JD3<br>DRAWN BY JD3<br>CHECKED BY TLM<br>APPROVAL AKZO NOBEL<br>APPROVAL<br>CAD FILE NUMBER 533P004D                           |             | PREPARED BY: PENTA ENGINEERING, P.A.<br>7896 NORTH POINT BLVD.<br>WINSTON-SALEM, NC 27106<br>AKZO NOBEL<br>ROANOKE, VA.<br>BUILDING 10 RESIN BULK STORAGE<br>GENERAL ARRANGMENT/PIPING PLAN<br>PROJECT NO. 83533<br>CLIENT NO. 83533-P-004-D |         |          |
| DATE 1/30/03                                                                                                                                                     |             | REV. NO. 0                                                                                                                                                                                                                                   |         |          |
| DATE 1/31/03                                                                                                                                                     |             |                                                                                                                                                                                                                                              |         |          |
| DATE 3/13/03                                                                                                                                                     |             |                                                                                                                                                                                                                                              |         |          |
| DATE 3/21/03                                                                                                                                                     |             |                                                                                                                                                                                                                                              |         |          |

2010 - PENTA-D - 10/04/03 - 1400