



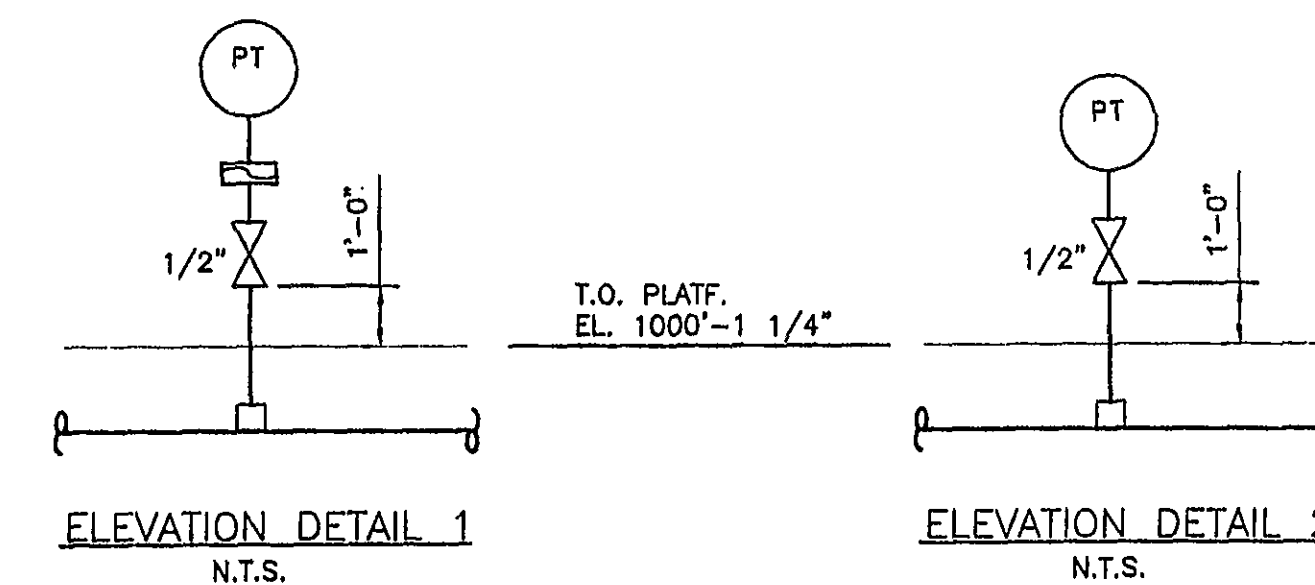

NOTES:

1. FOR GENERAL NOTES SEE DWG. 83533-P-001-D.
2. FOR DETAILS OF PUMP PIPING AND TANK INSTRUMENTATION SEE P&ID DWG. 83533-R-002-D.

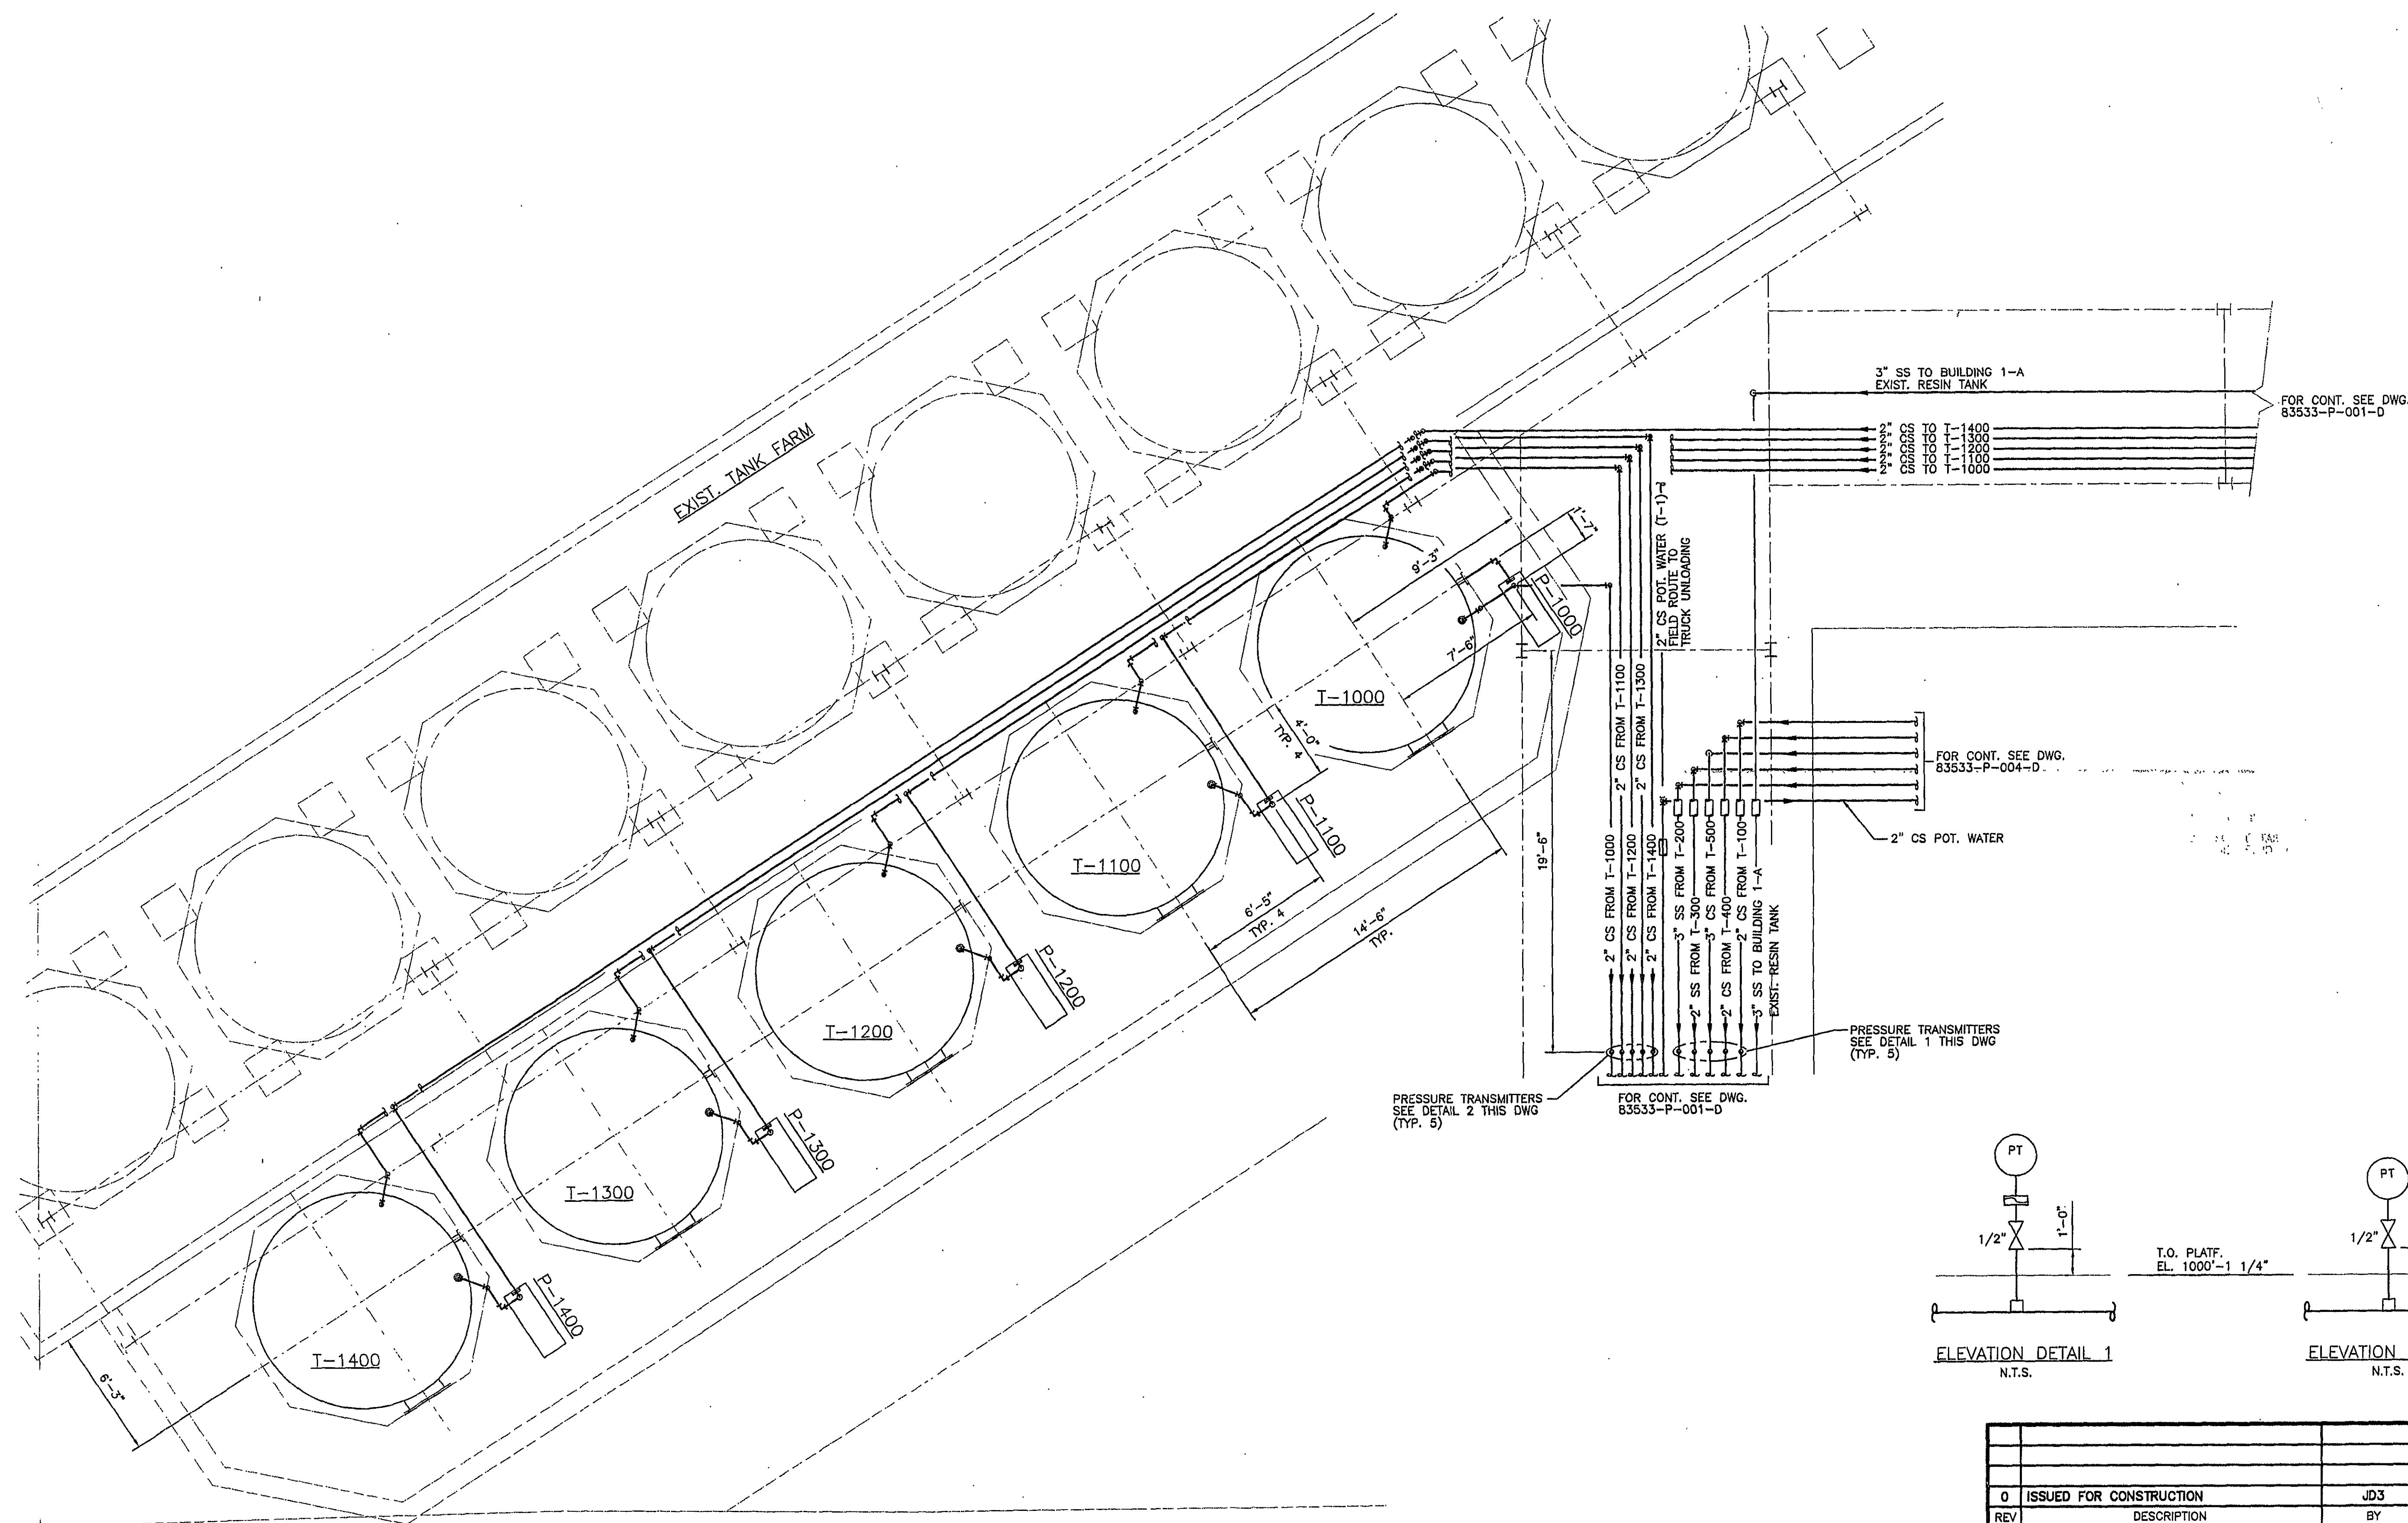

0 ISSUED FOR CONSTRUCTION		JD3	4/16/03	TLM
REV	DESCRIPTION	BY	DATE	APPROVAL
THIS DRAWING IS THE PROPERTY OF PENTA ENG. THE INFORMATION CONTAINED HEREON MAY NOT BE USED OR COPIED IN ANY MANNER WITHOUT THE WRITTEN PERMISSION OF THE OWNER.		PREPARED BY: PENTA ENGINEERING, P.A. 7896 NORTH POINT BLVD. WINSTON-SALEM, NC 27108		
SCALE 1/4\"=1'-0\"		DATE 3/14/03		
DESIGNED BY	JD3	3/18/03		
DRAWN BY	JD3	3/19/03		
CHECKED BY	TLM	3/21/03		
APPROVAL	AKZO NOBEL	3/21/03		
CAD FILE NUMBER	533P005D	PROJECT NO. 83533		
		CLIENT NO. 83533-P-005-D		REV. NO. 0

