


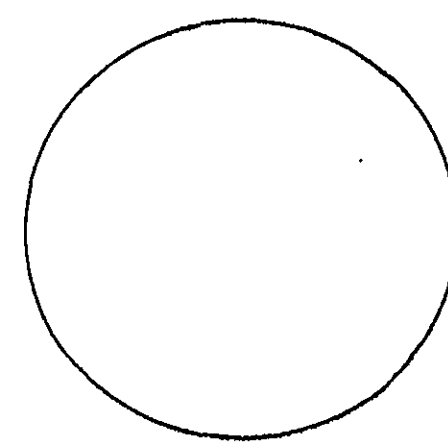

EXIST. TANK FARM

NOTES:

1. ALL ELECTRICAL WORK IN THIS AREA SHALL CONFORM TO NFPA 70 (NEC) CLASS 1, DIVISION 2, GROUP D EXPLOSIVE ATMOSPHERE. PROVIDE SEALS AND EQUIPMENT RATED FOR AREA.
2. ELECTRICAL SIZING FOR ALL PUMPS ARE BASED ON 10 HORSEPOWER. CONTRACTOR TO COORDINATE WITH AKZO NOBEL FOR FINAL HORSEPOWER.

TO POWER PNL "HA"
CKT 20, 22, 24



GATE
OPERATOR

3/4" CONDUIT
3C #12
1C #12 GND.

SEE MATCH LINE ON DRAWING
83533-E-003-D

EXIST. BUILDING

EXIST. BUILDING "8"

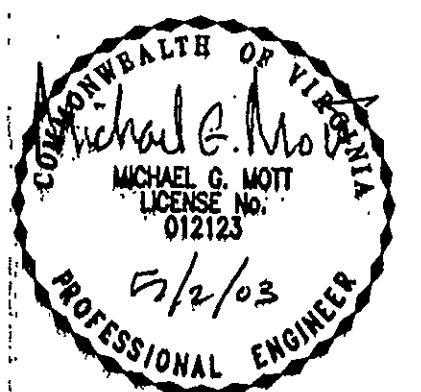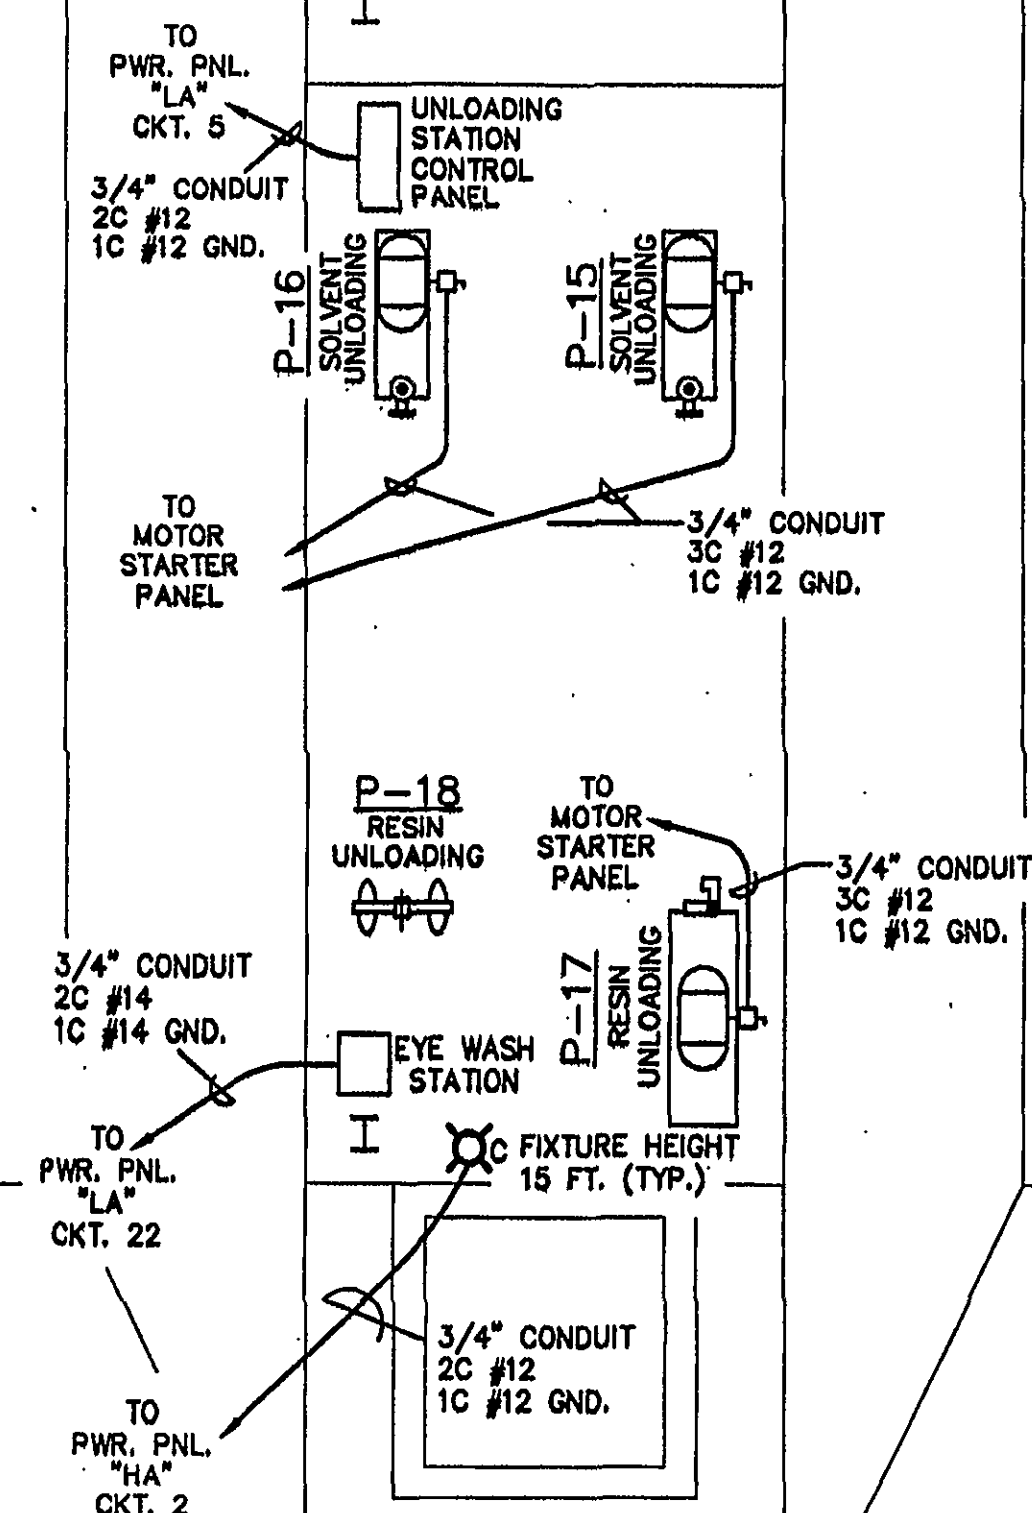

0	ISSUED FOR CONSTRUCTION	DCD	5/01/03		
REV	DESCRIPTION	BY	DATE	APPROVAL	
THIS DRAWING IS THE PROPERTY OF PENTA, INC. THE INFORMATION CONTAINED HEREON MAY NOT BE USED OR COPIED IN ANY MANNER WITHOUT THE WRITTEN PERMISSION OF THE OWNER.		PREPARED BY PENTA	PENTA, Inc. PENTA ENGINEERING, P.A. 7998 NORTH POINT BLVD. WINSTON-SALEM, N.C. 27106 (360)788-7401 (360)788-7402 (Fax)		
SCALE	1/4"=1'-0"	DATE	AKZO NOBEL		
DESIGNED BY	D.C. DOBROWSKI	4/04/03	ROANOKE, VA.		
DRAWN BY	J.D. HELMS	4/04/03	TRUCK UNLOADING		
CHECKED BY	K.G. LEPPERT	4/11/03	POWER & LIGHTING PLAN		
APPROVAL	M.G. MOTT		PROJECT NO.	DRAWING NO.	REV. NO.
APPROVAL			83533		
CAD FILE NUMBER	533E003D.dwg	CLIENT NO.	83533-E-003-E		
			0		