



NOTES:

1. SEE DRAWING 83533-E-000-D FOR GROUNDING NOTES.

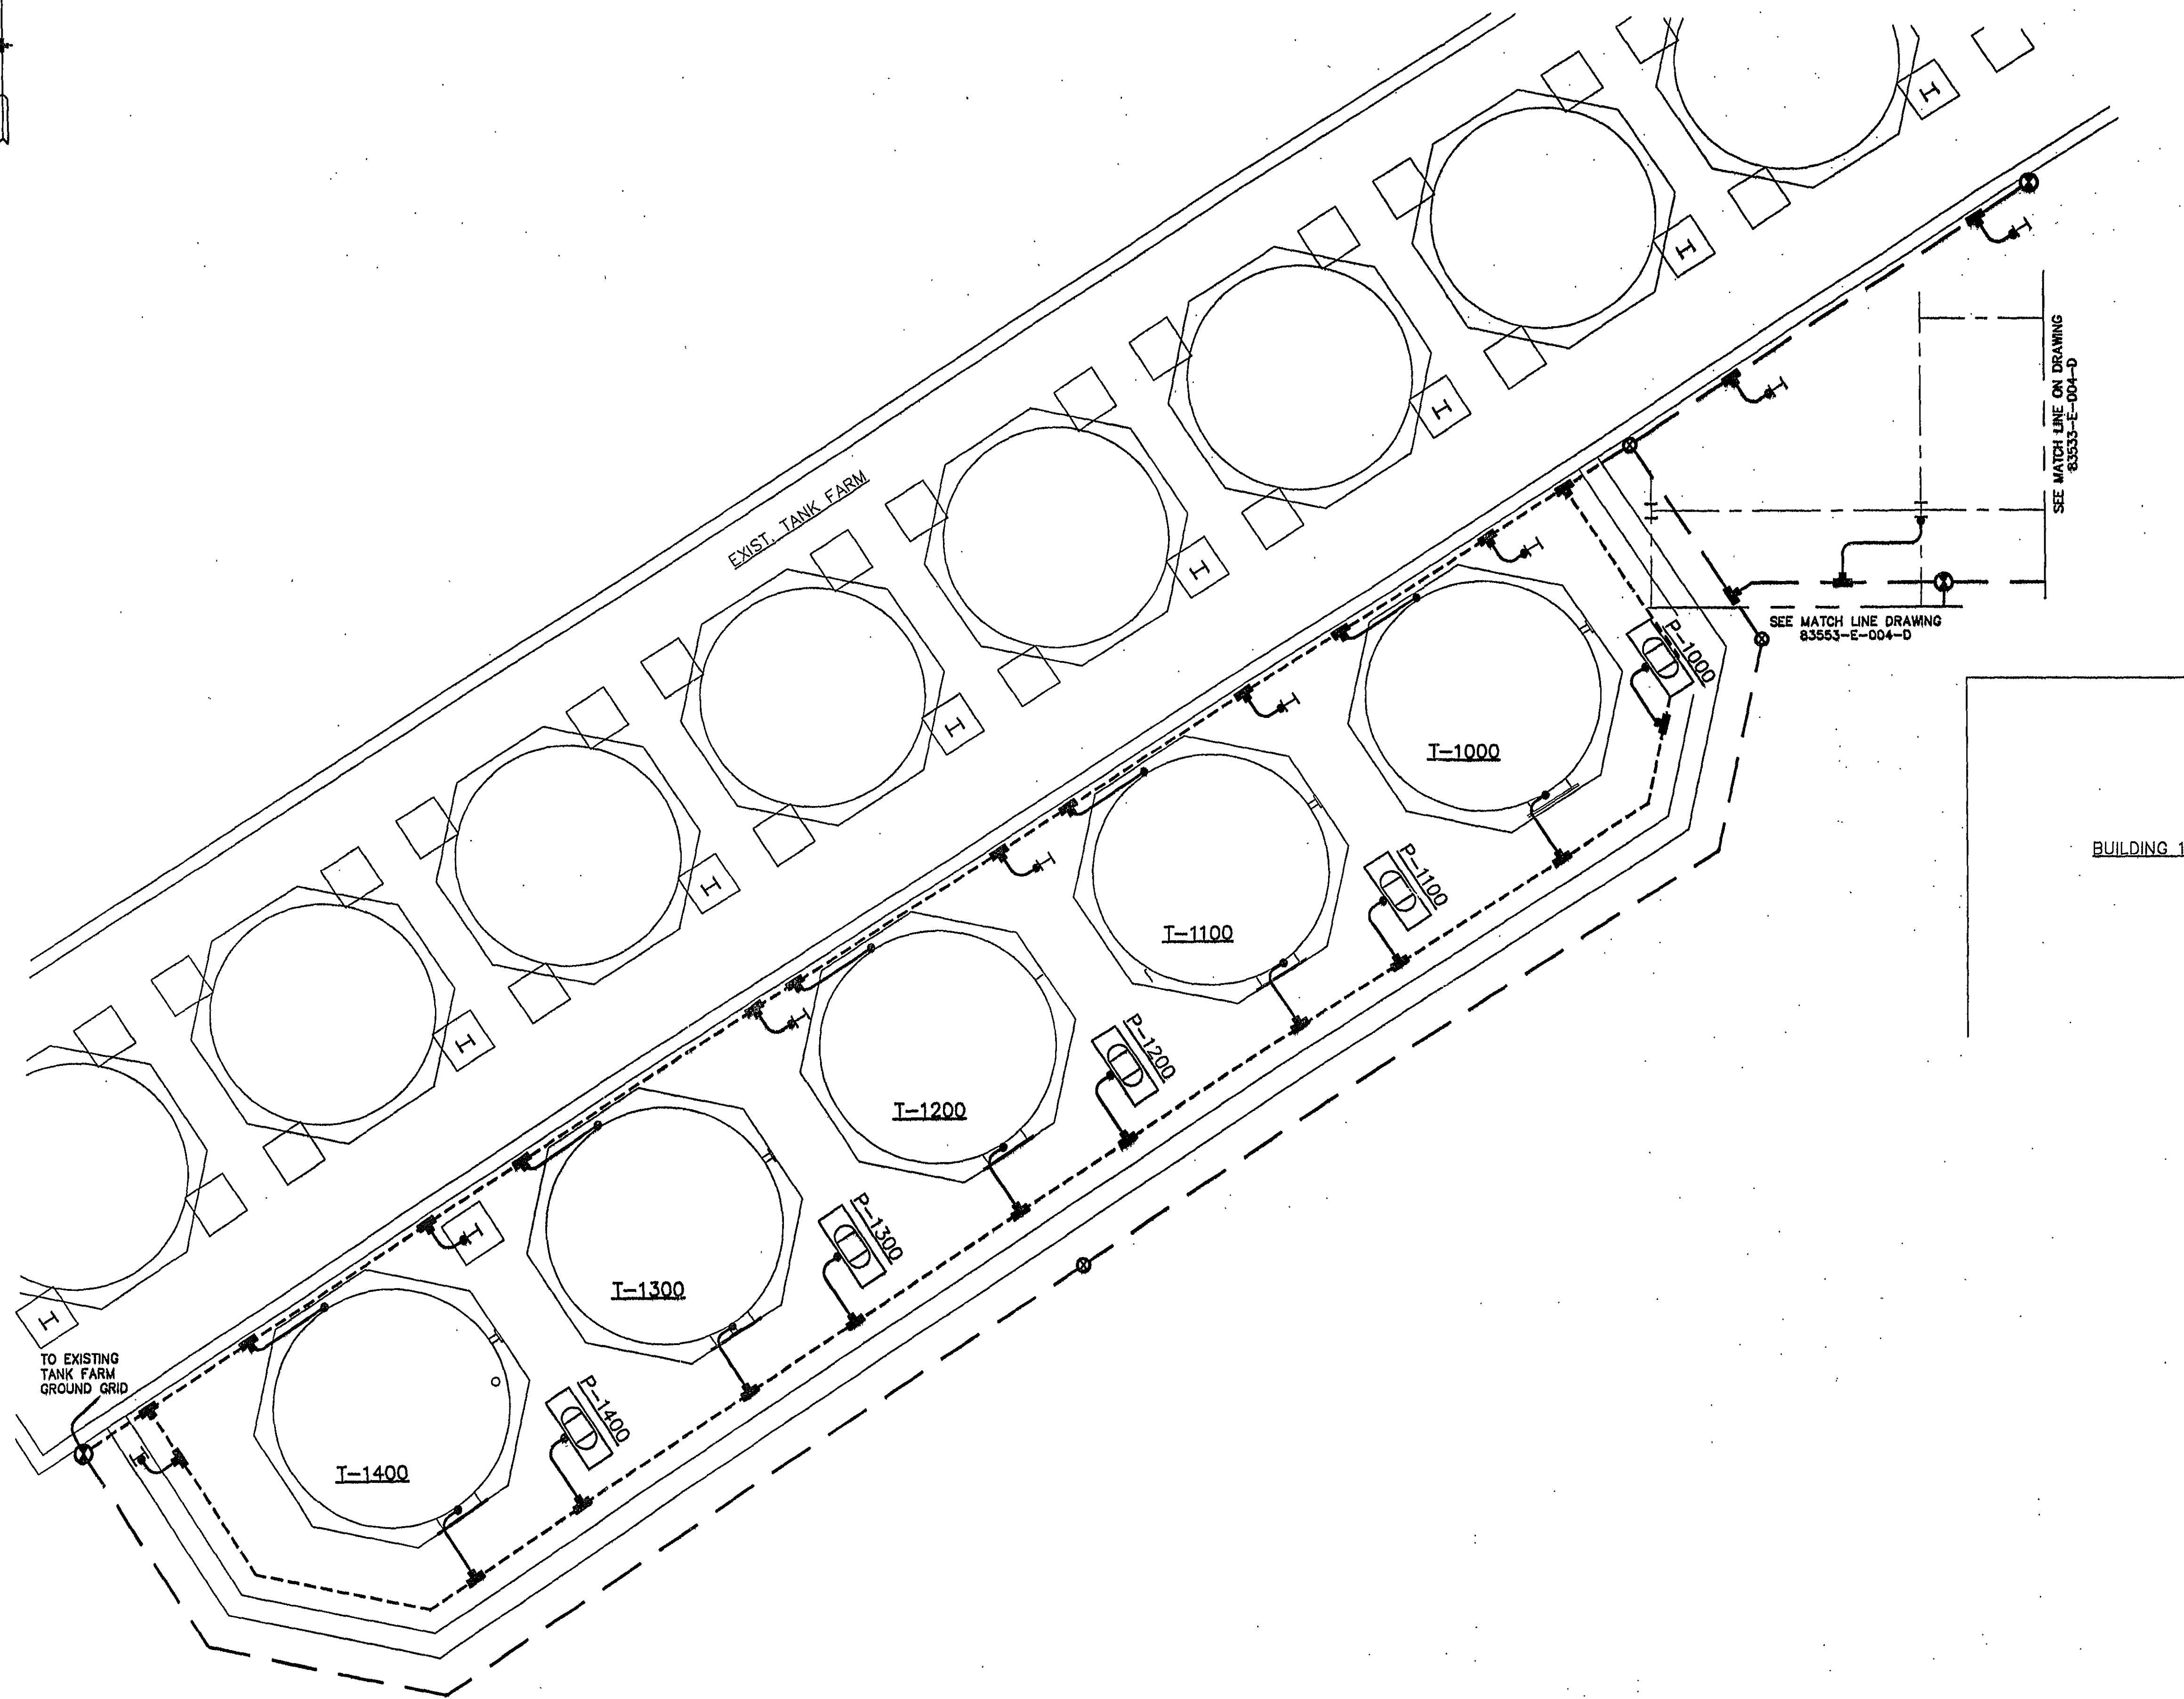

BUILDING 10

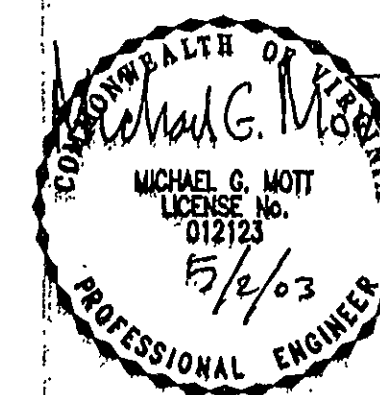

O ISSUED FOR CONSTRUCTION		DCD	5/01/03
REV	DESCRIPTION	BY	DATE
THIS DRAWING IS THE PROPERTY OF PENTA, INC. THE INFORMATION CONTAINED HEREON MAY NOT BE USED OR COPIED IN ANY MANNER WITHOUT THE WRITTEN PERMISSION OF THE OWNER. SCALE 1/4"=1'-0" DATE 4/04/03 DESIGNED BY D.C. DOBROWSKI 4/04/03 DRAWN BY J.D. HELMS 4/04/03 CHECKED BY K.G. LEPPERT 4/11/03 APPROVAL M.G. MOTT CAD FILE NUMBER 533E008D.dwg			
PREPARED BY PENTA, Inc. PENTA ENGINEERING, P.A. 7680 NORTH PORT BLVD. WINSTON-SALEM, N.C. 27106 (360)769-7401 (360)769-7402 (Fax) AKZO NOBEL ROANOKE, VA. TANK FARM GROUNDING PLAN		PROJECT NO. 83533	REV. NO. 0
CLIENT NO. 83533-E-006-D		DRAWING NO.	