


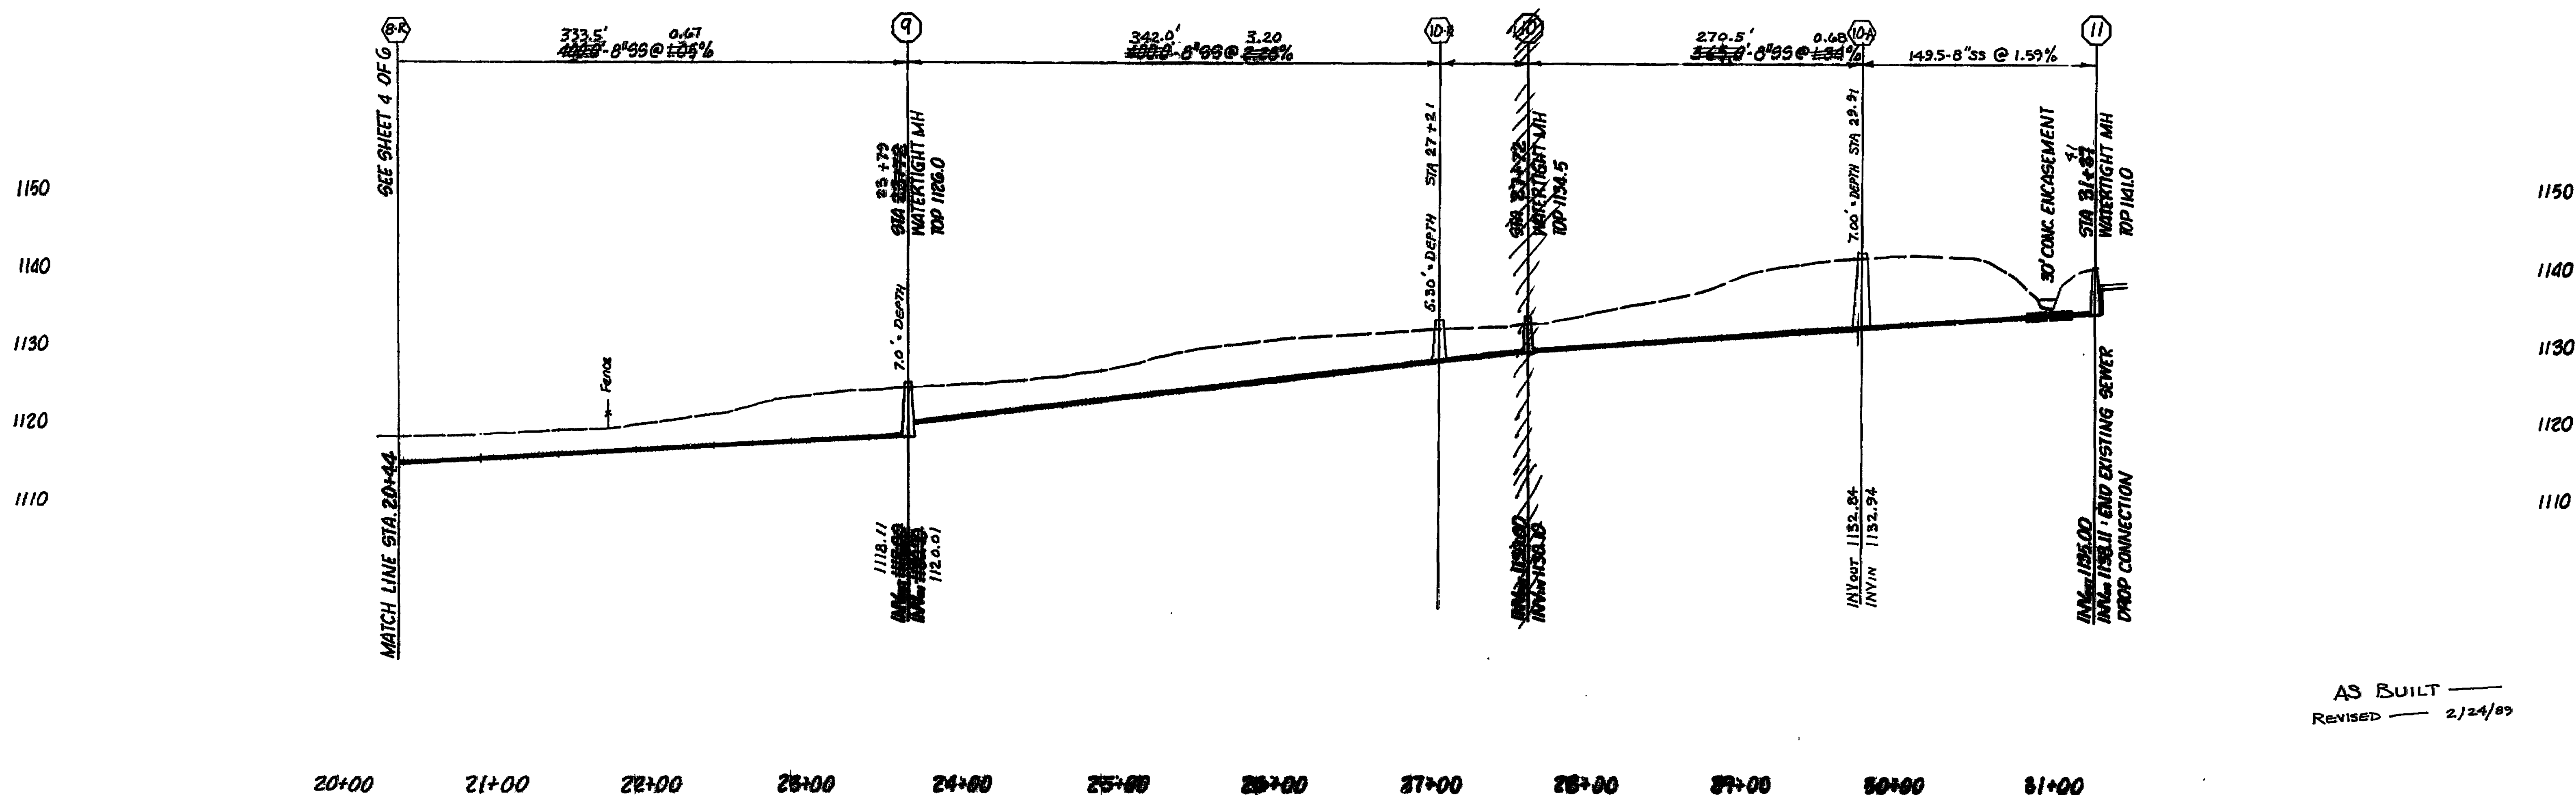

AS BUILT —
REVISED — 2/24/89



CLEAN WATER ENGINEERS, INC.

**P. O. BOX 218
FINCASTLE, VIRGINIA 24090**

ROUTE 1, BOX 78
HARRISONBURG, VIRGINIA 22801

APPALACHIAN POWER COMPANY
OFFICE / SERVICE COMPLEX
GRAVITY SEWER

REVISIONS			DESIGNED: WGP	SHEET: 5 OF 6
NO.	DATE	BY	DESIGN: LHJ / MAC	SCALE: 1/8" = 1'-0"
	6-11-88		CHECKED: WGP	DATE: JUNE 8, 1988
			APPROVED: DHR	TITLE: FLOOR PLAN

