



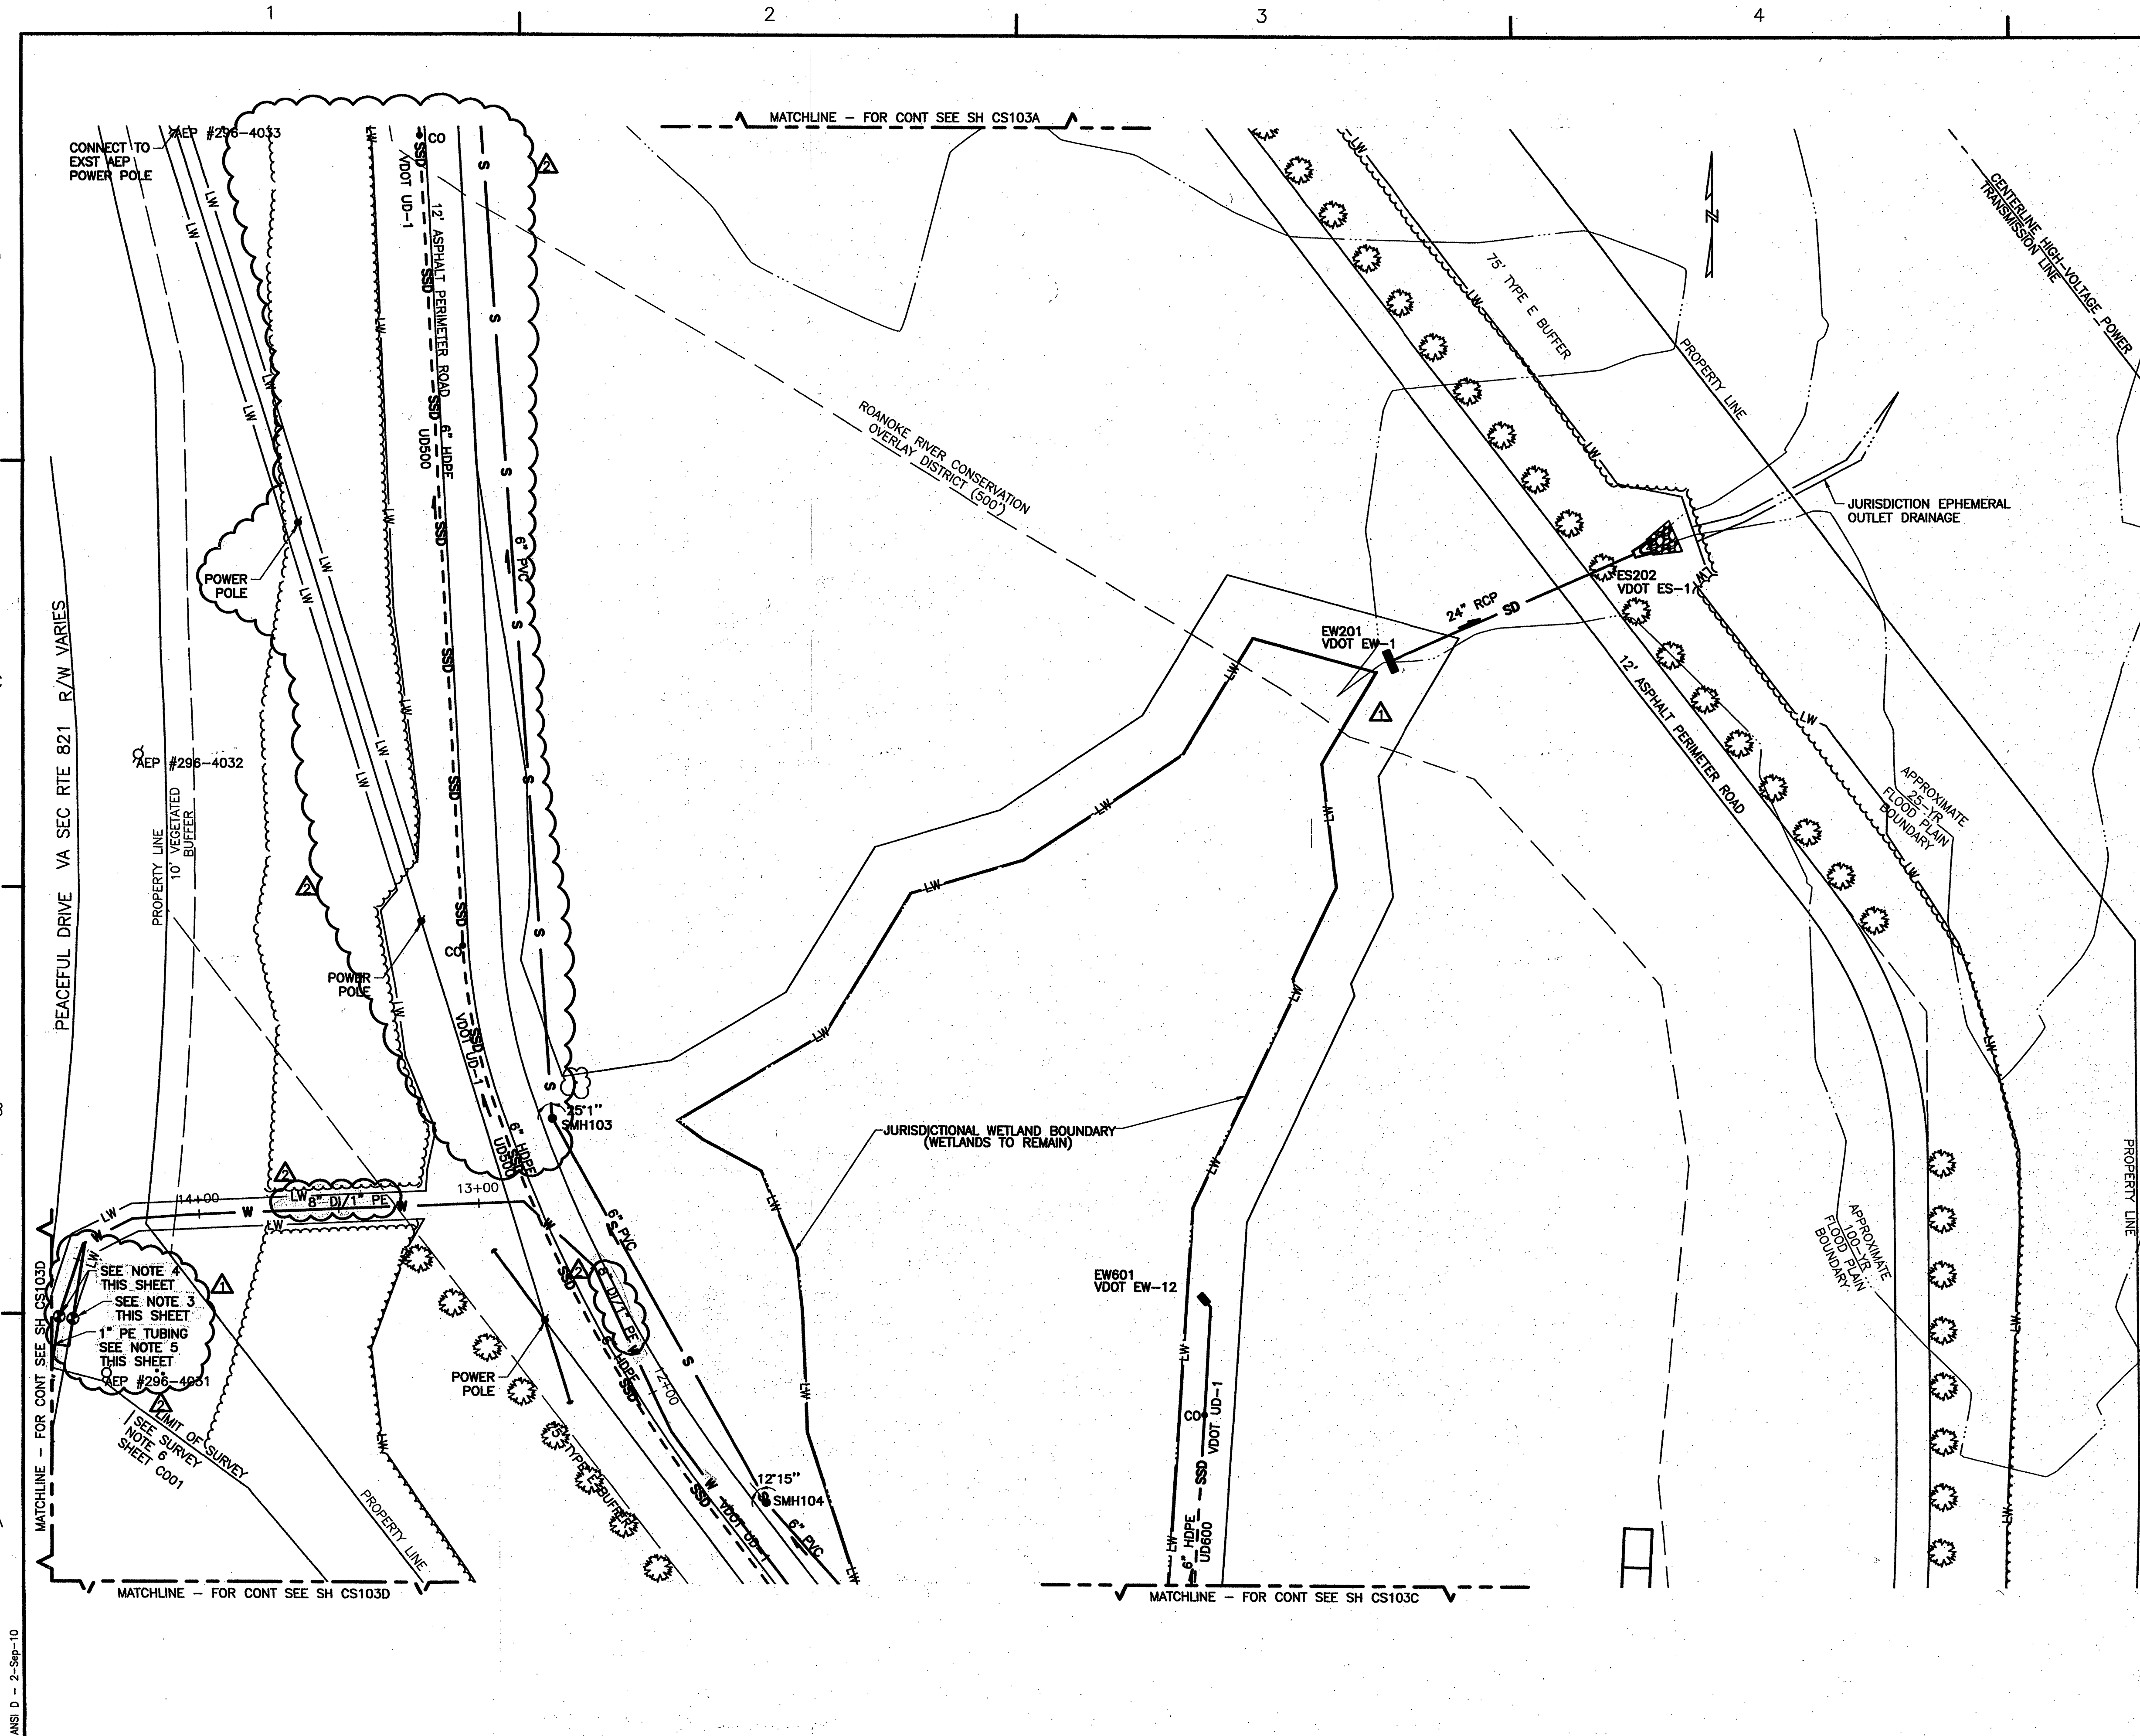

- NOTES THIS SHEET:**
1. SEE SHEET C001 FOR SITE NOTES.
 2. SEE SHEET C002 FOR SITE LEGEND.
 3. PROVIDE TYPE "C" SINGLE RESIDENTIAL SERVICE METER. SEE DETAIL SHEET CS501.
 4. PROVIDE FIRE SERVICE VAULT FOR PRIVATE HYDRANT CHECK VALVE. SEE DETAIL SHEET CS501.
 5. PROVIDE 1" TAPPING SLEEVE AND VALVE. CONNECT 1" PE TUBING INTO 8" DI LINE. 8" LINE AND 1" TUBING SHALL RUN PARALLEL AND BE PLACED IN SAME TRENCH.

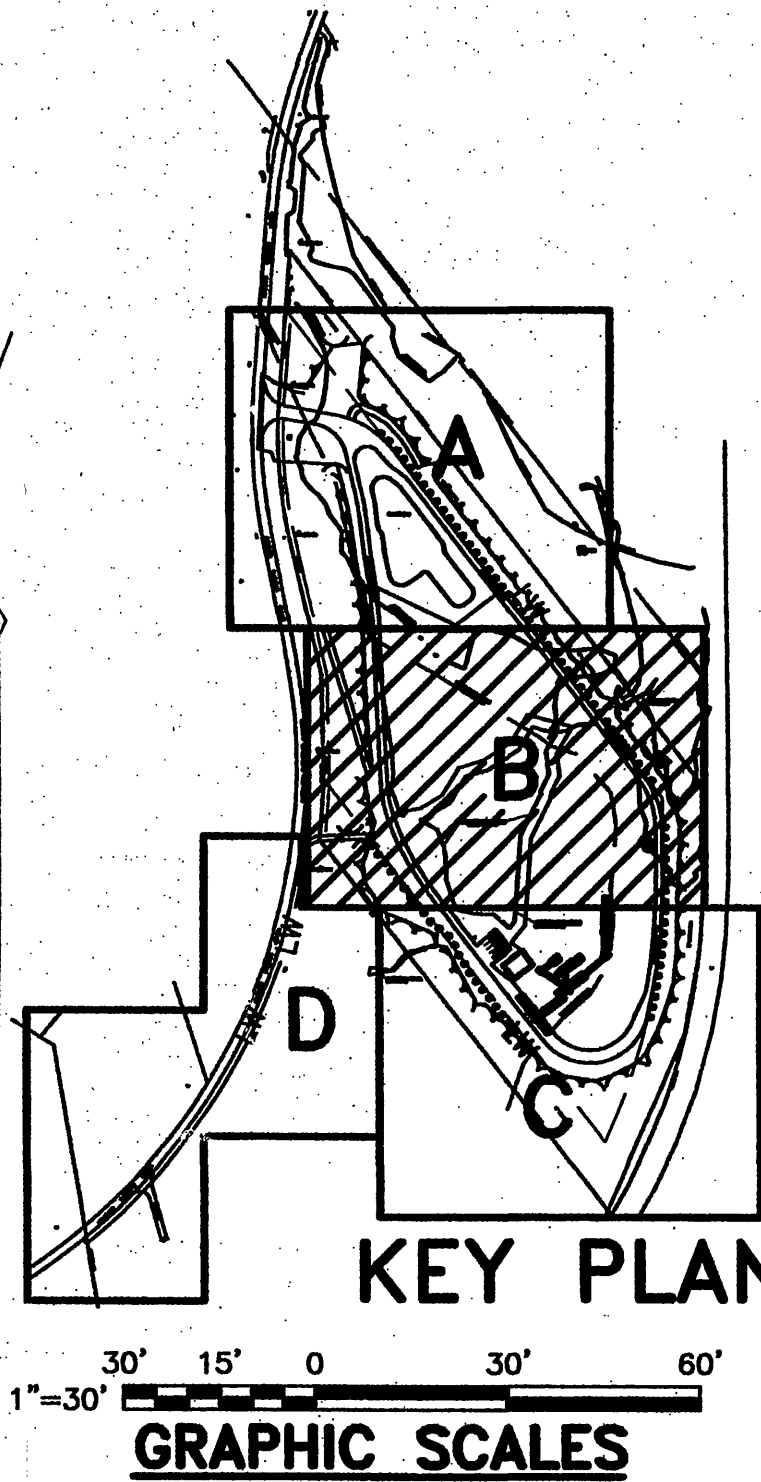

PROJECT NO: 60091000	
CAD DWG FILE: LL\CS_103B	
DESIGNED BY: NTG	
DRAWN BY: NTG	
DEPT CHECK: EPB	
PROJ CHECK: JSH	
DATE: APRIL 27, 2010	
SCALE: 1"=30'	
CS103B	
SHEET 21 OF 51	

REVISIONS	
DATE	DESCRIPTION
9/2/10	MLC PERMETER ROAD REALIGNMENT/WWA COMMENTS
4/27/10	MLC PER ROANOKE COUNTY COMMENTS
MADE BY	CHECKED

AECOM
ASBESTOS HAZARDOUS WASTE
ROANOKE, VA 24010
PHONE (540) 857-3100

COMMONWEALTH OF VIRGINIA
Conley Taylor
CONLEY A. TAYLOR
Lic. No. 21318
09/03/10
PROFESSIONAL ENGINEER

FOXHALL PROPERTIES LLC
ADAMS CONSTRUCTION ASPHALT PLANT
**UTILITY PLAN
AREA B**

Adams Asphalt Asbuilt