



PATH/FILENAME: M:\PROJECTS\30000SERIES\30283\000\DWG\LLCS_103C.DWG
LAST UPDATE: Thursday, September 02, 2010 10:28:45 AM
PLOT DATE: Thursday, September 02, 2010 10:28:16 AM
ANSI D - 2-Sep-10

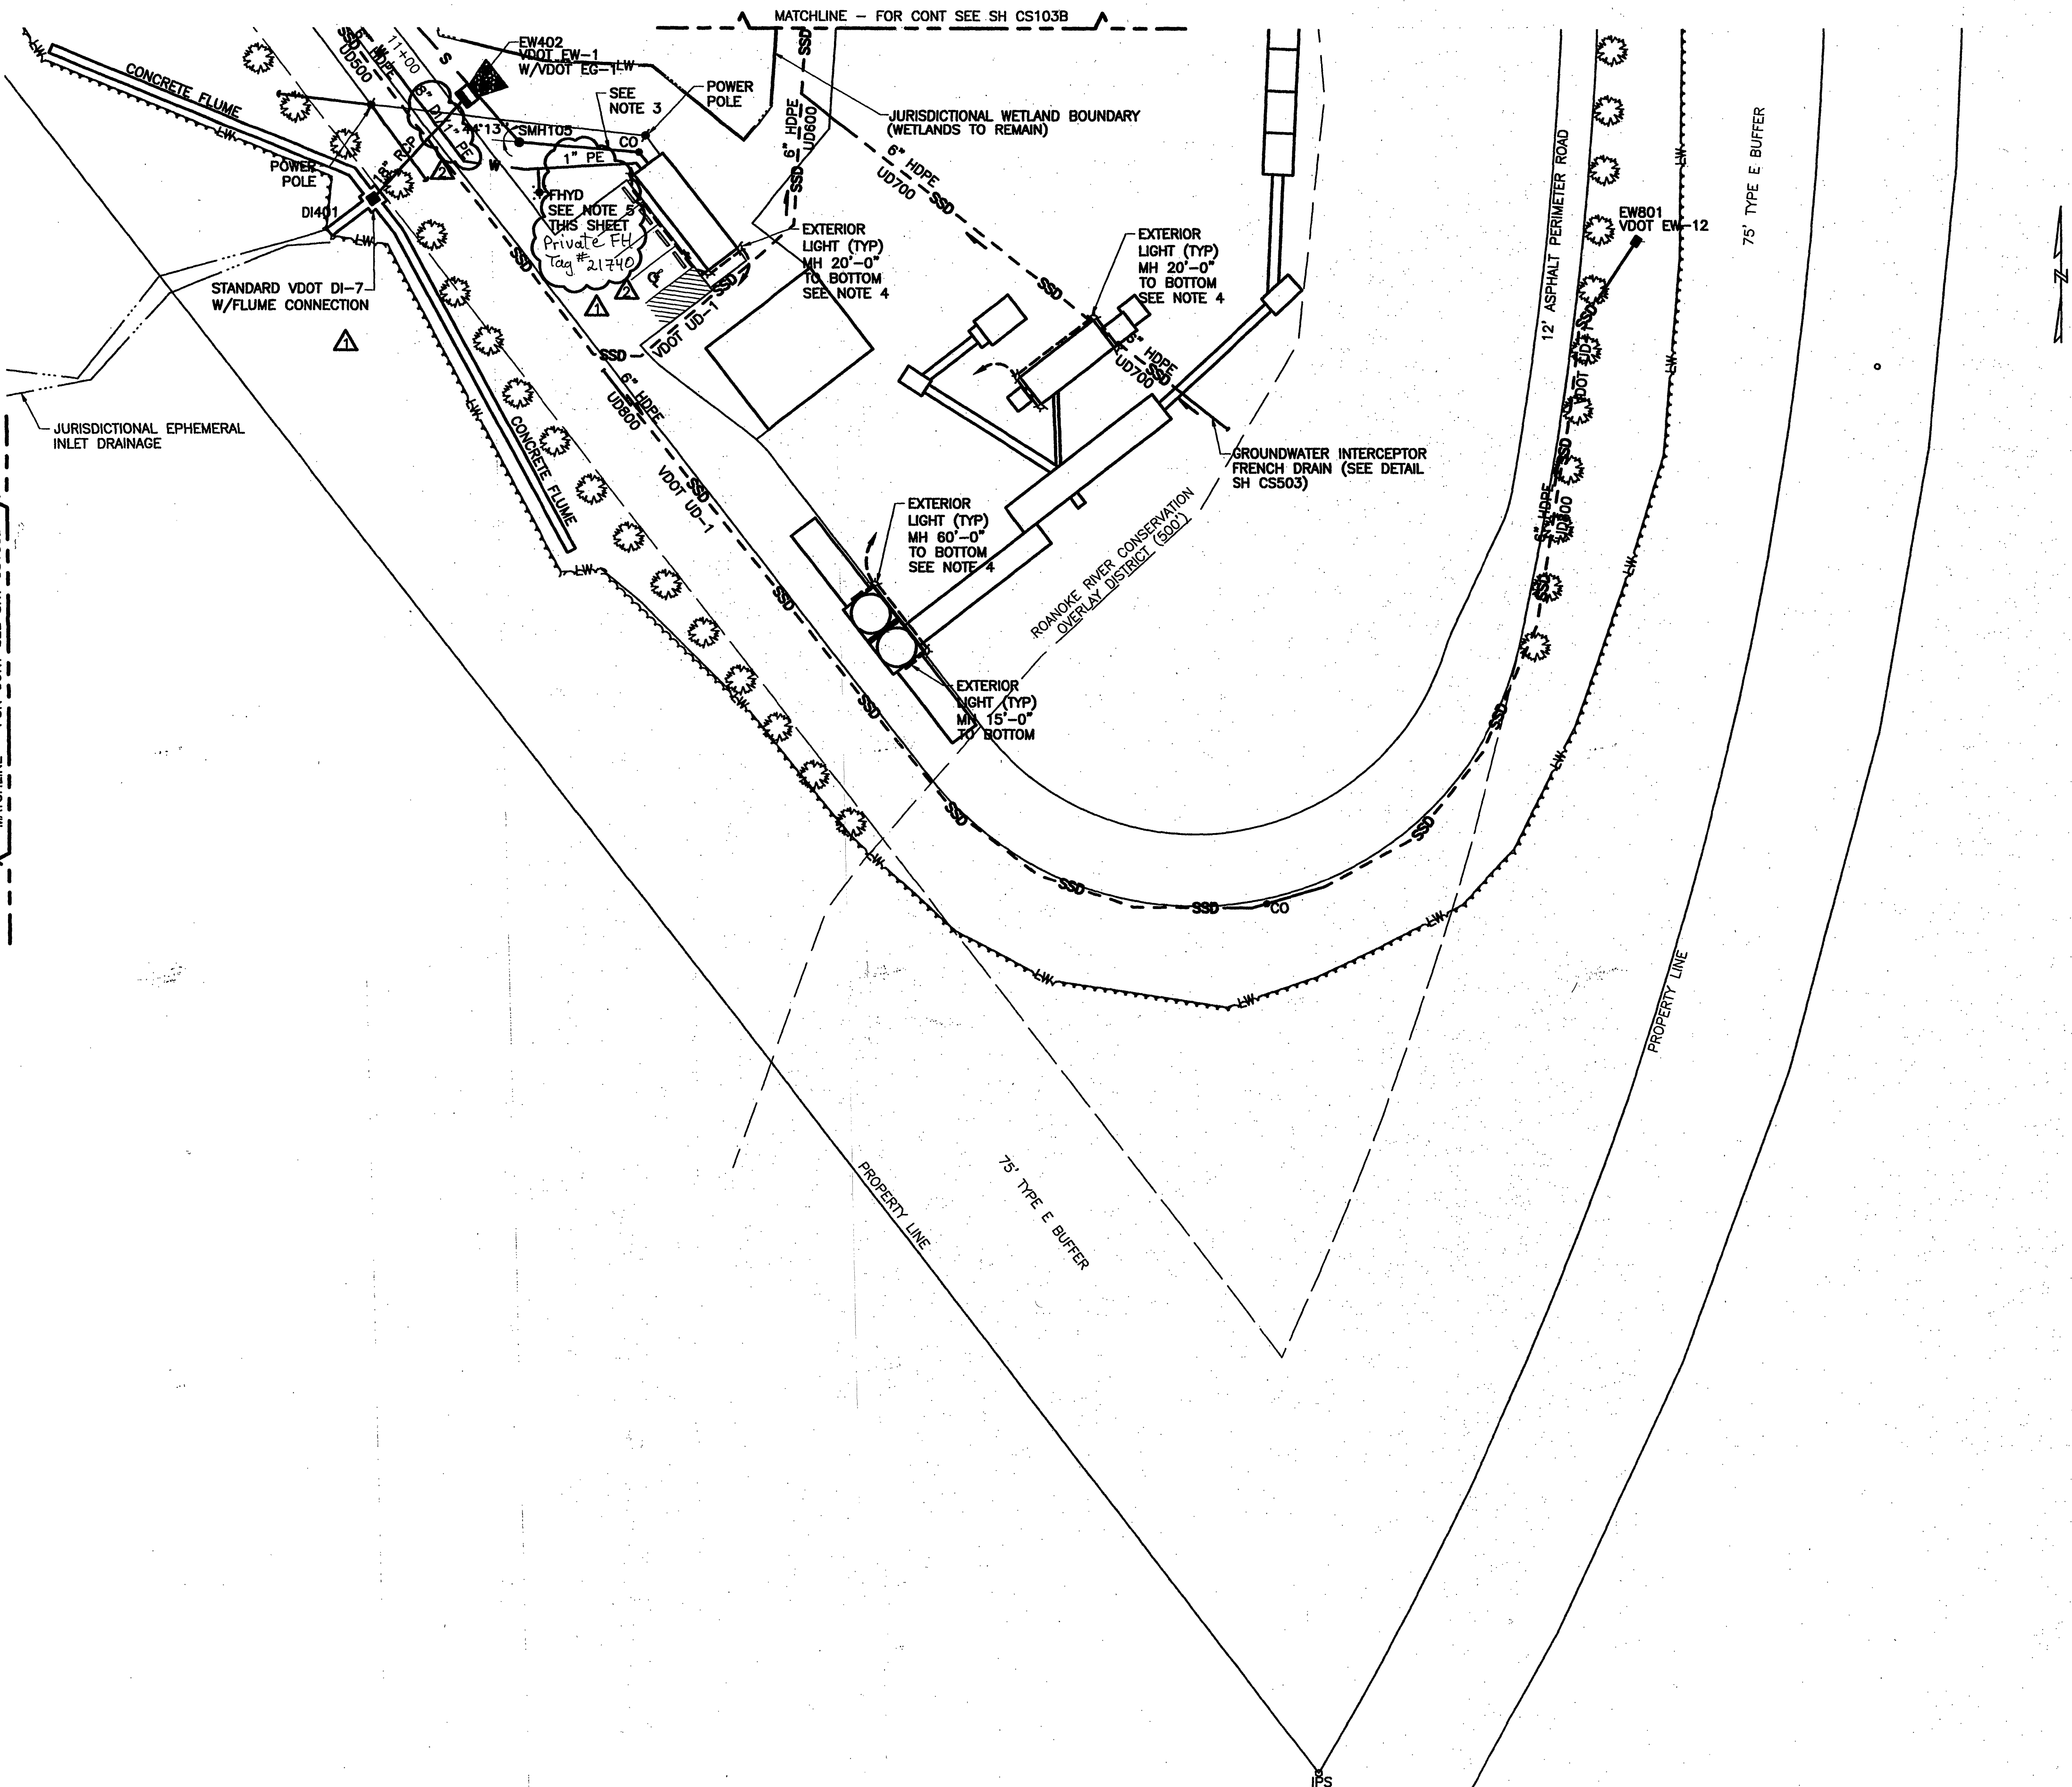

- NOTES THIS SHEET:**
1. SEE SHEET C001 FOR SITE NOTES.
 2. SEE SHEET C002 FOR SITE LEGEND.
 3. SANITARY SEWER LINE FROM SMH105 TO CONTROL BUILDING SHALL BE CONSTRUCTED OF WATER PIPE MATERIAL IN ACCORDANCE WITH AWWA SPECIFICATIONS AND PRESSURE TESTED IN PLACE WITHOUT LEAKAGE PRIOR TO BACKFILLING. THE HYDROSTATIC TEST SHALL BE CONDUCTED IN ACCORDANCE WITH AWWA C600-82 WITH A MINIMUM TEST PRESSURE OF 30 PSI.
 4. PROVIDE 2-#12 AWG AND 1-#12 AWG GND IN 3/4" CONDUIT TO SPARE 20-AMP, 1-POLE BREAKER IN PANEL IN CONTROL BUILDING. PROVIDE PHOTOCELL FOR OPERATION OF LIGHT FIXTURES.
 5. TERMINATE 8" DI WATER LINE AT FIRE HYDRANT. 1" PE TUBING SHALL TIE INTO BUILDING.

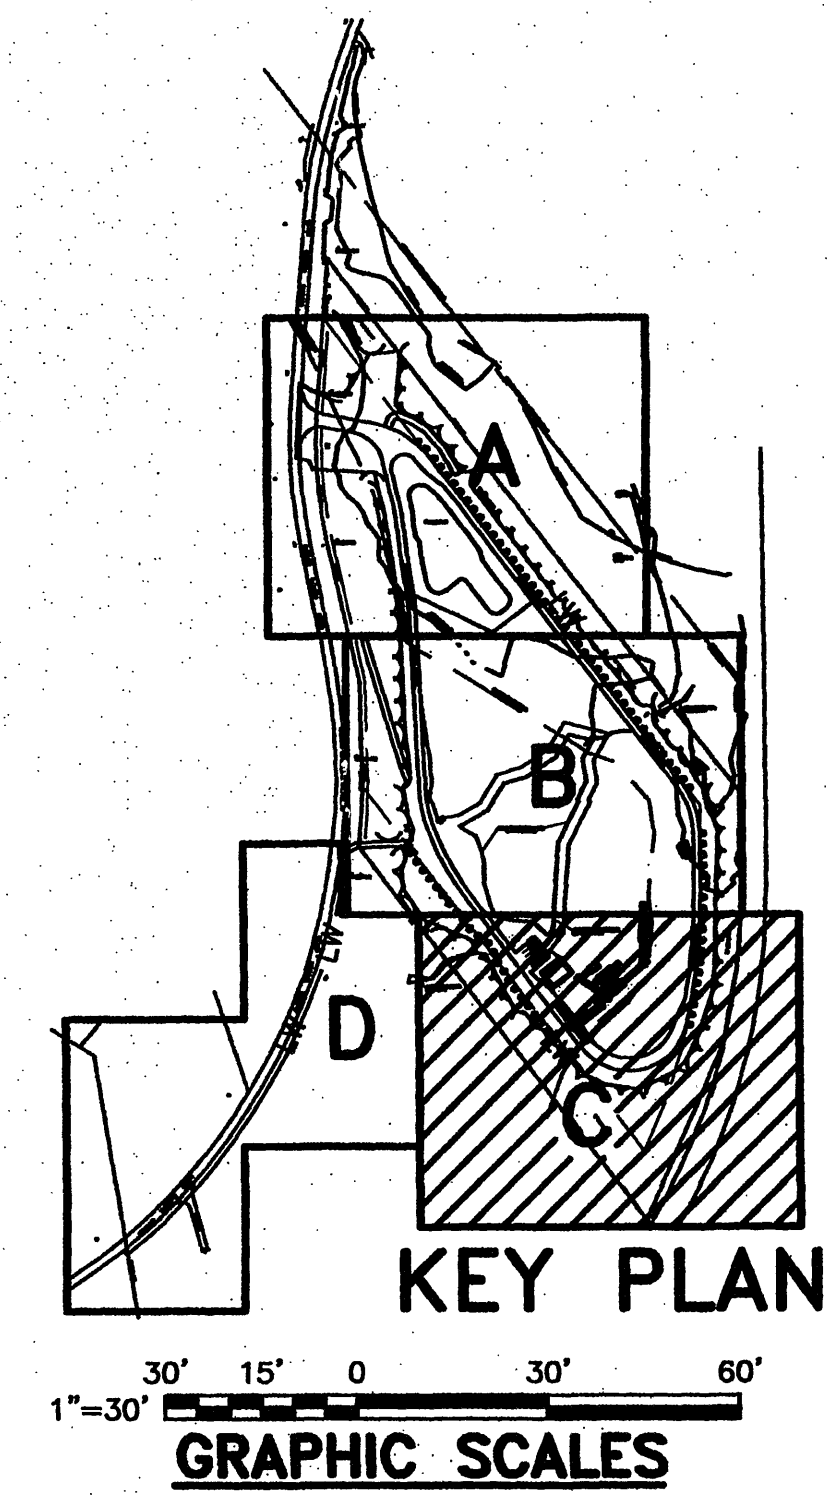

REVISIONS	
DATE	DESCRIPTION
9/2/10	MLC
4/27/10	MLC
9/2/10	NTG
4/27/10	NTG
9/2/10	MLC
4/27/10	MLC
9/2/10	MLC
4/27/10	MLC
9/2/10	MLC
4/27/10	MLC

AECOM

COMMONWEALTH OF VIRGINIA
CONLEYA. TAYLOR
Lic. No. 21918
09/03/10
PROFESSIONAL ENGINEER

FOXHALL PROPERTIES LLC
ADAMS CONSTRUCTION ASPHALT PLANT

**UTILITY PLAN
AREA C**

PROJECT NO: 60091000
CAD DWG FILE: LLCS_103C
DESIGNED BY: NTG
DRAWN BY: NTG
DEPT CHECK: MLC
PROJ CHECK: CAT
DATE: APRIL 27, 2010
SCALE: 1"=30'
CS103C
SHEET 22 OF 51

As-Built 1.20.11 K. Winslow