

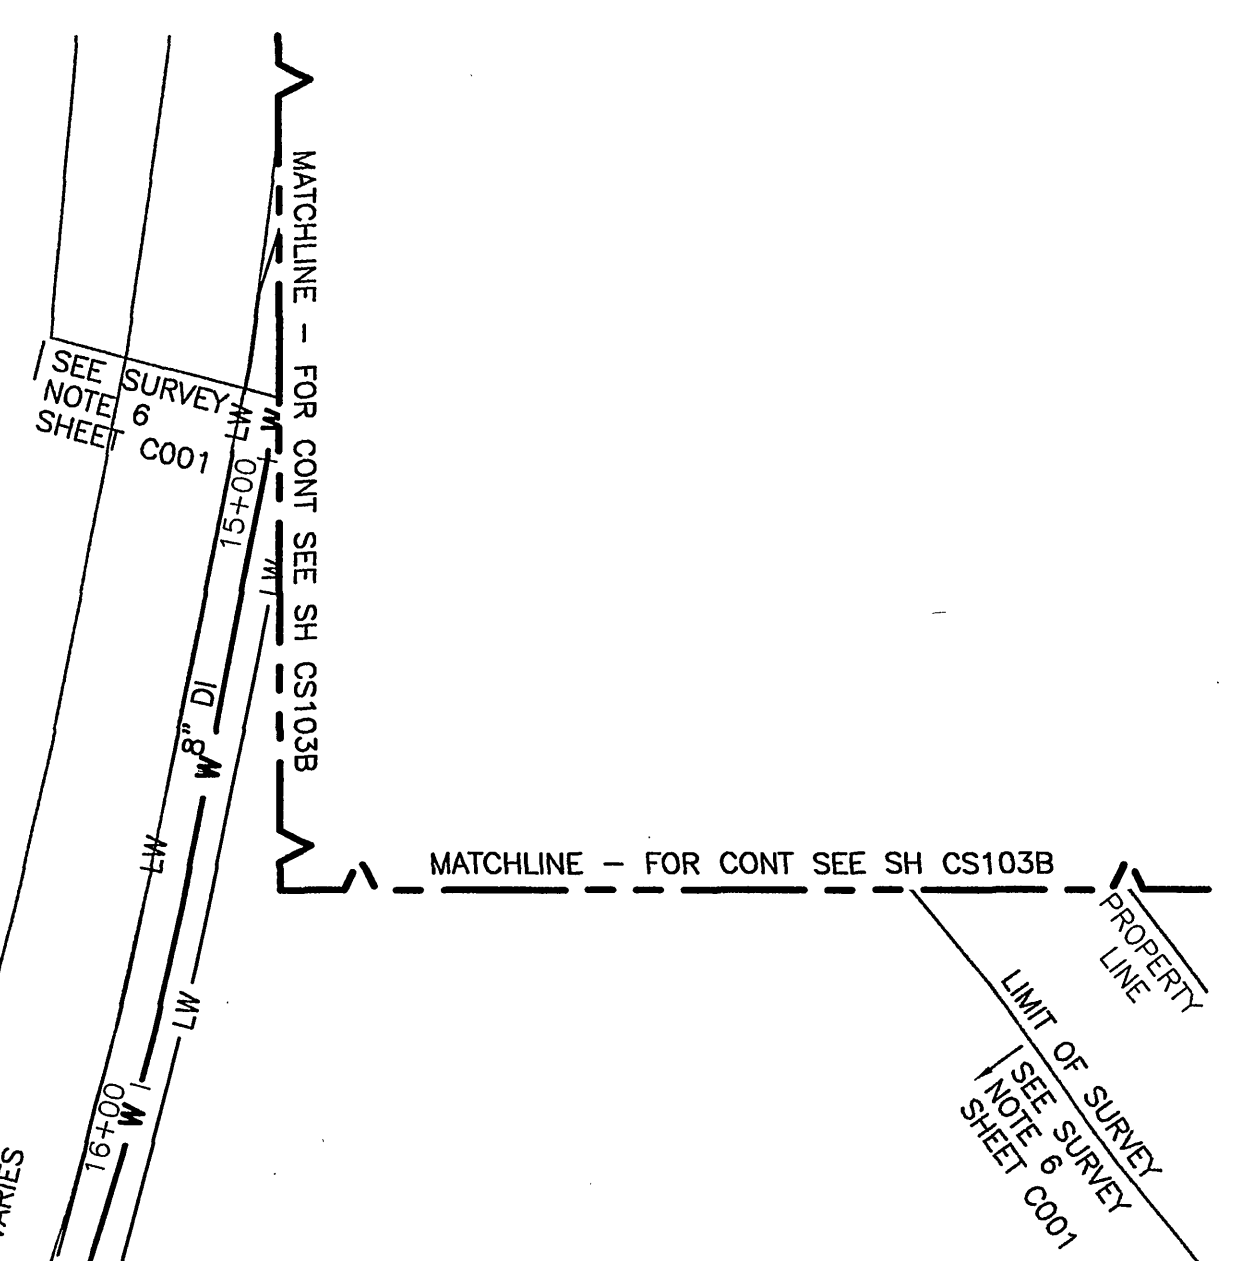
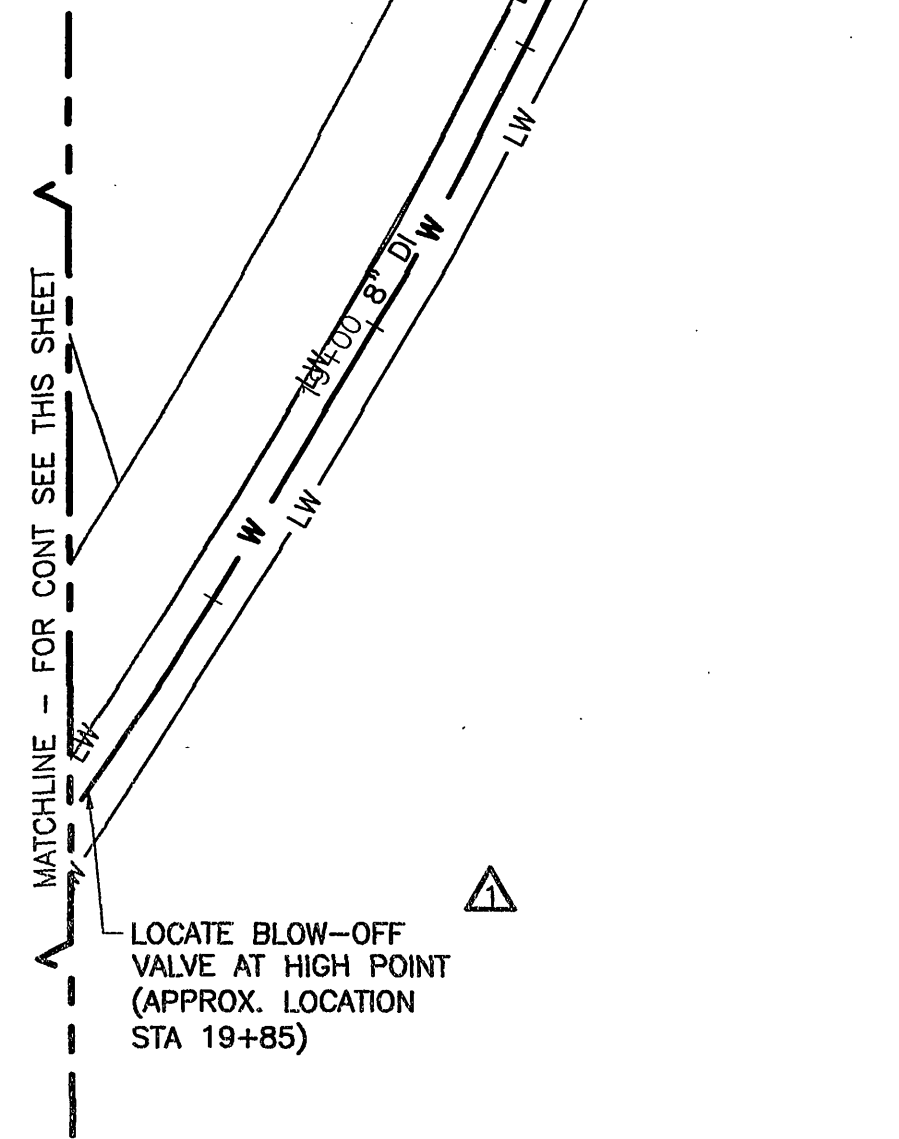
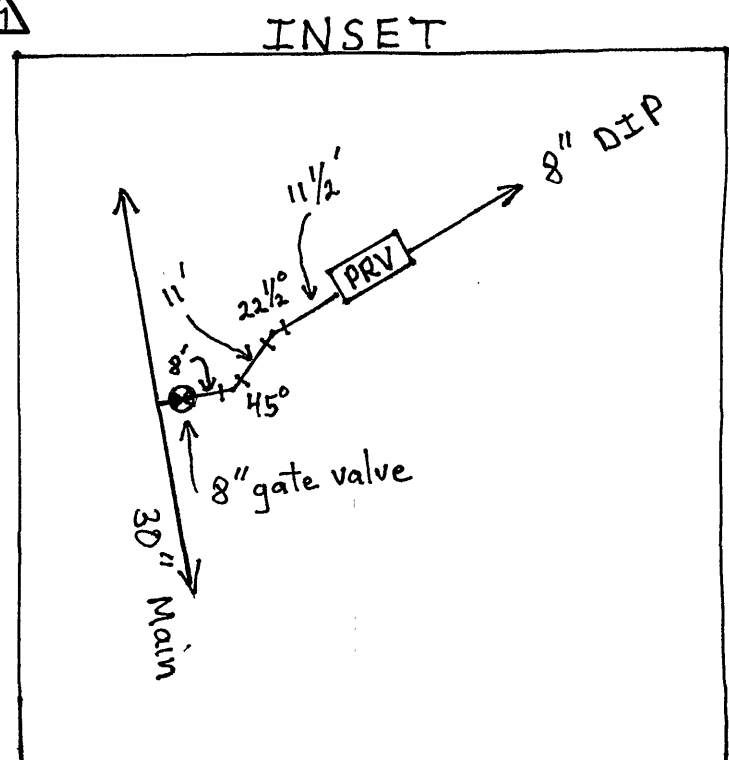


PAH/FILENAME: M:\PROJECTS\3000SERIES\30263\CADD\DWG\UTCS_1030.DWG
LAST UPDATE: Monday, April 26, 2010 3:59:03 PM
ANSI D - 26-Apr-10

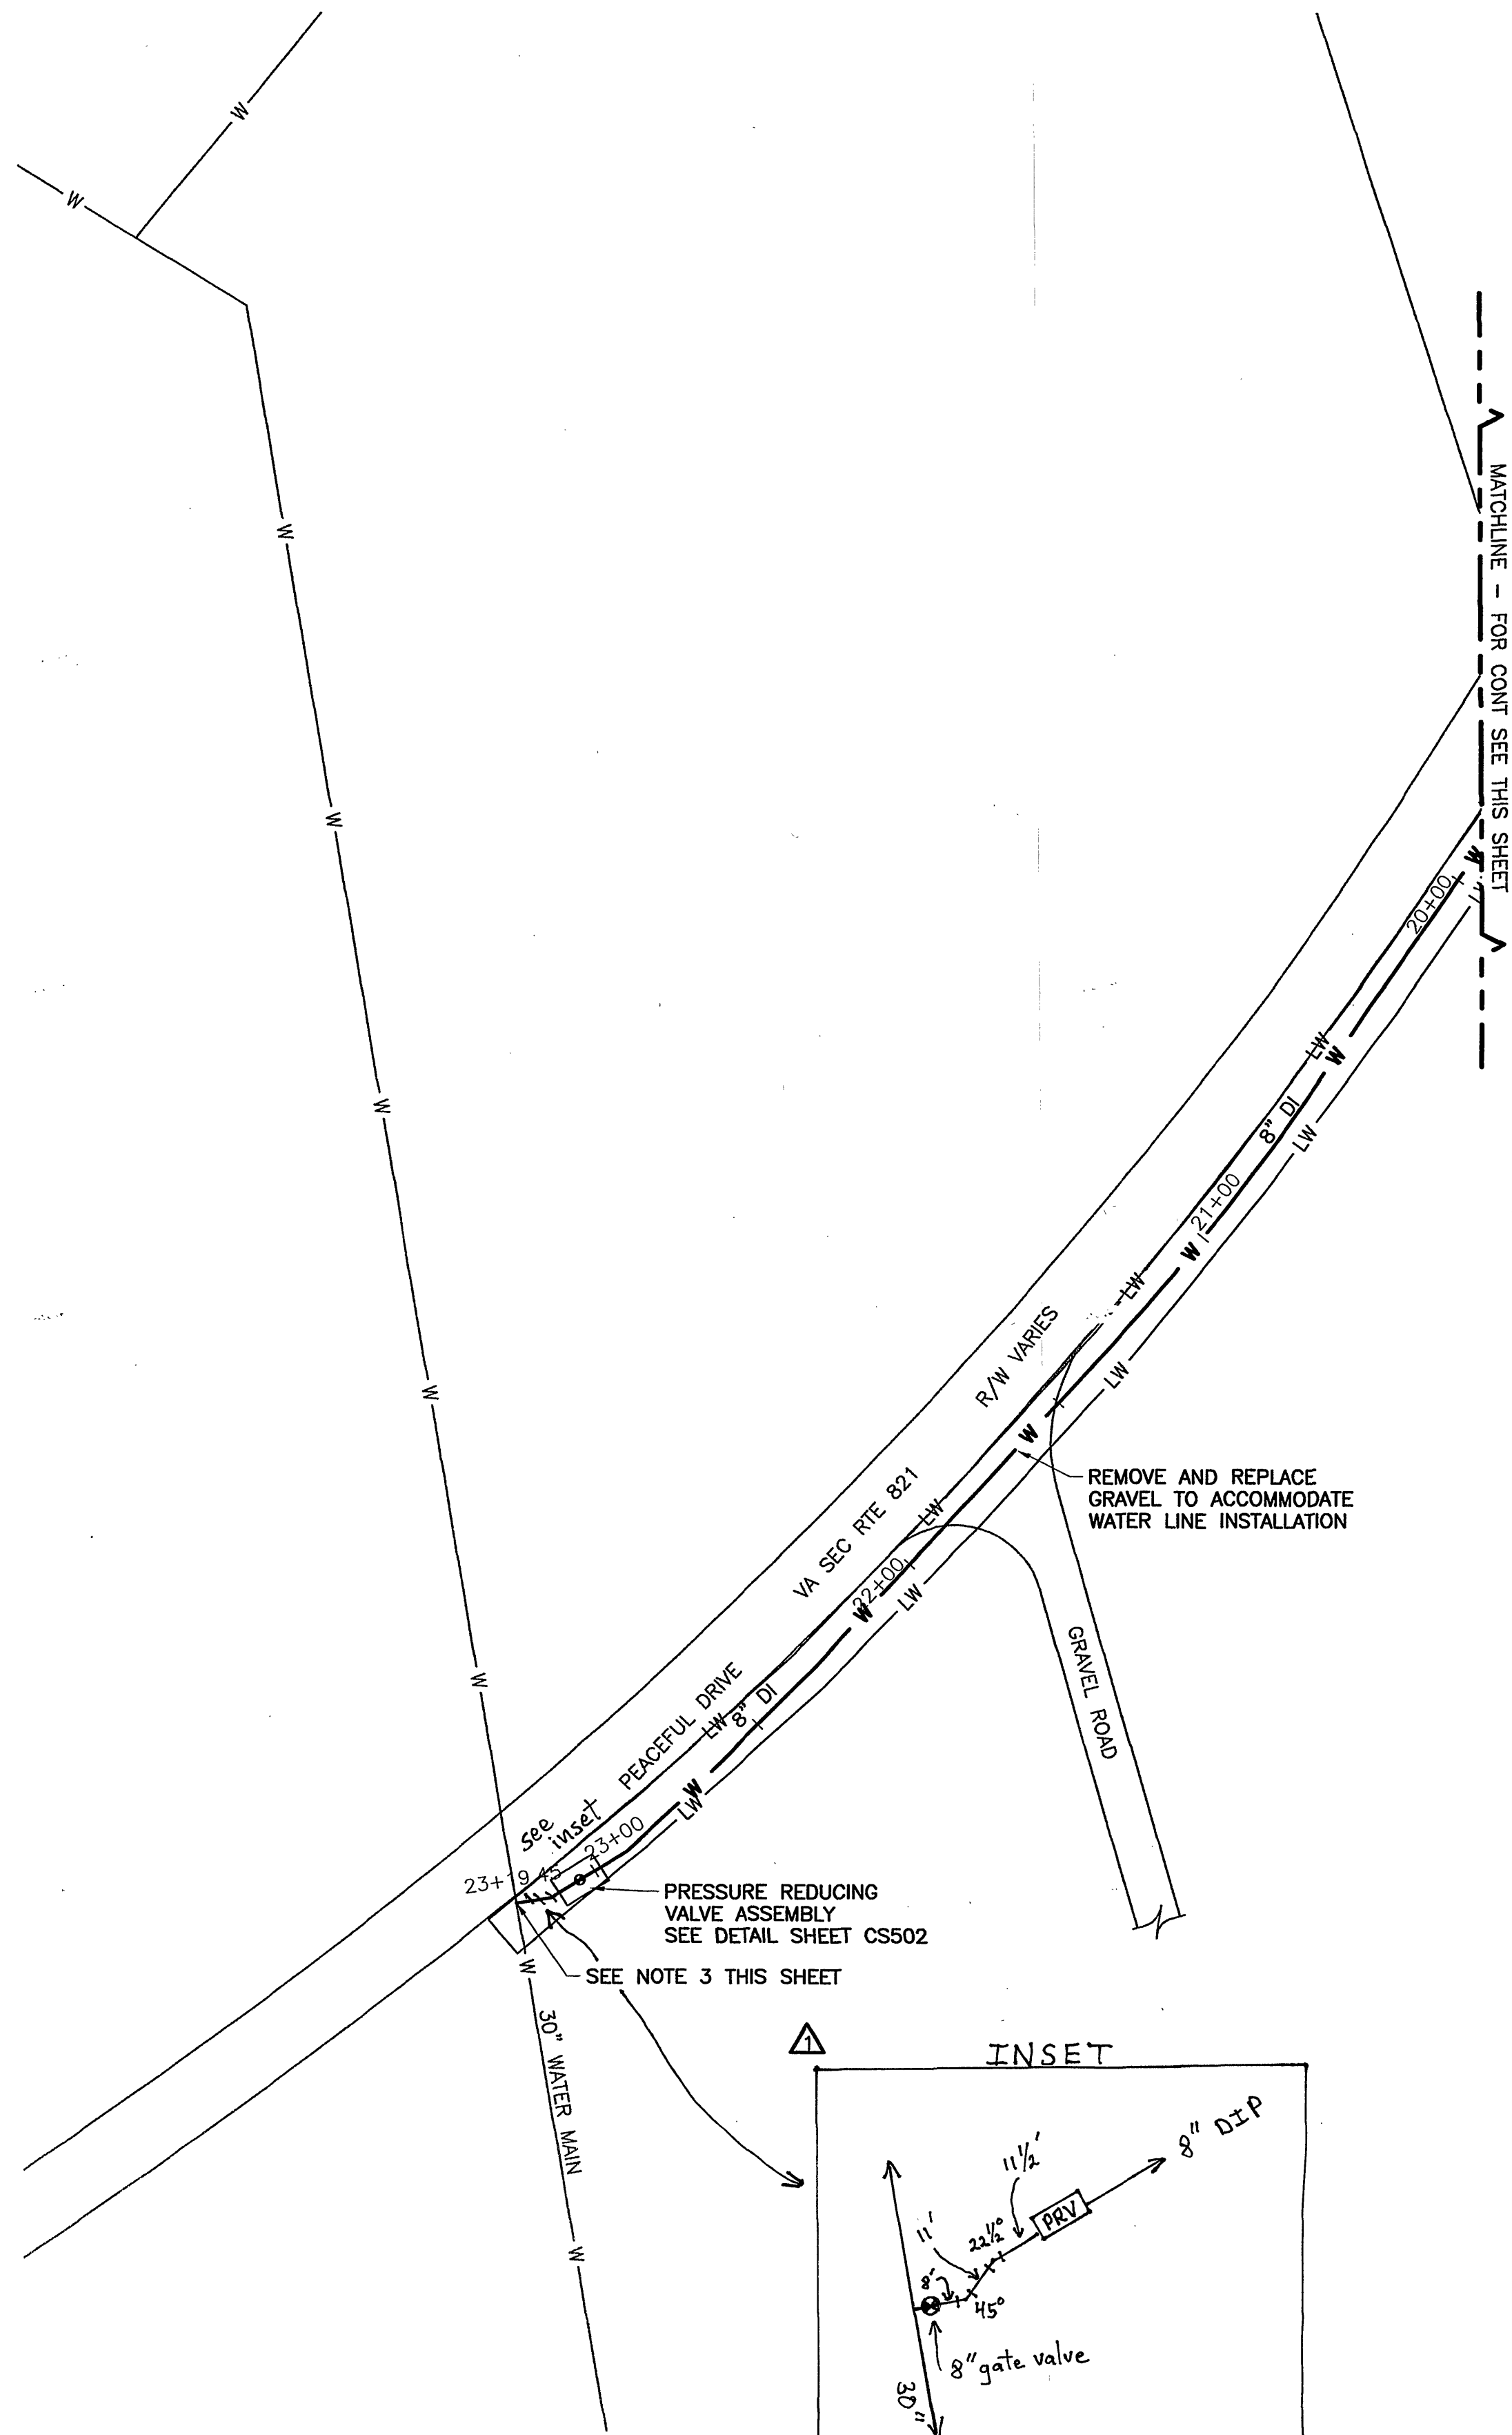

- NOTES THIS SHEET:**
1. SEE SHEET C001 FOR SITE NOTES.
 2. SEE SHEET C002 FOR SITE LEGEND.
 3. WESTERN VIRGINIA WATER AUTHORITY TO PERFORM TAP TO EXIST 30" WATER MAIN AT CONTRACTOR'S EXPENSE. CONTRACTOR SHALL PROVIDE TAPPING SLEEVE, VALVE, AND THRUST BLOCKS AS REQUIRED.

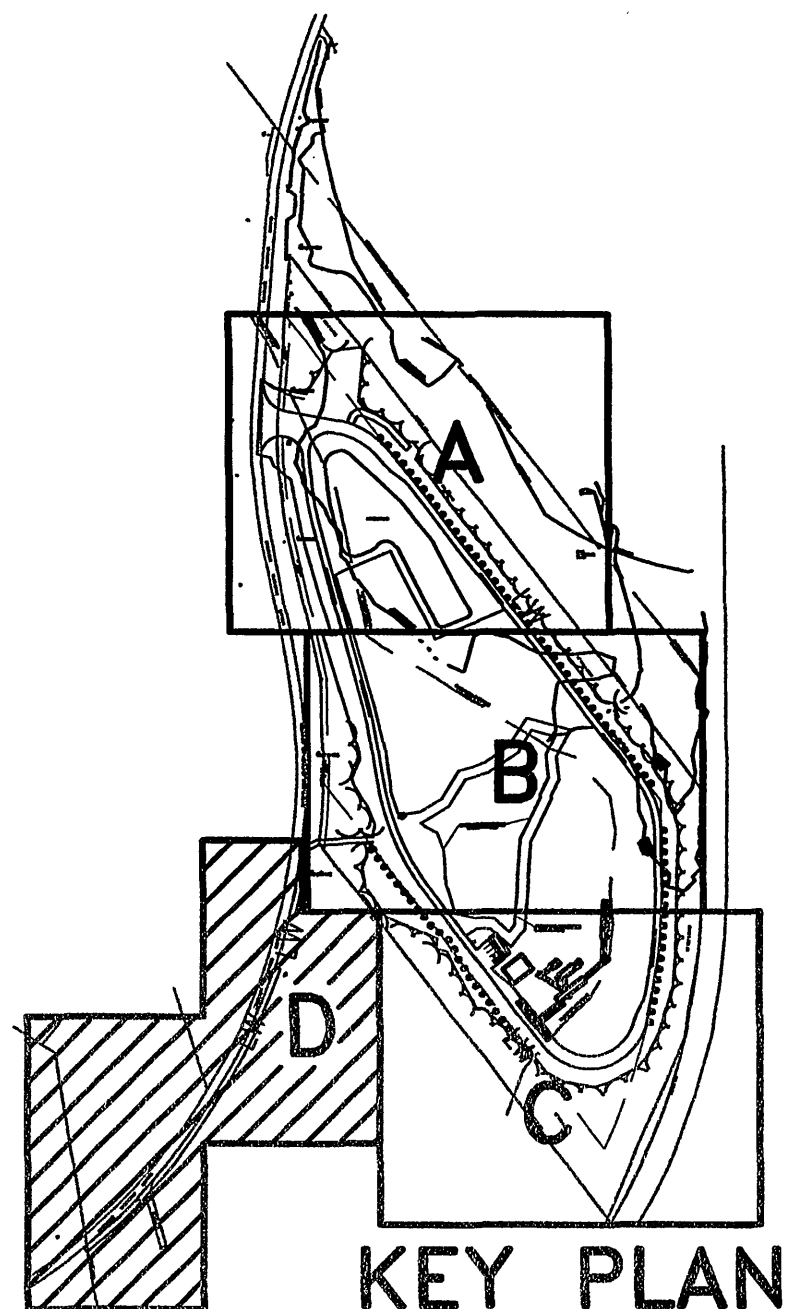

GRAPHIC SCALES
1"=30'
30' 15' 0' 30' 60'

As-Built 1.20.11 K. Winslow

REVISIONS	DESCRIPTION
Δ	4/27/10 NTG MLC PER ROANOKE COUNTY COMMENTS
MARK	DATE MADE BY CHECKED

AECOM
AECOM ENGINEERING, INC.
2401 S. ROANOKE AVENUE
ROANOKE, VA 24015
PHONE (840) 857-3100

APPROVED

COMMONWEALTH OF VIRGINIA
Conley A. Taylor
CONLEY A. TAYLOR
Lic. No. 21318
7/9/10
PROFESSIONAL ENGINEER

FOX HALL PROPERTIES LLC
ADAMS CONSTRUCTION ASPHALT PLANT
**UTILITY PLAN
AREA D**

PROJECT NO:	60091000
CAD DWG FILE:	UTCS_1030
DESIGNED BY:	NTG
DRAWN BY:	NTG
DEPT CHECK:	EPB
PROJ CHECK:	JSH
DATE:	APRIL 27, 2010
SCALE:	1"=30'
CS103D	
SHEET	23 OF 51