


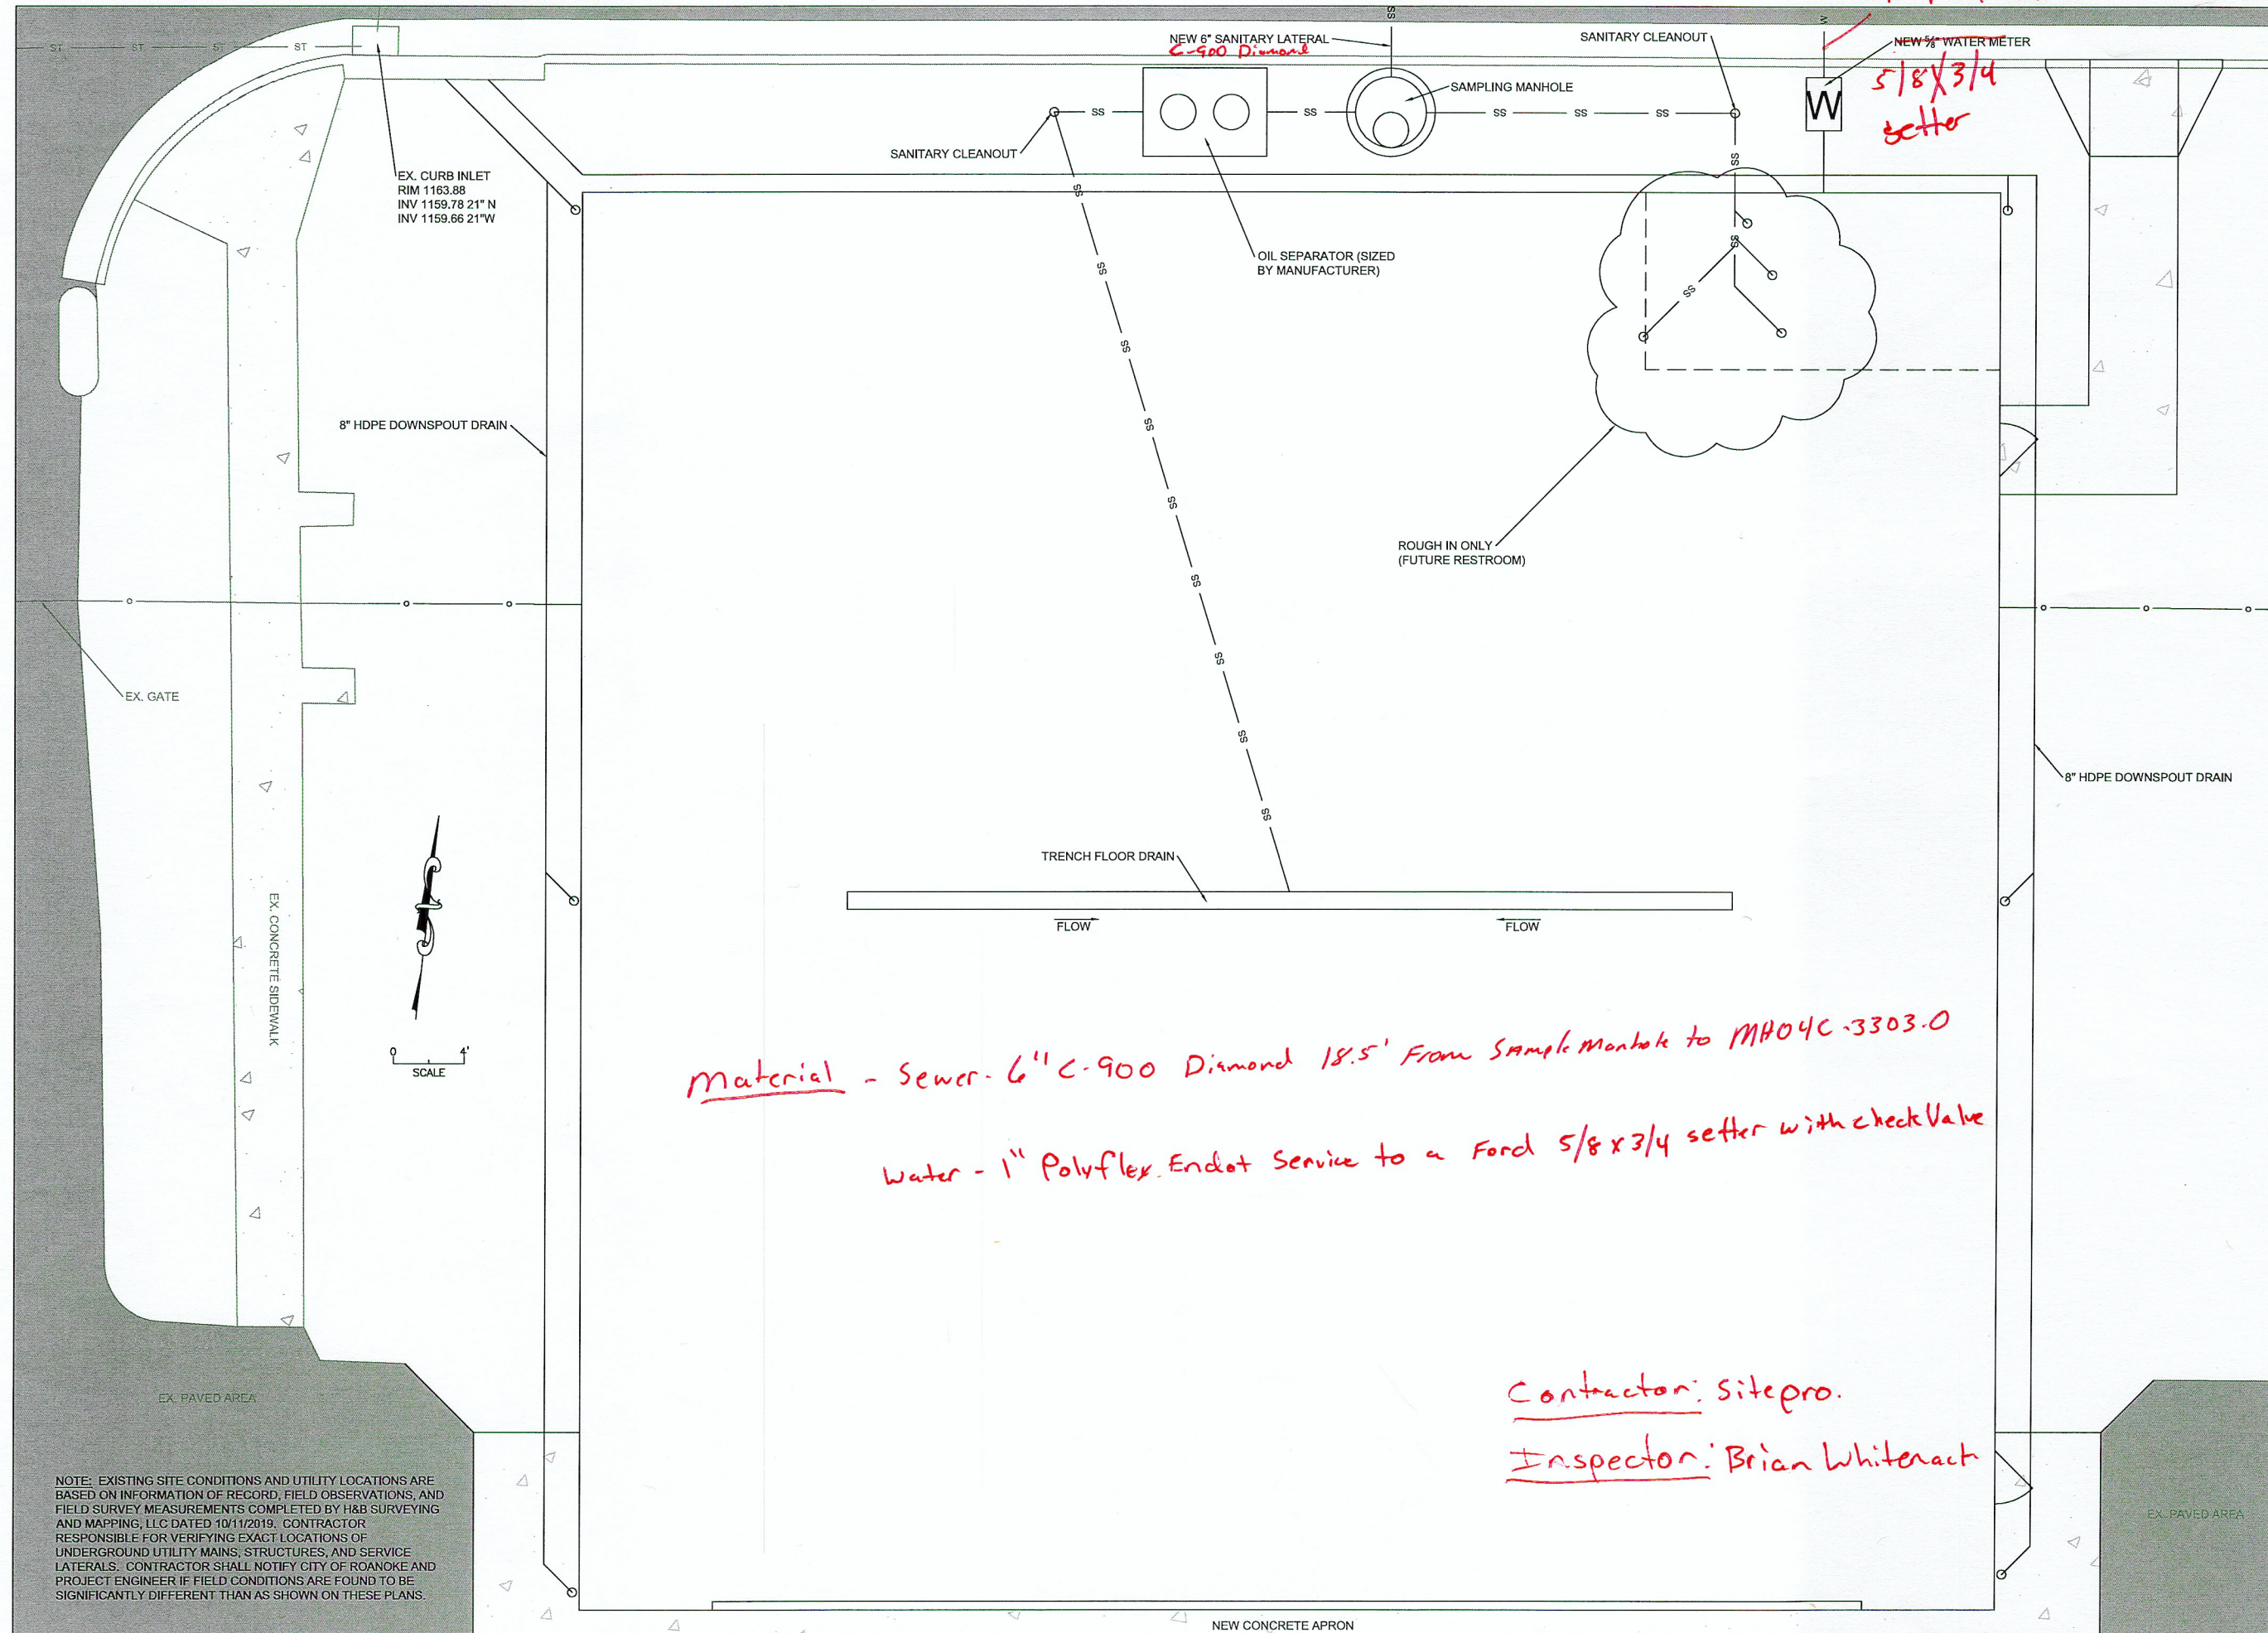

MECH., ELECT., & PLUMBING PLANS		#	REVISIONS	DATE
 OWNER = ROANOKE REGIONAL AIRPORT COMMISSION BUILDER = SUMMIT HELICOPTERS, INC. TAX PARCEL ID: 6590101 CITY OF ROANOKE, VIRGINIA		1	1ST CITY SUBMITTAL	03/20/2020
		2	REVISE LOCATION OF OIL SEPARATOR	05/04/2020
SCALE		$\frac{1}{4}" = 1'$		
SHEET NAME		PLUMBING		
SHEET NUMBER		3 OF 3		

Material - Sewer - 6" C-900 Diamond 18.5' From Sample Manhole to MH04C-3303.0
Water - 1" Polyflex Endot Service to a Ford 5/8 x 3/4 setter with check Valve

Contractor: Sitepro.
Inspector: Brian Whitenack

Per plan AS-built 5/15/2020