
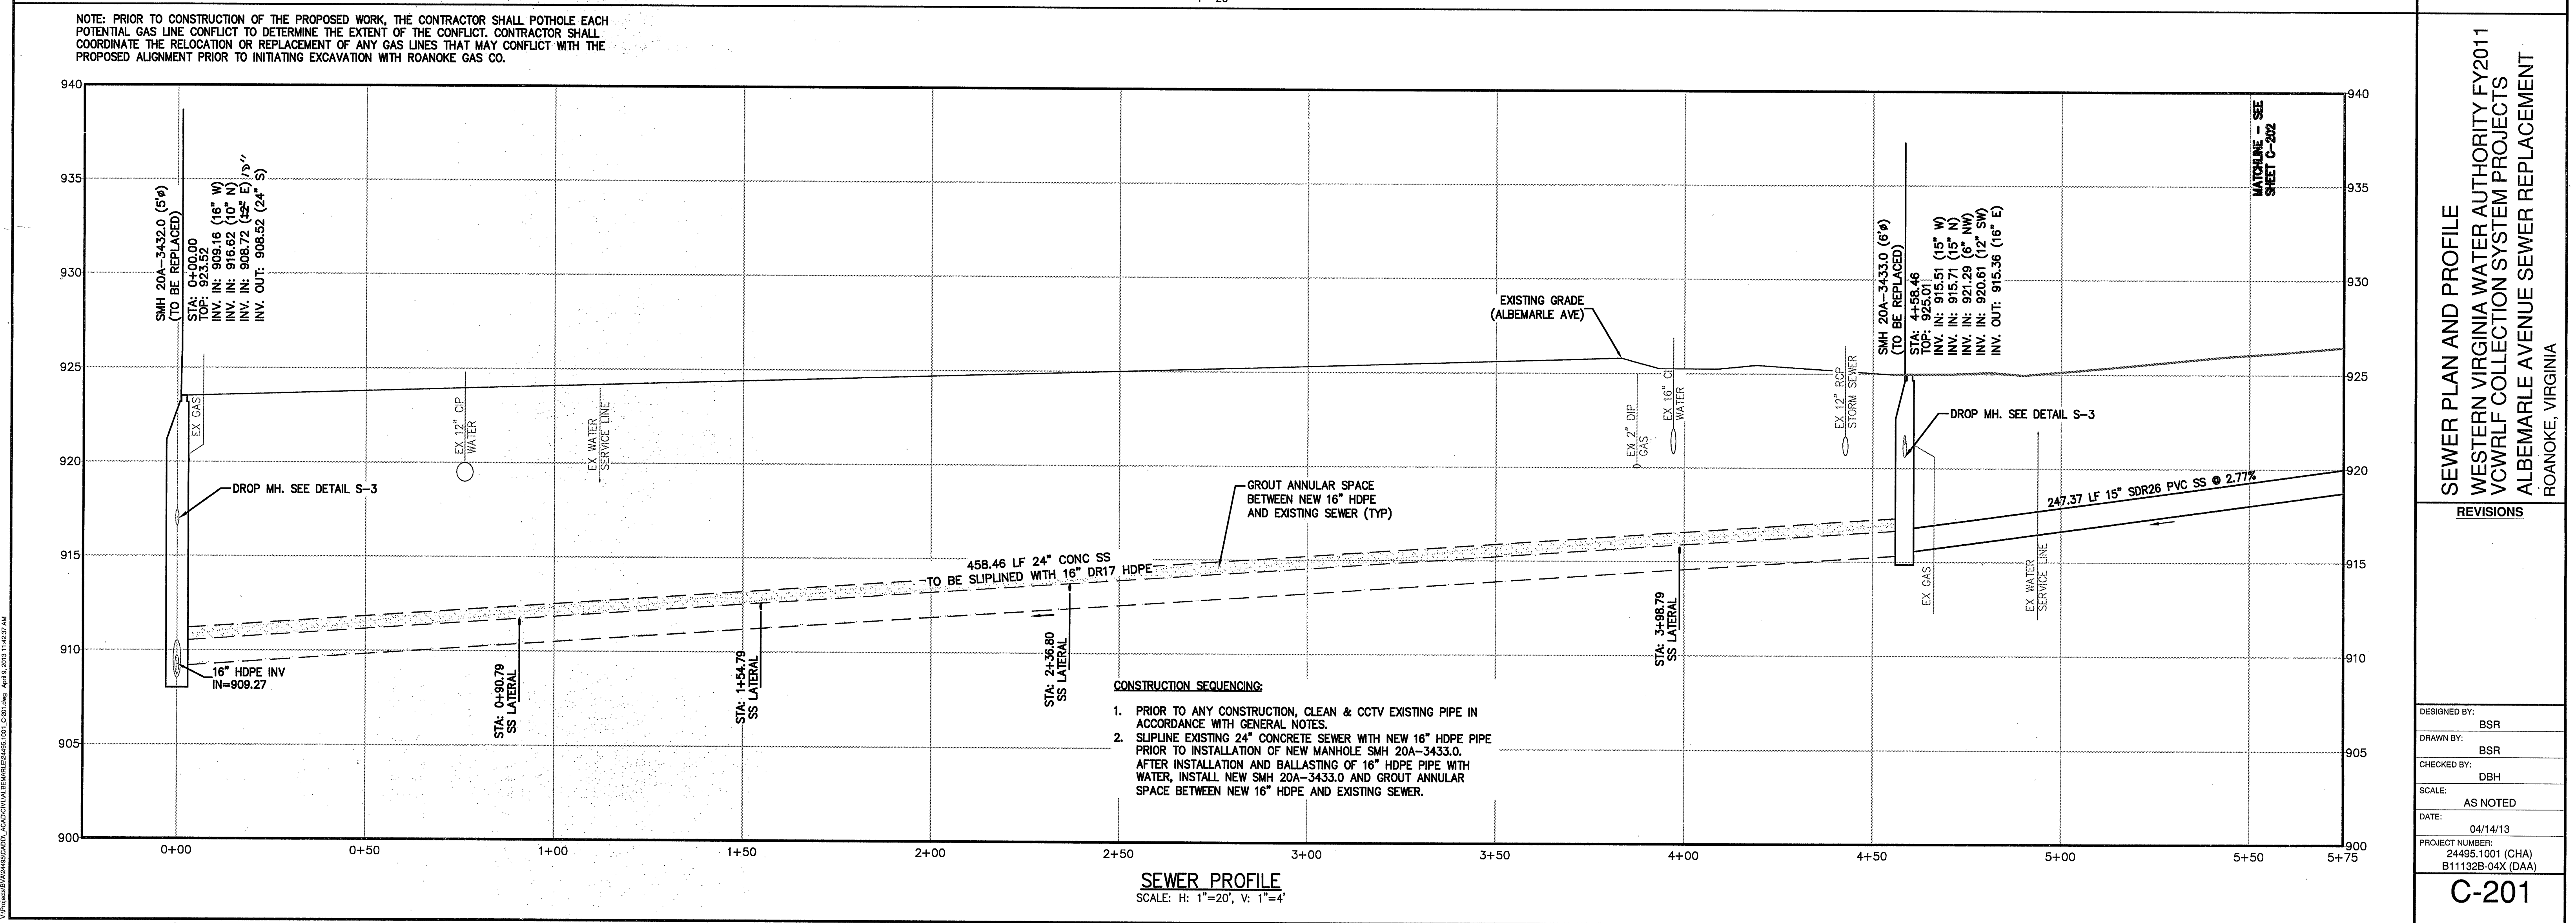


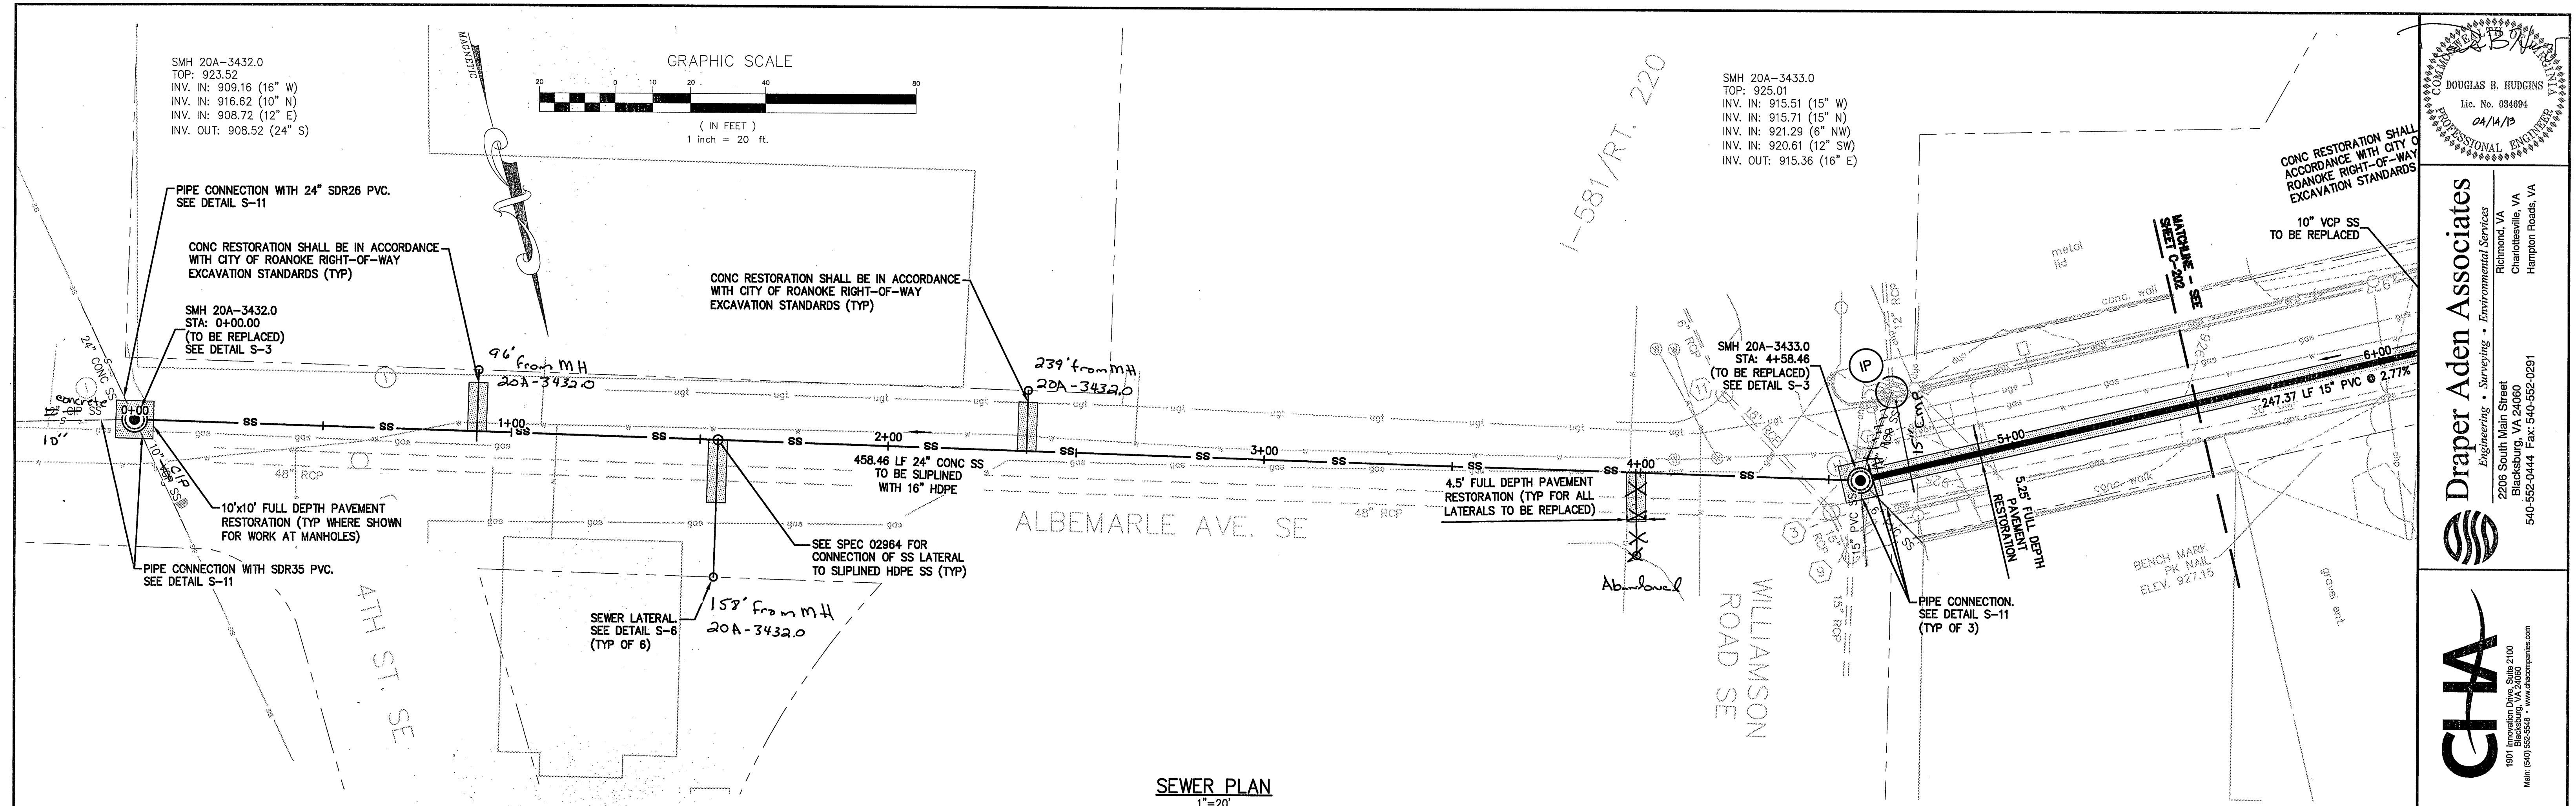

DOUGLAS B. HUDGINS
Lic. No. 034694
04/14/13
PROFESSIONAL ENGINEER

Draper Aden Associates
Engineering • Surveying • Environmental Services
2208 South Main Street
Richmond, VA 23260
Charlottesville, VA
Hampton Roads, VA
540-552-0444 Fax: 540-552-0291

CHA
1901 Innovation Drive, Suite 2100
Blacksburg, VA 24060
Main: (800) 525-5444 • www.cha-engineers.com

SEWER PLAN AND PROFILE
WESTERN VIRGINIA WATER AUTHORITY FY2011
VCWRLF COLLECTION SYSTEM PROJECTS
ALBEMARLE AVENUE SEWER REPLACEMENT
ROANOKE, VIRGINIA

REVISIONS	
DESIGNED BY:	BSR
DRAWN BY:	BSR
CHECKED BY:	DBH
SCALE:	AS NOTED
DATE:	04/14/13
PROJECT NUMBER:	24495.1001 (CHA) B11132B-04X (DAA)
C-201	