




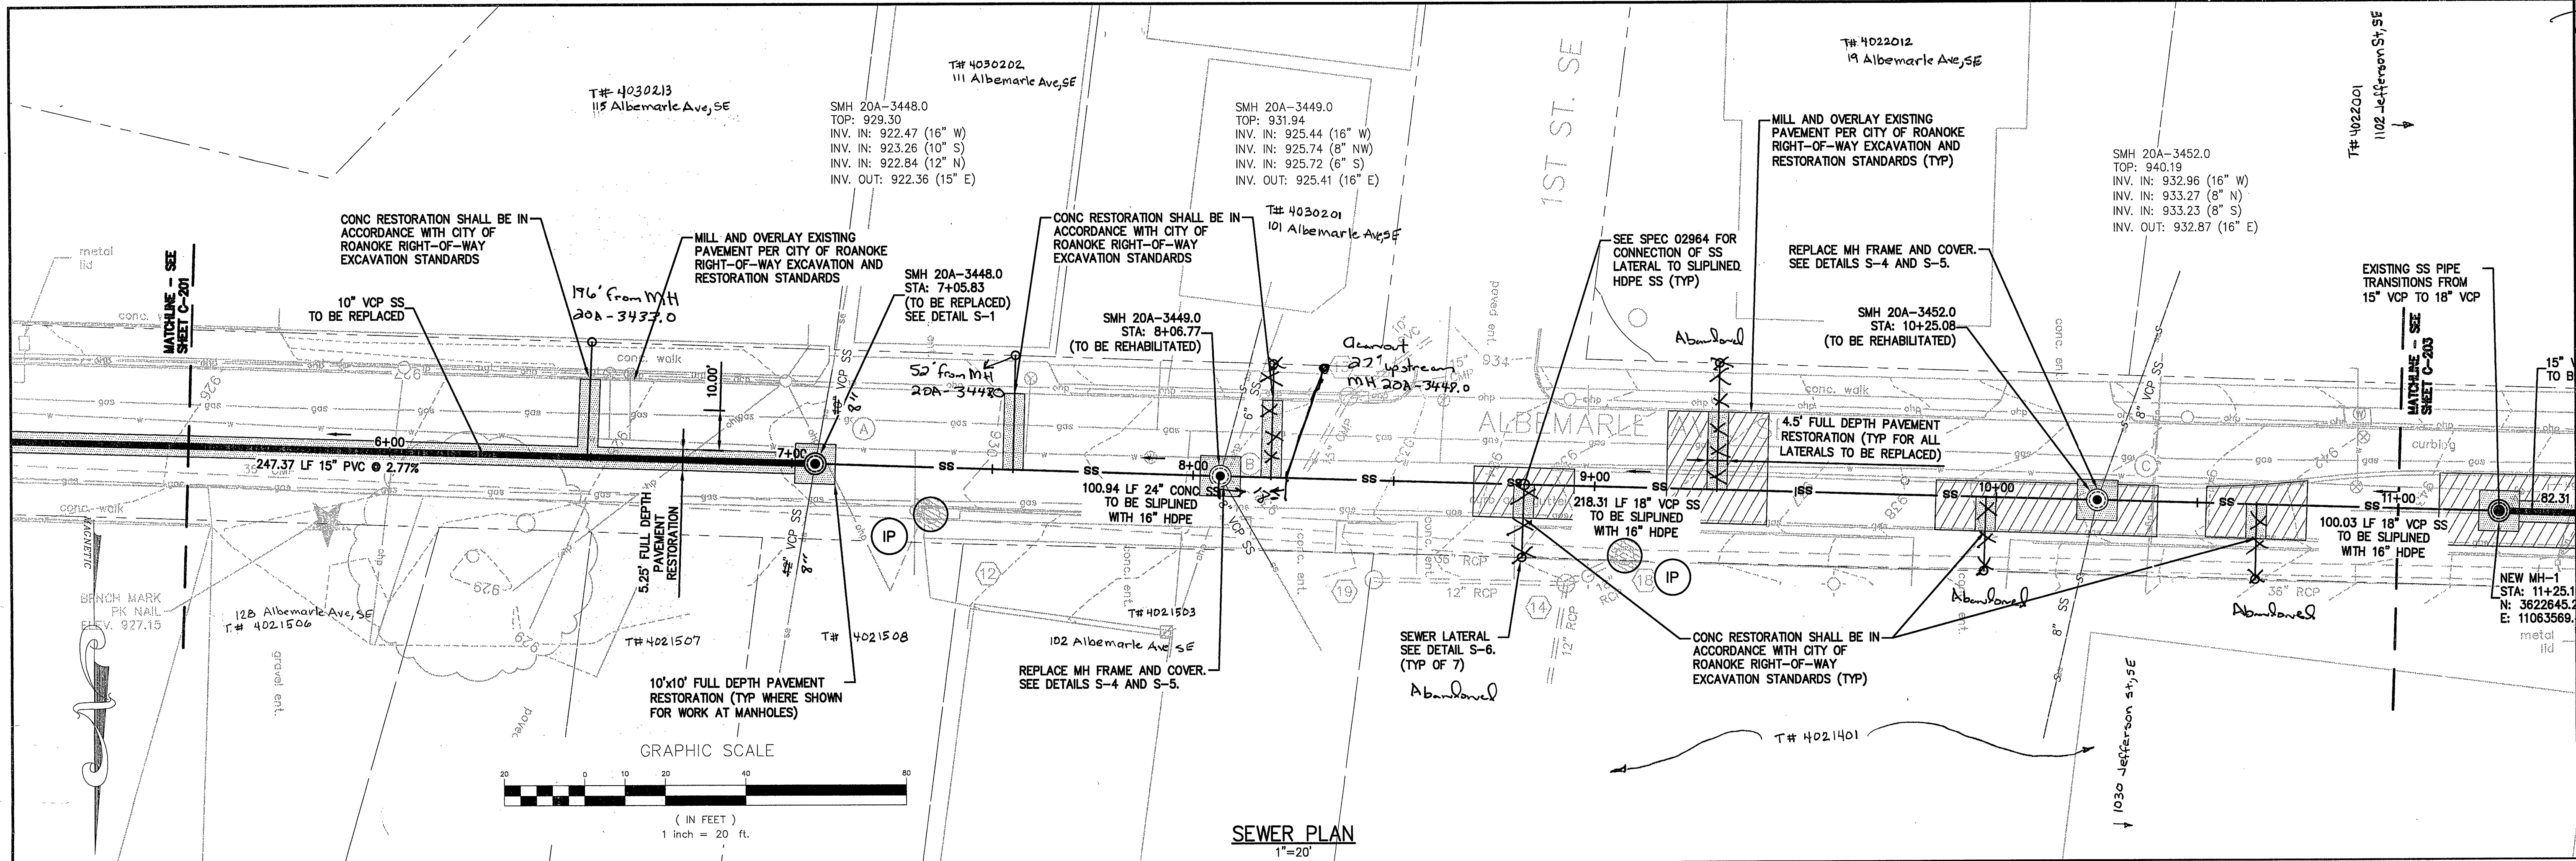

NOTE: PRIOR TO CONSTRUCTION OF THE PROPOSED WORK, THE CONTRACTOR SHALL POTHOLE EACH POTENTIAL GAS LINE CONFLICT TO DETERMINE THE EXTENT OF THE CONFLICT. CONTRACTOR SHALL COORDINATE THE RELOCATION OR REPLACEMENT OF ANY GAS LINES THAT MAY CONFLICT WITH THE PROPOSED ALIGNMENT PRIOR TO INITIATING EXCAVATION WITH ROANOKE GAS CO.

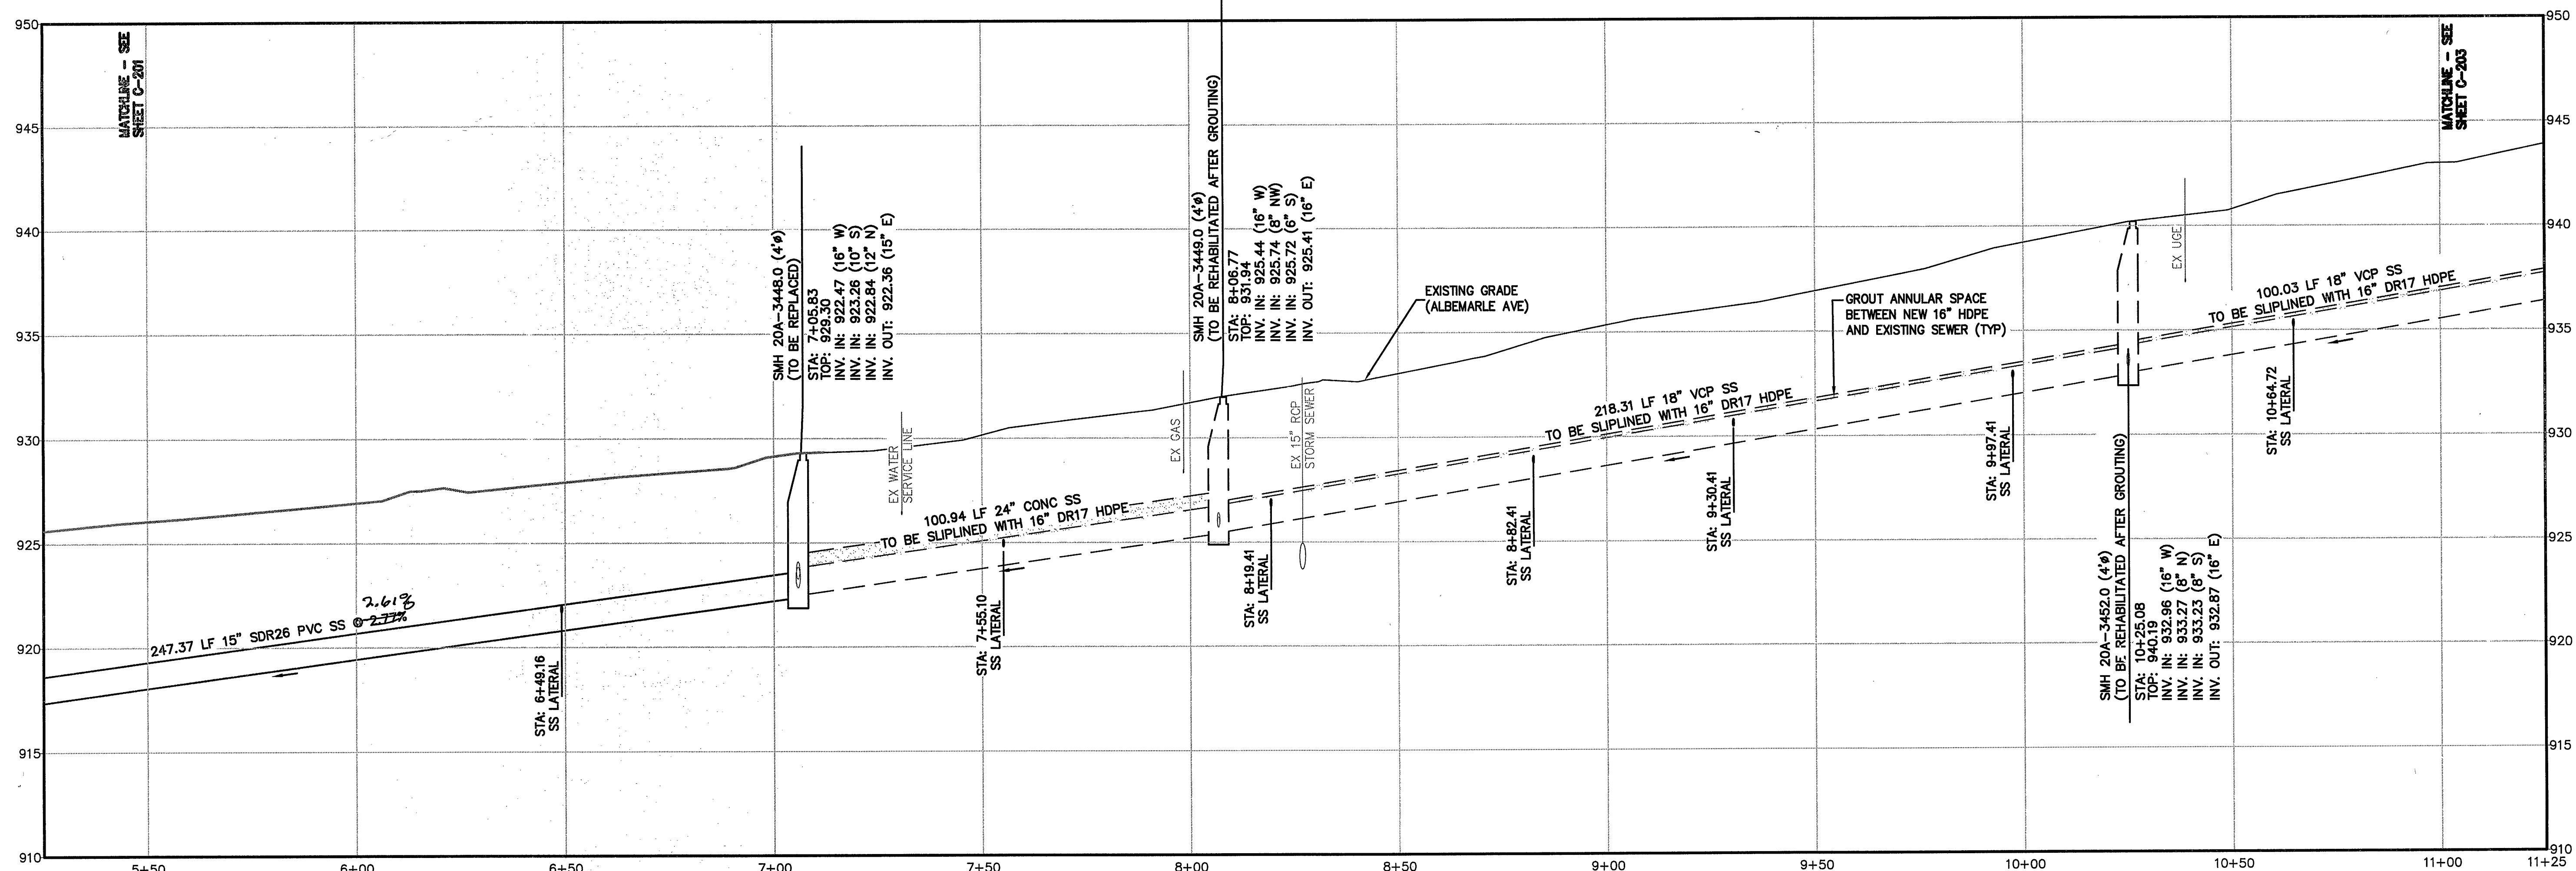

SEWER PROFILE
SCALE: H: 1"=20', V: 1"=4'

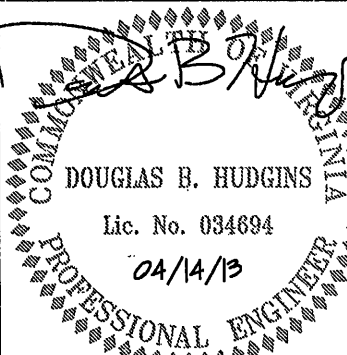

DOUGLAS B. HUDGENS
Lic. No. 034694
04/14/13
PROFESSIONAL ENGINEER



Draper Aden Associates
Engineering • Surveying • Environmental Services
2206 South Main Street
Blacksburg, VA 24060
540-552-0444 Fax: 540-552-0291

SEWER PLAN AND PROFILE
WESTERN VIRGINIA WATER AUTHORITY FY2011
VCWRLF COLLECTION SYSTEM PROJECTS
ALBEMARLE AVENUE SEWER REPLACEMENT
ROANOKE, VIRGINIA

REVISIONS	
DESIGNED BY:	BSR
DRAWN BY:	BSR
CHECKED BY:	DBH
SCALE:	AS NOTED
DATE:	04/14/13
PROJECT NUMBER:	24495.1001 (CHA) B11132B-04X (DAA)

C-202