



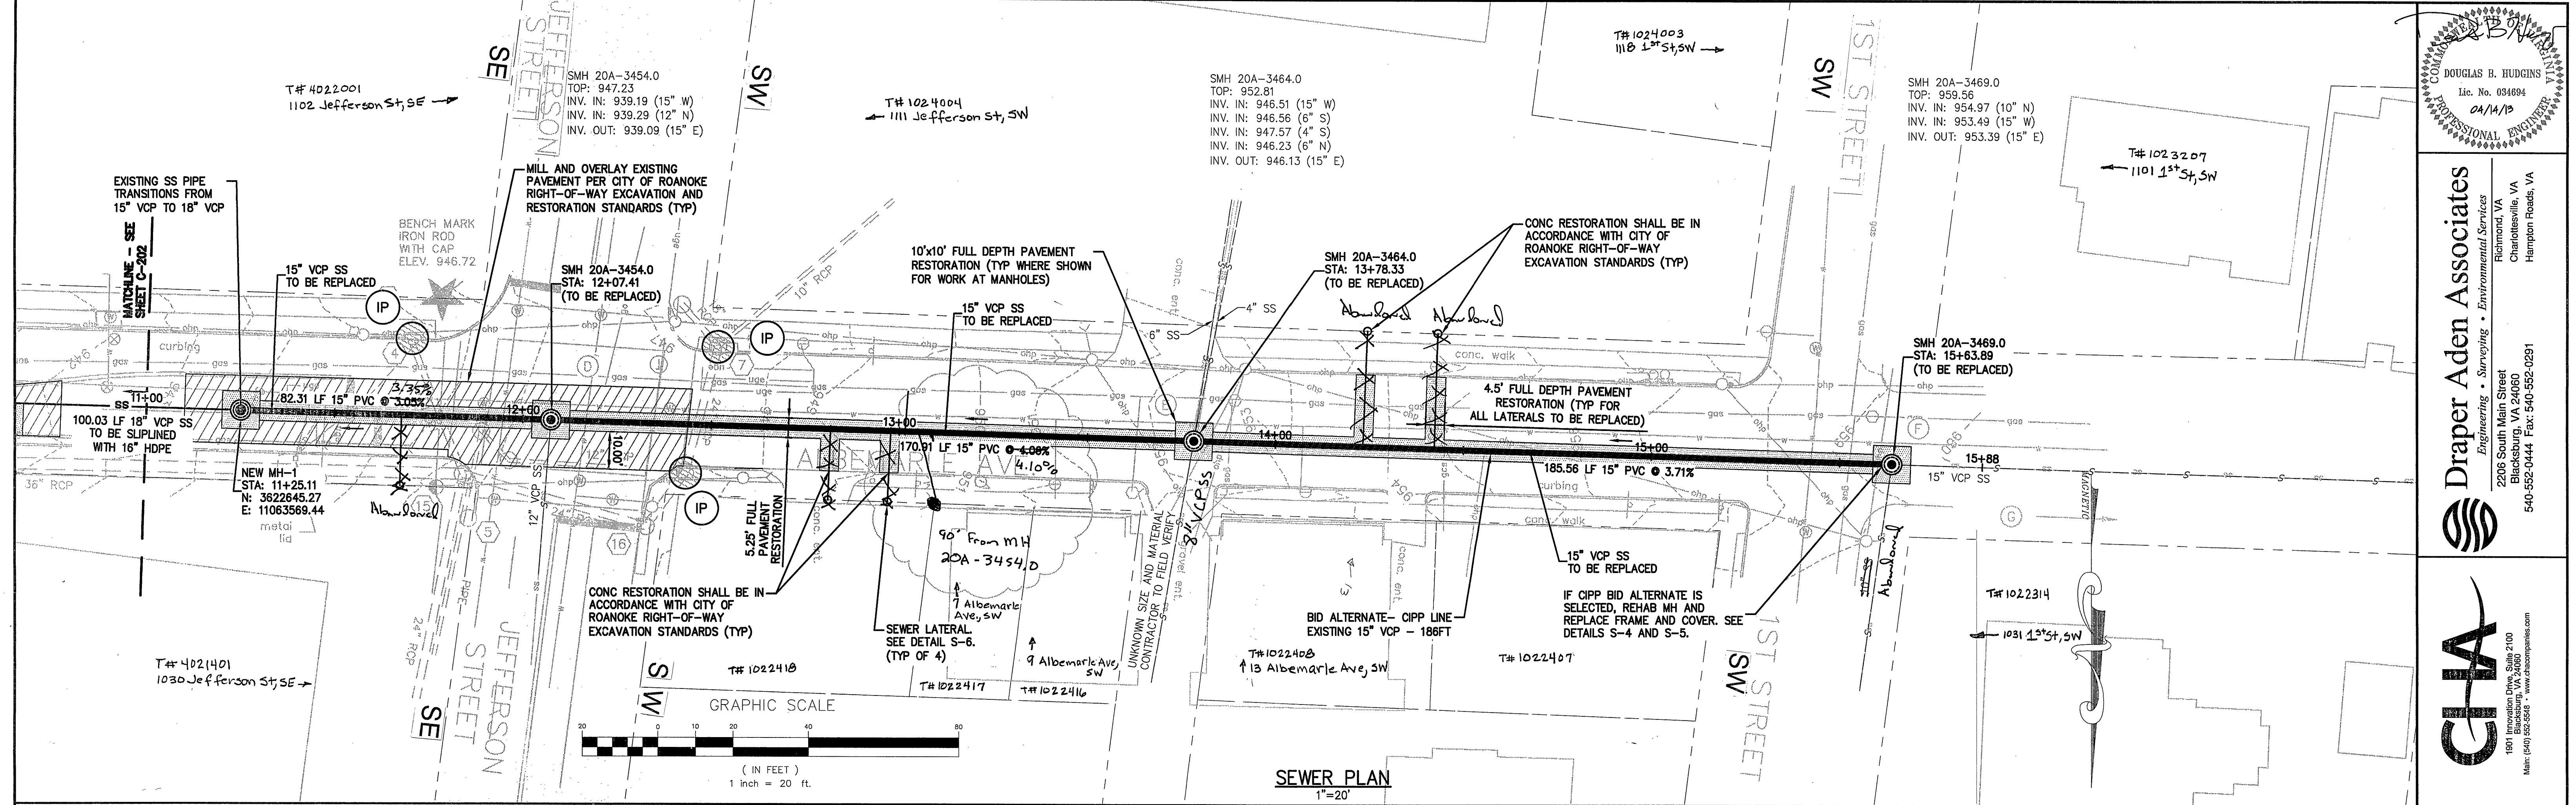

NOTE: PRIOR TO CONSTRUCTION OF THE PROPOSED WORK, THE CONTRACTOR SHALL POTHOLE EACH POTENTIAL GAS LINE CONFLICT TO DETERMINE THE EXTENT OF THE CONFLICT. CONTRACTOR SHALL COORDINATE THE RELOCATION OR REPLACEMENT OF ANY GAS LINES THAT MAY CONFLICT WITH THE PROPOSED ALIGNMENT PRIOR TO INITIATING EXCAVATION WITH ROANOKE GAS CO.

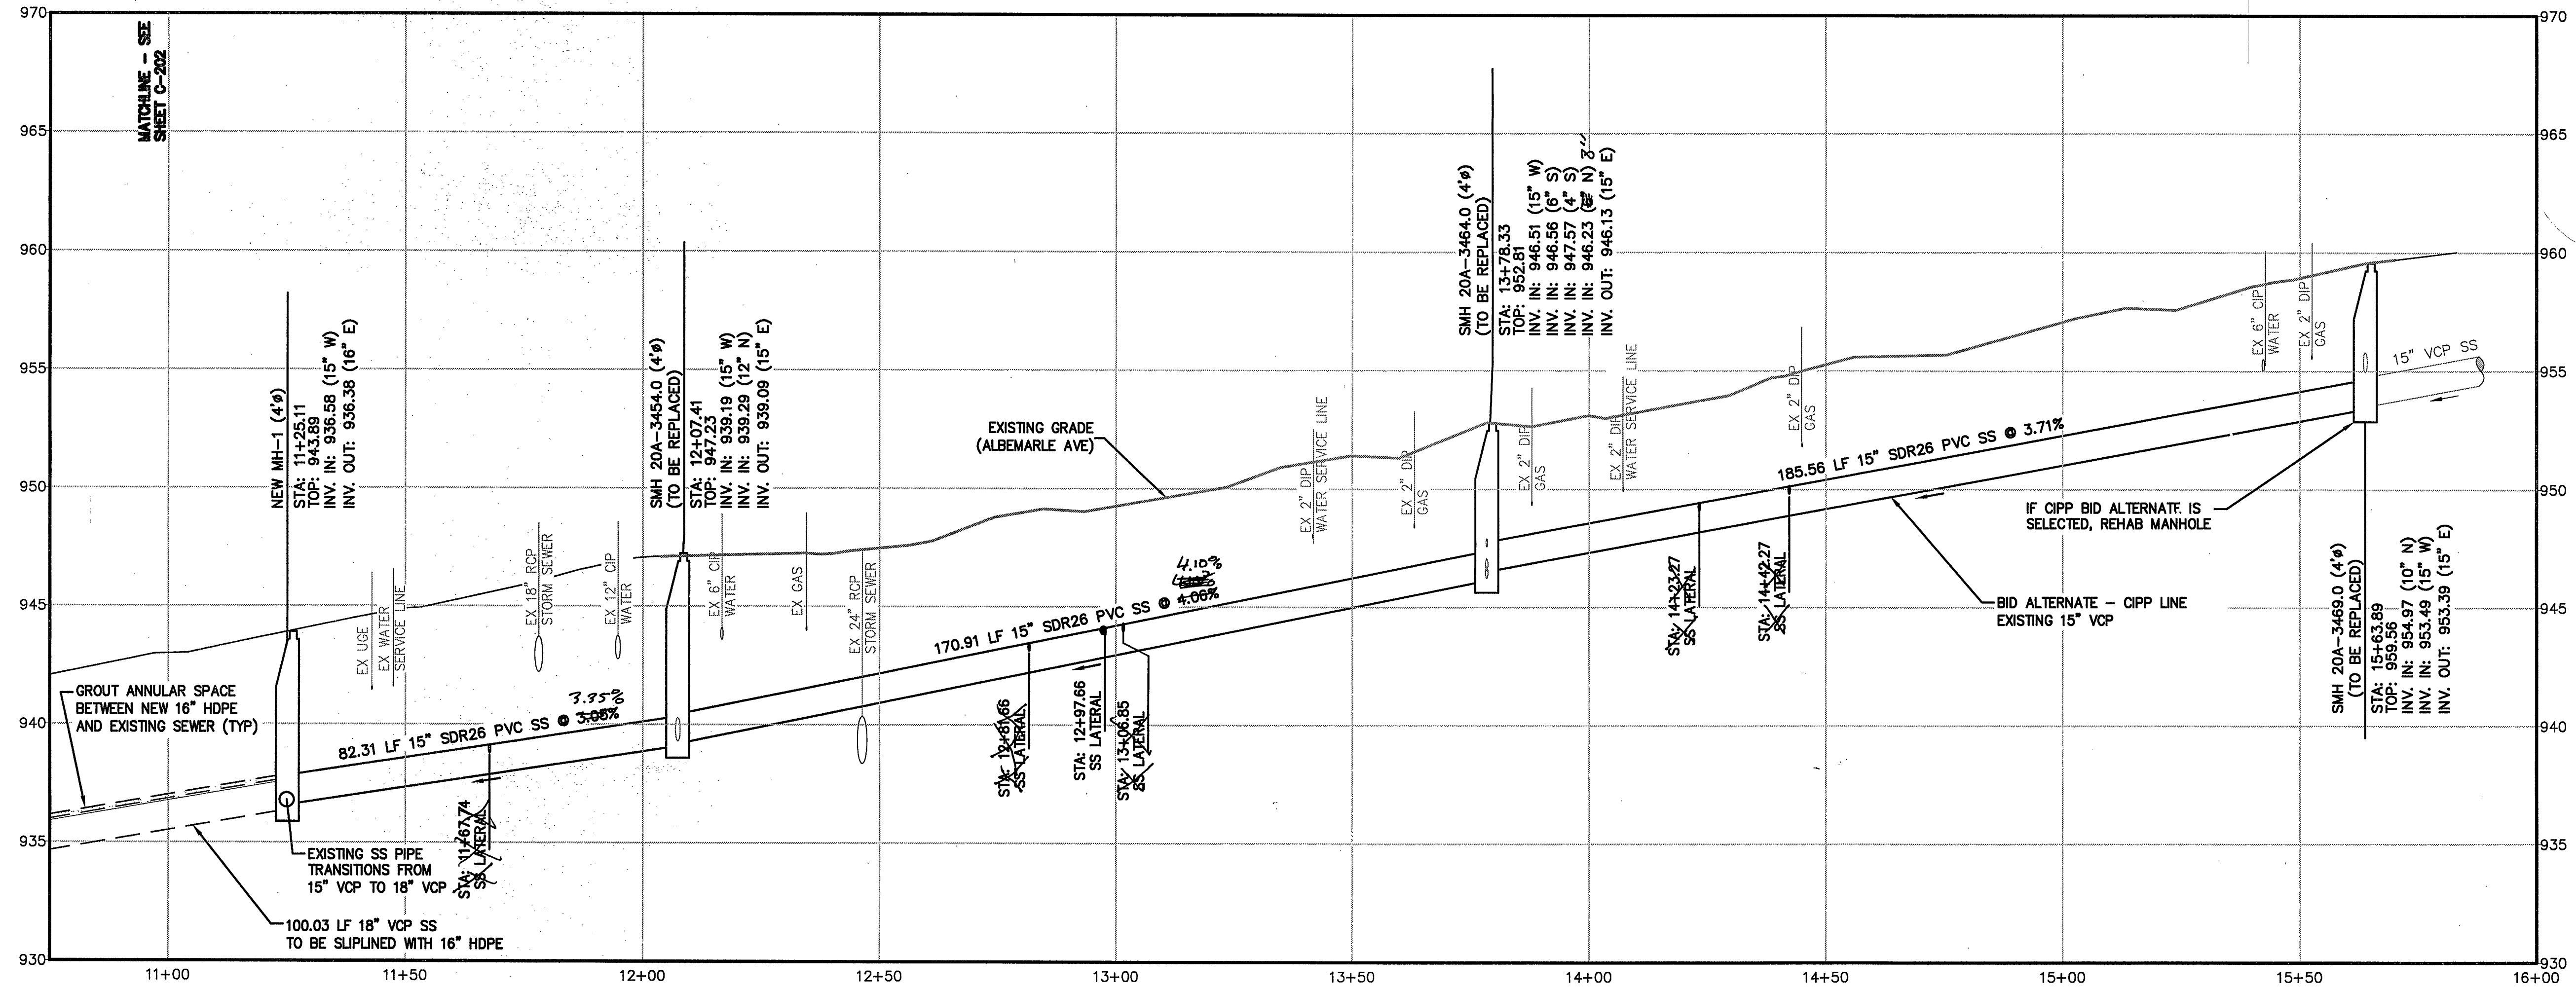

SEWER PROFILE
SCALE: H: 1"=20', V: 1"=4'

DOUGLAS B. HUDGINS
Lic. No. 034694
04/14/13
PROFESSIONAL ENGINEER

Draper Aden Associates

Engineering • Surveying • Environmental Services

2205 South Main Street
Blacksburg, VA 24060
540-552-0444 Fax: 540-552-0251

1901 Innovation Drive, Suite 2100
Blacksburg, VA 24060
Main: (540) 552-0444 Fax: (540) 552-0251
www.draperaden.com

SEWER PLAN AND PROFILE WESTERN VIRGINIA WATER AUTHORITY FY2011 VCWRLF COLLECTION SYSTEM PROJECTS ALBEMARLE AVENUE SEWER REPLACEMENT ROANOKE, VIRGINIA	
REVISIONS	
DESIGNED BY:	BSR
DRAWN BY:	BSR
CHECKED BY:	DBH
SCALE:	AS NOTED
DATE:	04/14/13
PROJECT NUMBER:	24495.1001 (CHA) B11132B-04X (DAA)
C-203	