

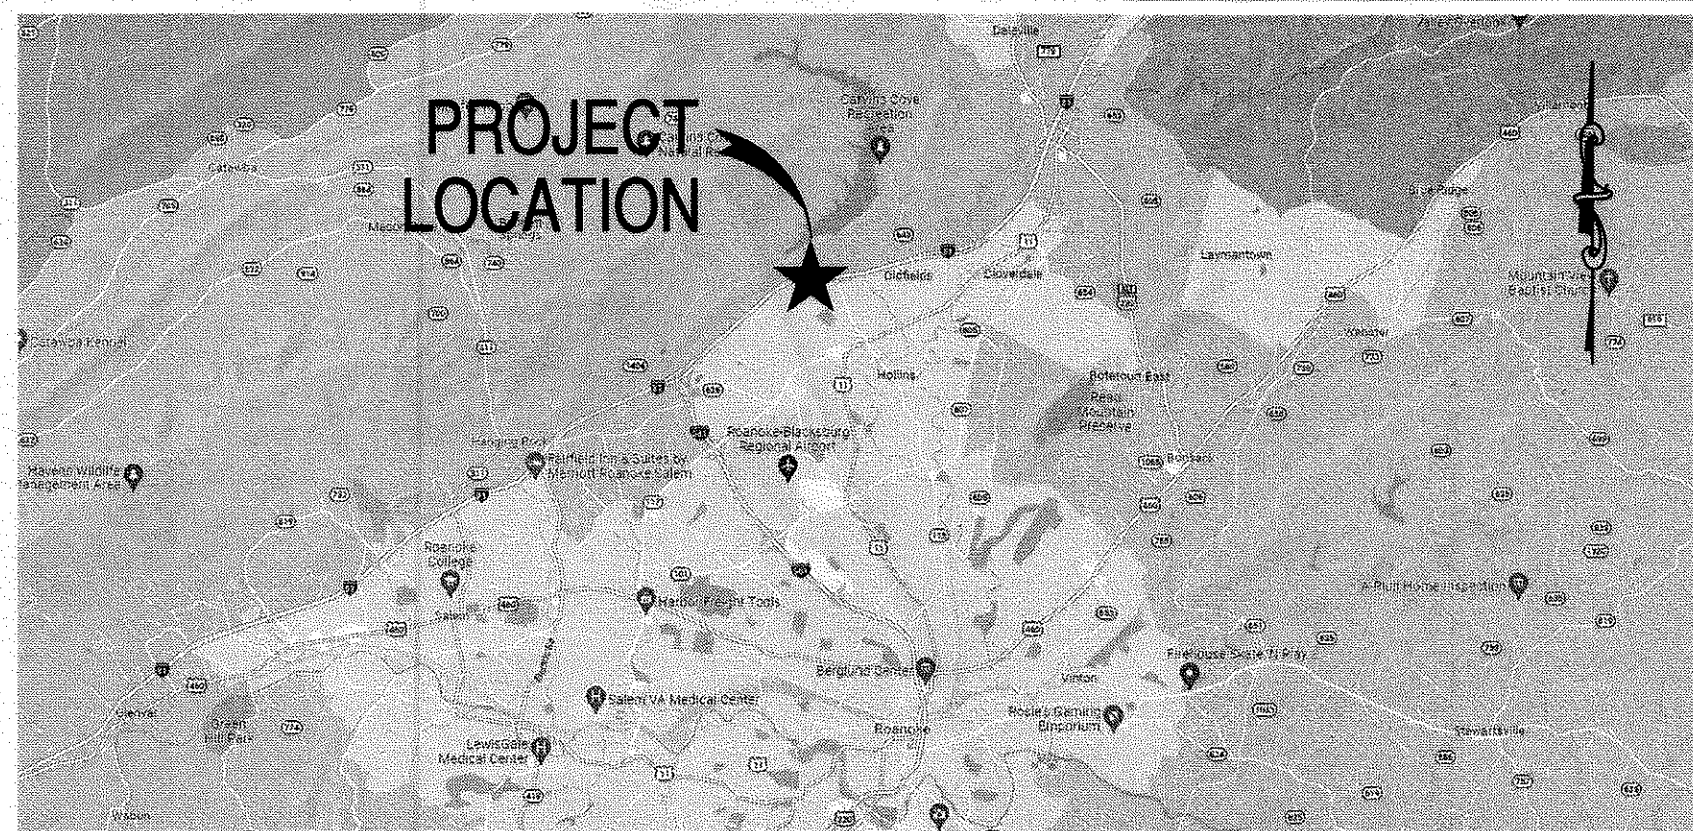


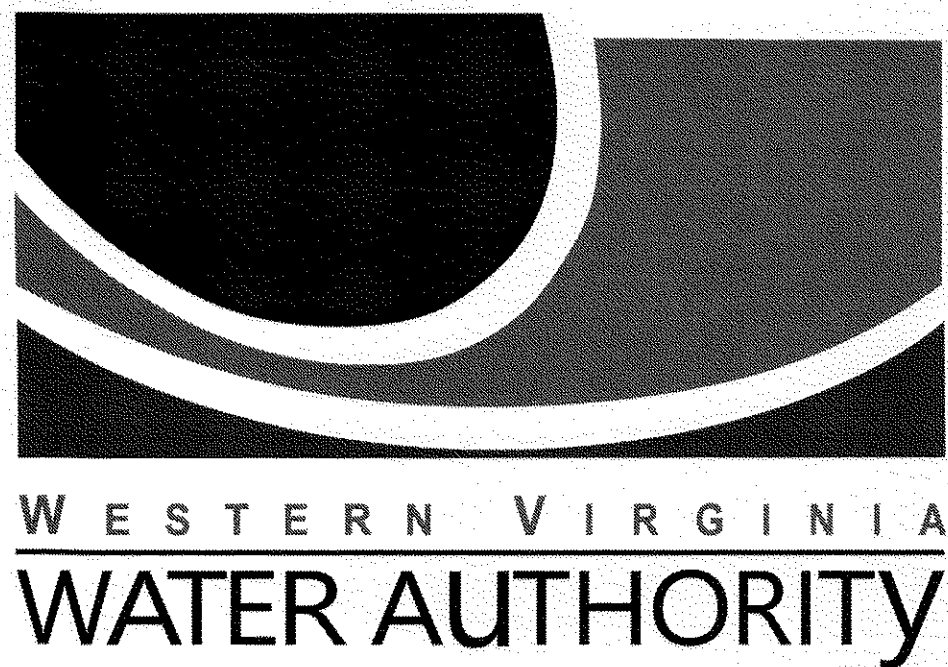

WESTERN VIRGINIA WATER AUTHORITY
ANGEL LANE INTERCONNECTION
WCIP-216
ROANOKE COUNTY , VIRGINIA

LOCATION MAP
NO SCALE

DRAWING TITLE	SHEET NUMBER
COVER	1
SHEET LAYOUT & FIRE HYDRANT COVERAGE MAP	2
GENERAL NOTES & PROPOSED LEGEND	3
SURVEY SCHEDULES, NOTES, & EXISTING LEGEND	4
24" WATER MAIN PLAN - PROFILE, STA. 10+00 TO STA. 15+00	5
24" WATER MAIN PLAN - PROFILE, STA. 15+00 TO STA. 20+00	6
24" WATER MAIN PLAN - PROFILE, STA. 20+00 TO STA. 25+00	7
24" WATER MAIN PLAN - PROFILE, STA. 25+00 TO STA. 30+00	8
24" WATER MAIN PLAN - PROFILE, STA. 30+00 TO STA. 35+00	9
24" WATER MAIN PLAN - PROFILE, STA. 35+00 TO STA. 40+00	10
24" WATER MAIN PLAN - PROFILE, STA. 40+00 TO STA. 45+00	11
24" WATER MAIN PLAN - PROFILE, STA. 45+00 TO STA. 50+00	12
24" WATER MAIN PLAN - PROFILE, STA. 50+00 TO STA. 55+00	13
24" WATER MAIN PLAN - PROFILE, STA. 55+00 TO STA. 60+00	14
24" WATER MAIN PLAN - PROFILE, STA. 60+00 TO STA. 65+00	15
24" WATER MAIN PLAN - PROFILE, STA. 65+00 TO STA. 70+00	16
24" WATER MAIN PLAN - PROFILE, STA. 70+00 TO STA. 75+50	17
24" WATER MAIN PLAN - PROFILE, STA. 75+50 TO STA. 81+00	18
24" WATER MAIN PLAN - PROFILE, STA. 81+00 TO STA. 86+00	19
24" WATER MAIN PLAN - PROFILE, STA. 86+00 TO STA. 91+50	20
24" WATER MAIN PLAN - PROFILE, STA. 91+50 TO STA. 97+17	21
ELECTRICAL SITE PLAN	22
EROSION & SEDIMENT CONTROL NOTES	23
EROSION & SEDIMENT CONTROL DETAILS	24
STANDARD DETAILS	25
STANDARD DETAILS	26
TEMPORARY TRAFFIC CONTROL PLAN NOTES	27
TEMPORARY TRAFFIC CONTROL PLAN NOTES	28
TEMPORARY TRAFFIC CONTROL PLAN FIGURE 1	29
TEMPORARY TRAFFIC CONTROL PLAN FIGURE 2	30
TEMPORARY TRAFFIC CONTROL PLAN FIGURE 3	31

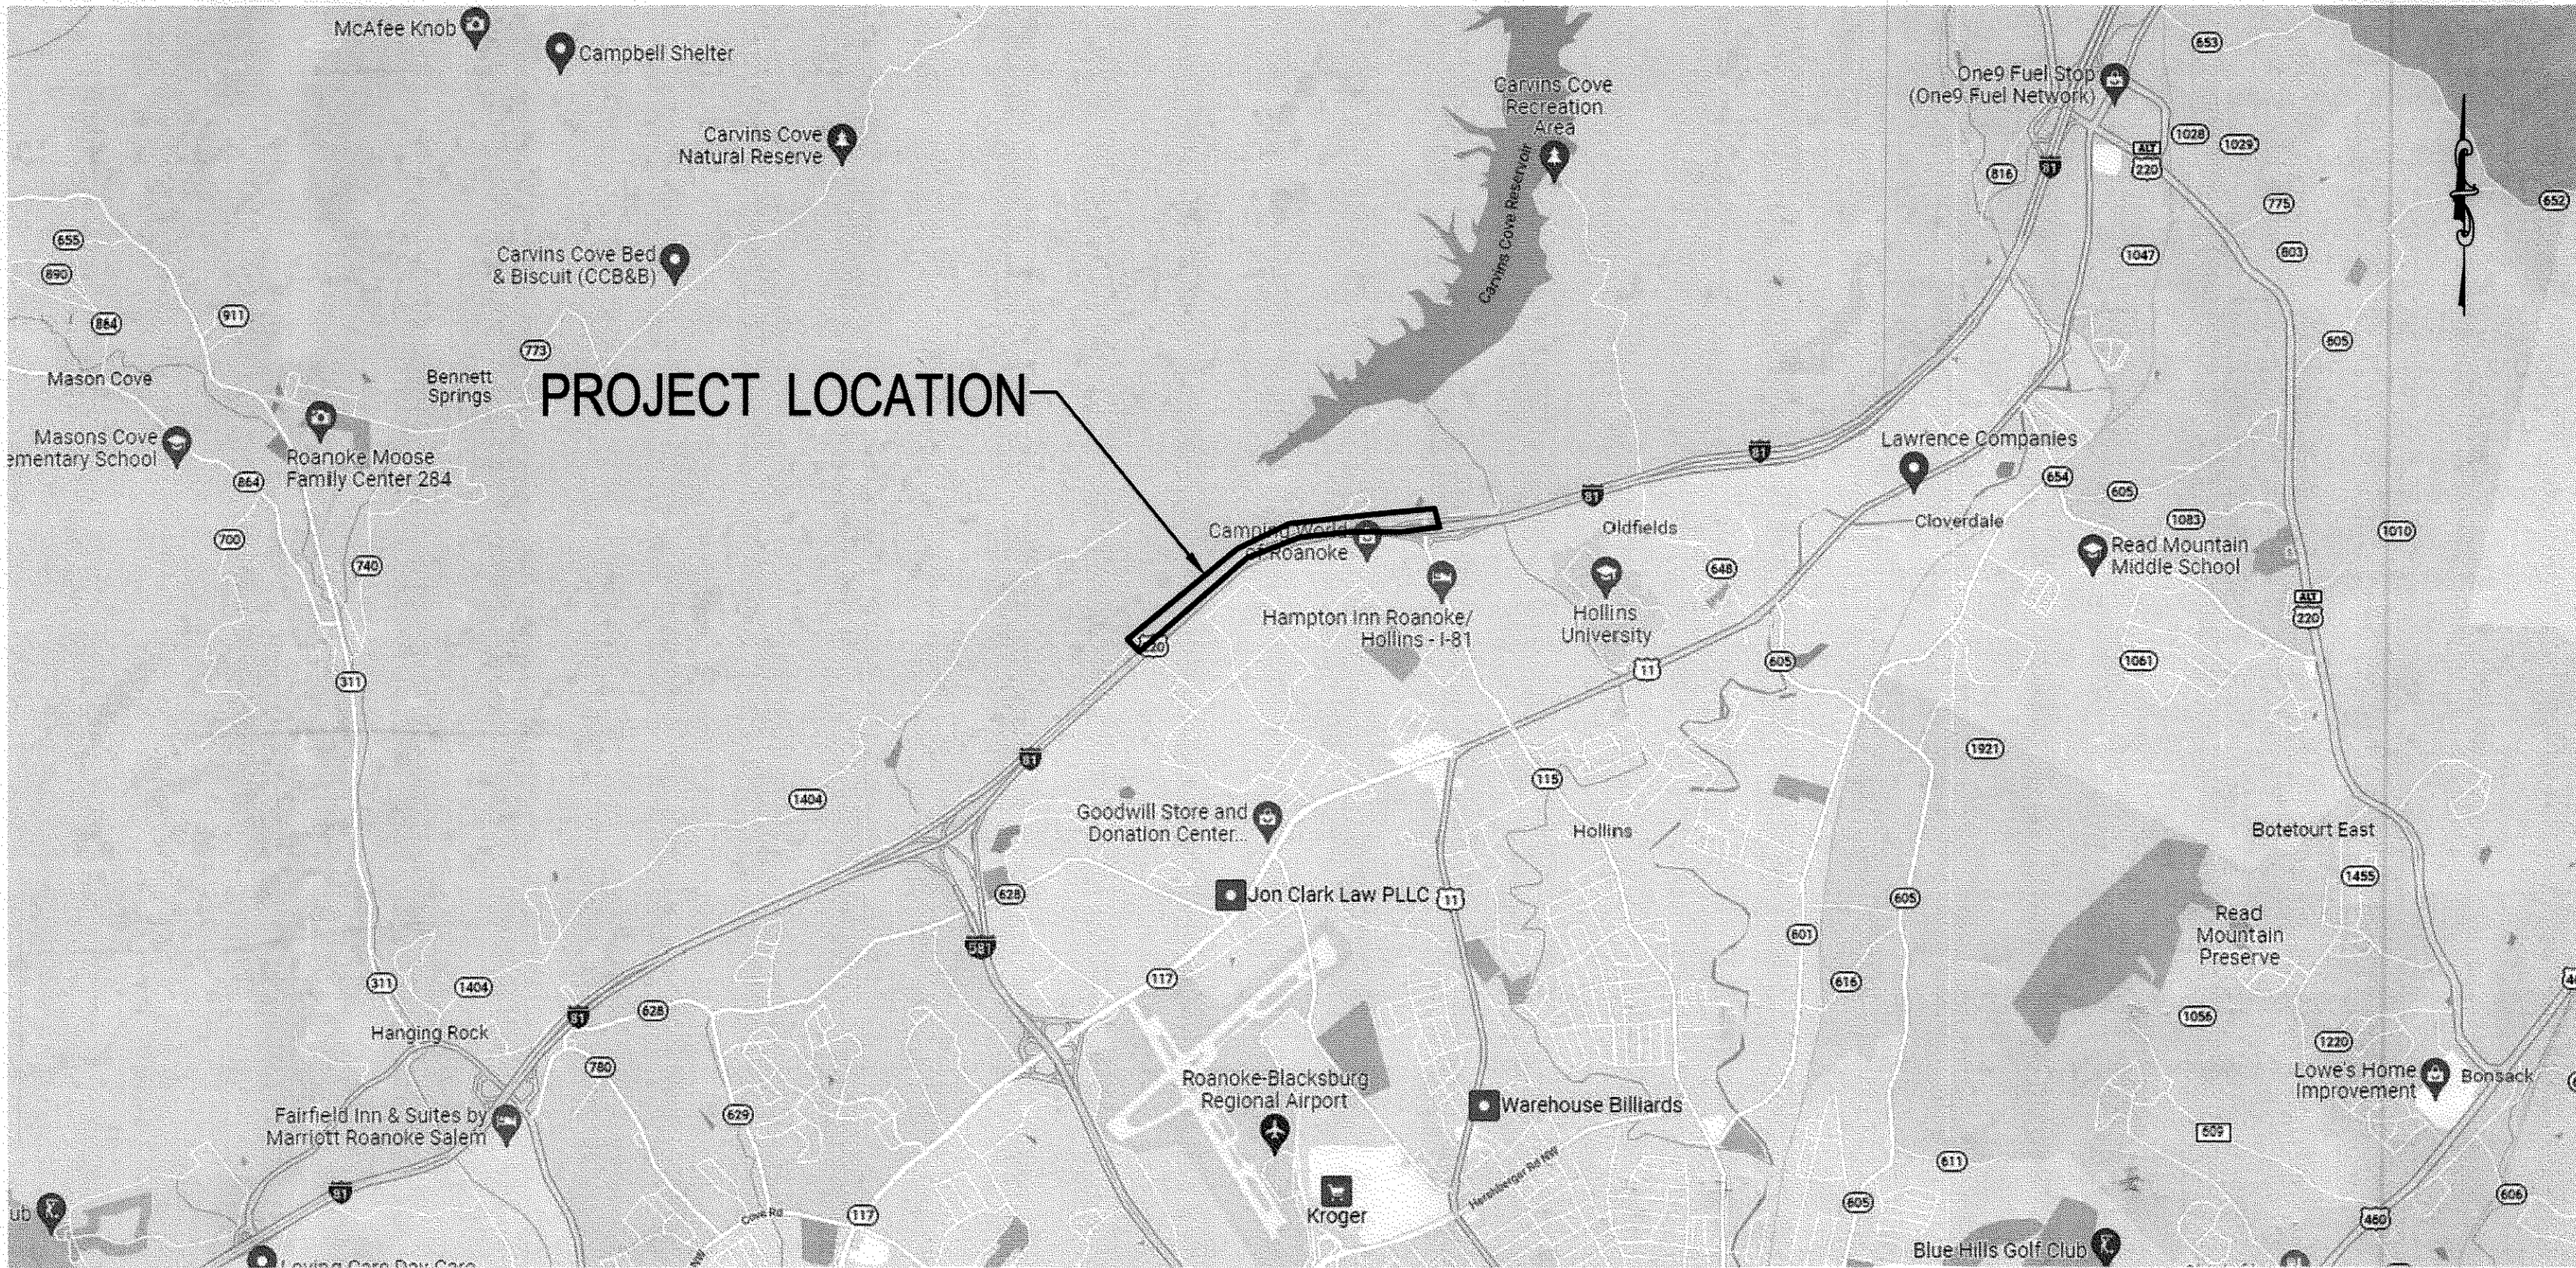



VICINITY MAP
NO SCALE

JUNE 2023

OWNER: WWA
CONSTRUCTION MANAGER DAVID BARNHART
601 SOUTH JEFFERSON ST - SUITE 300
ROANOKE, VA 24011
DAVID.BARNHART@WESTERNVAWATER.ORG
(540) 283-2970
ENGINEER: WHITMAN, REQUARDT & ASSOCIATES, LLP.
1700 KRAFT DRIVE, SUITE 1200
BLACKSBURG, VA 24060
PAULA MOORE, PE
(540) 328-1114

WVWA INSPECTOR AS-BUILT
CHARLES CRUSH
10-17-2024

VESCP Approval
These plans have been reviewed and approved under WVWA ASAS.
Approved By: Joseph W. Arthur, DCA 0104 Exp. 10/02/2023
Signature: [Signature] Date: 6/21/2023

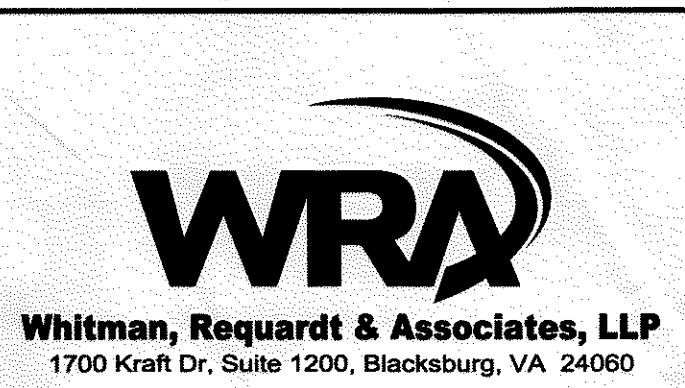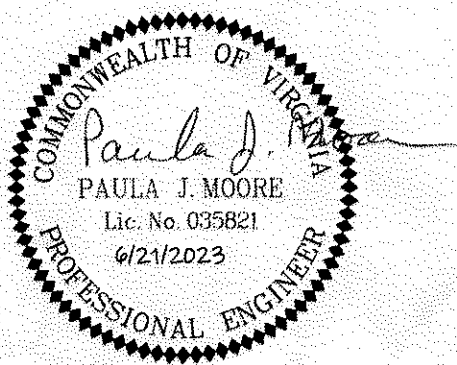

WESTERN VIRGINIA WATER AUTHORITY
601 South Jefferson Street, Suite 300
Roanoke, Virginia 24011

DES: BP
DRAWN: JES
CHECK: PJM
DATE: 6/20/23
SCALE: N/A
HORIZ: N/A
VERT: N/A

ANGEL LANE INTERCONNECTION

COVER

DRAWING
C1.01

SHEET
1