
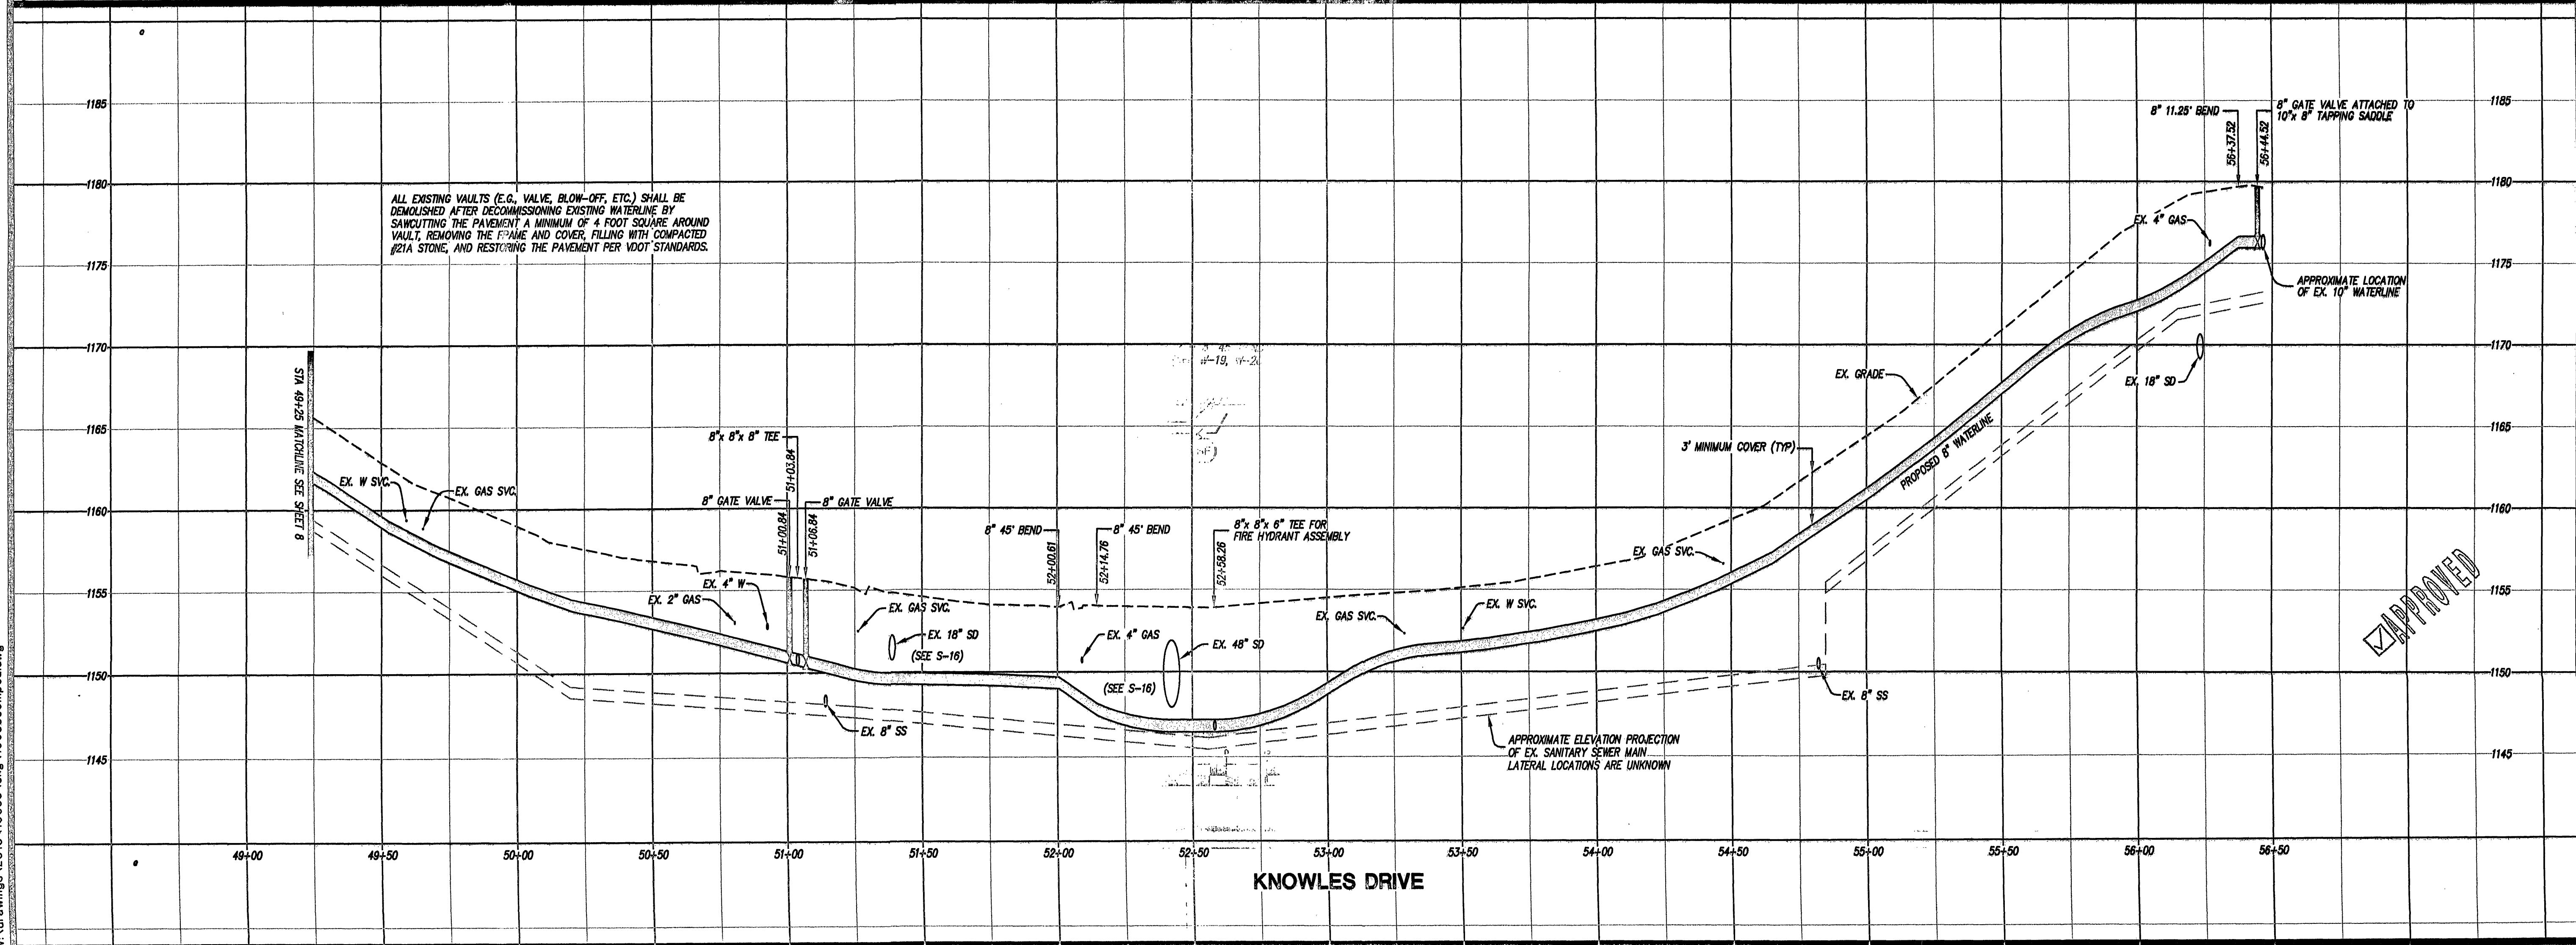


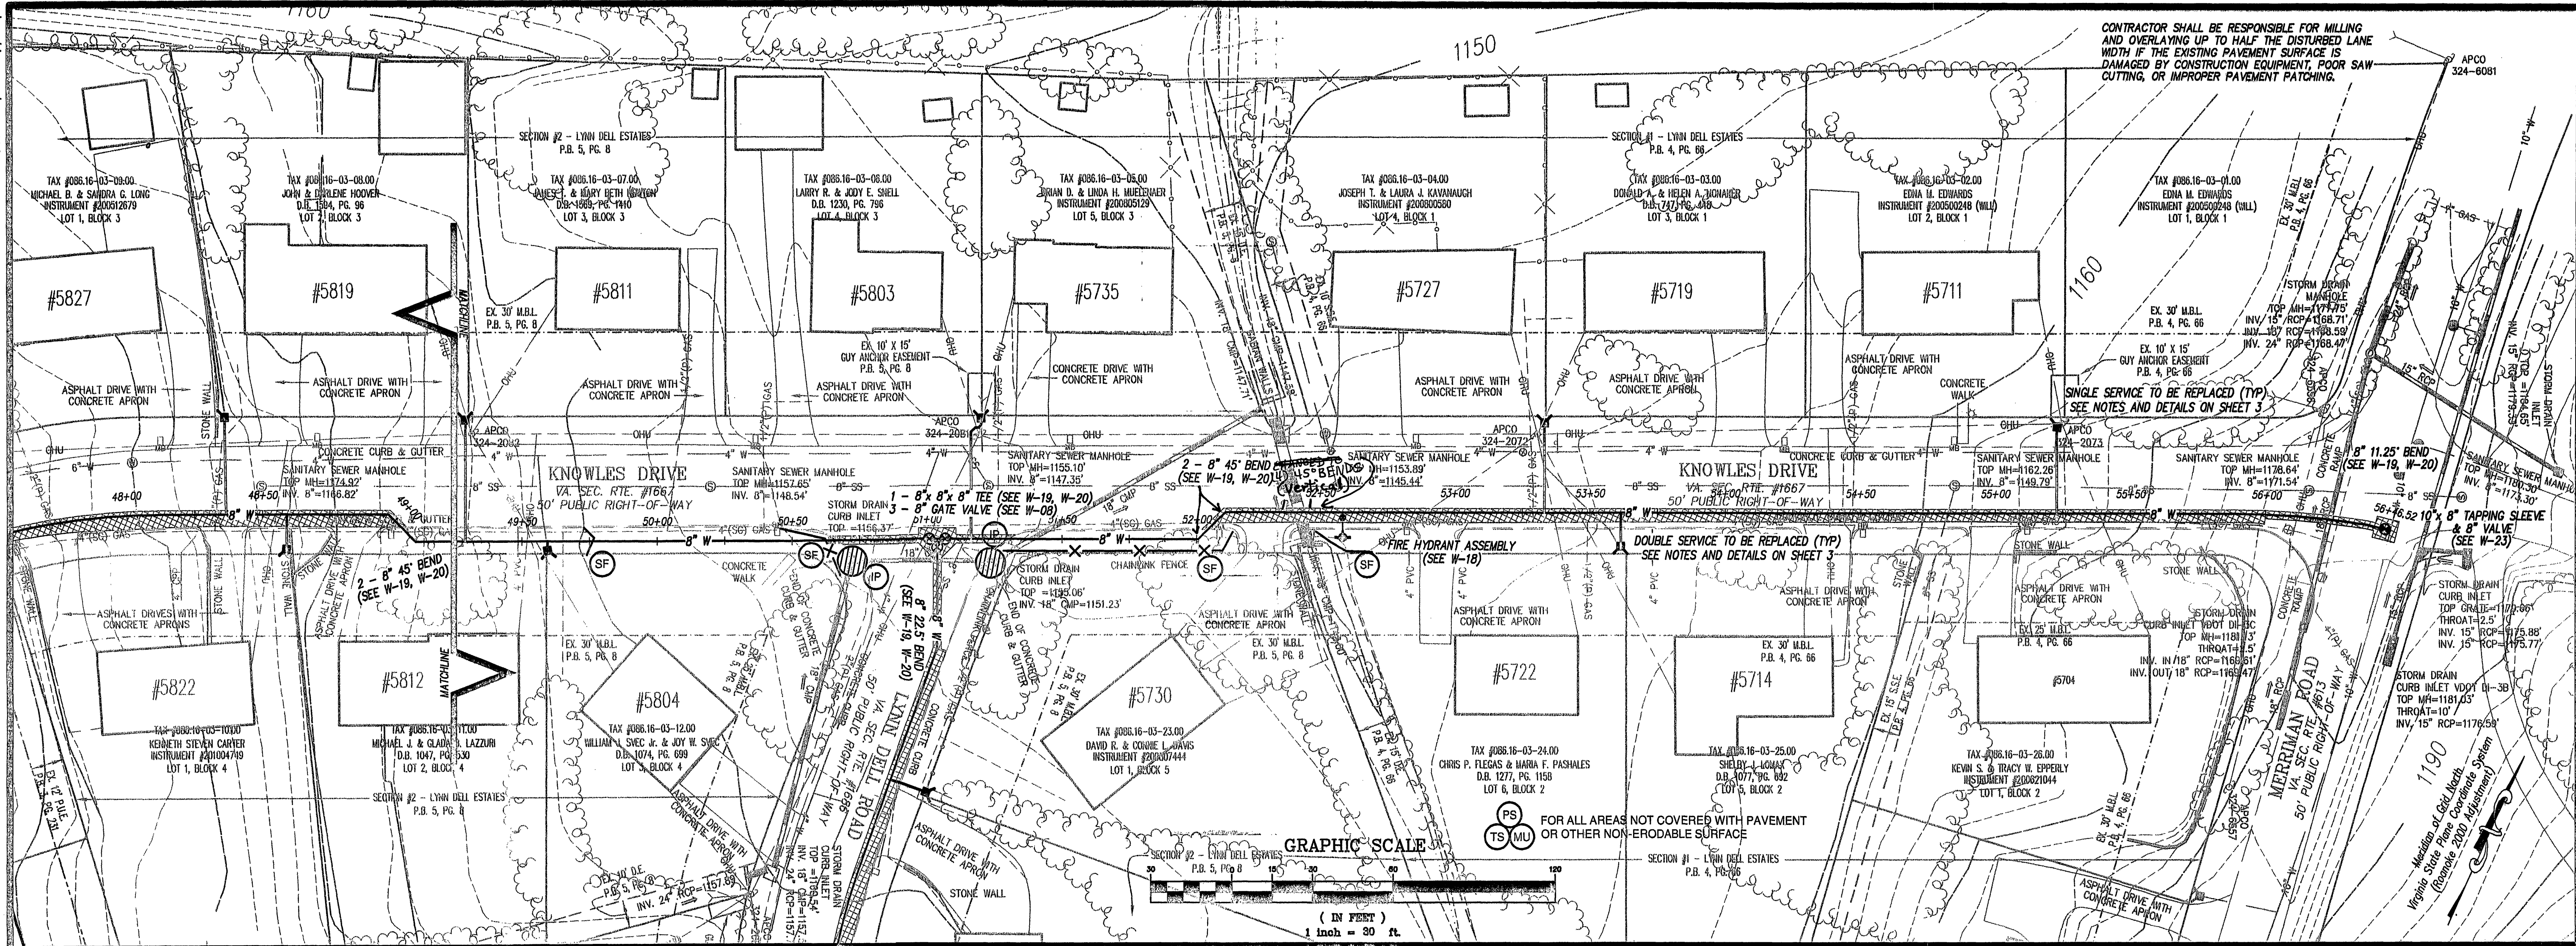

LUMSDEN ASSOCIATES, P.C.
ENGINEERS-SURVEYORS-PLANNERS
ROANOKE, VIRGINIA

DOUGLAS E. BURTON
Professional Engineer
No. 033740
4-26-11

PLAN AND PROFILE
KNOWLES DRIVE

ARLINGTON HILLS
WATERLINE REPLACEMENTS
PREPARED FOR
WESTERN VIRGINIA WATER AUTHORITY
CAVE SPRING MAGISTERIAL DISTRICT
ROANOKE COUNTY, VIRGINIA

NO.	DATE	DESCRIPTION
1		
2		
3		
4		
5		

DATE: April 28, 2011

SCALE: (H) 1" = 30', (V) 1" = 5'

COMMISSION NO: 10-055

SHEET 9 OF 13