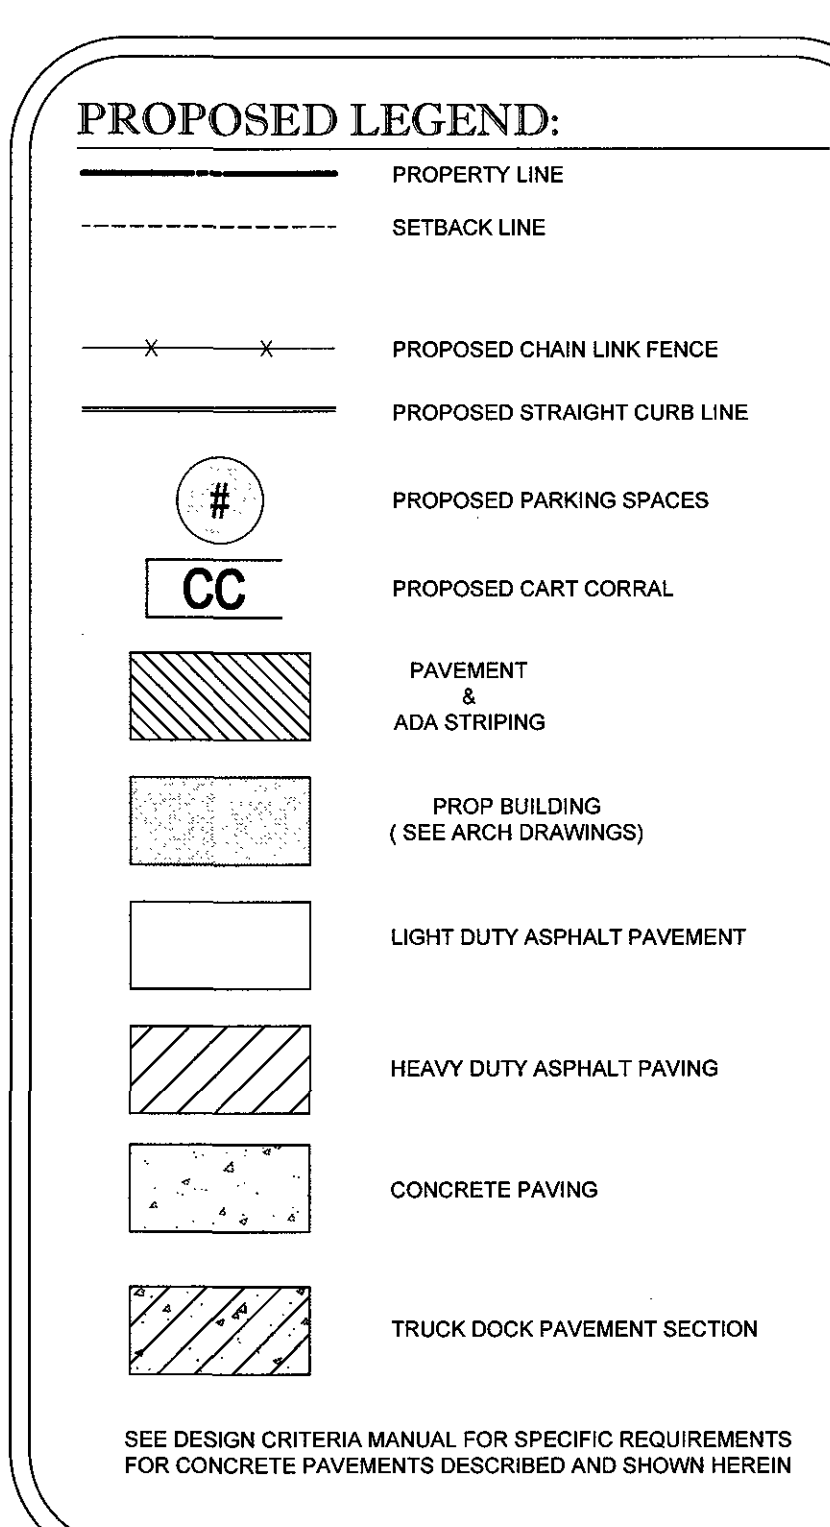
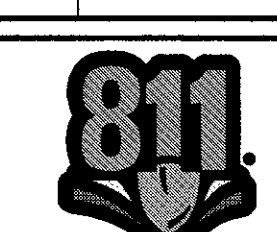


[illegible][illegible]

**KNOW WHAT'S BELOW
ALWAYS CALL 811
BEFORE YOU DIG**

It's fast. It's free. It's the law.

NOT APPROVED FOR
CONSTRUCTION

PROJECT No.:	V172047
DRAWN BY:	DSH
CHECKED BY:	JCW
DATE:	9/12/17
SCALE:	1" = 40'
CAD I.D.:	SP1

PROJECT:
**COMPREHENSIVE
DEVELOPMENT
PLAN**

FOR

BJ's
WHOLESALE CLUB

LOCATION OF SITE
1419 HERSHBERGER ROAD
CITY OF ROANOKE, VIRGINIA

 **BOHLERTM**
ENGINEERING

**28 BLACKWELL PARK LANE, SUITE 201
WARRENTON, VIRGINIA 20186**

Phone: (540) 349-4500
Fax: (540) 349-0321
VA@BohlerEng.com

COMMONWEALTH OF VIRGINIA
John C. Wright
 JOHN C. WRIGHT
 Lic. No. 046960
 10/25/17
 PROFESSIONAL ENGINEER

SHEET TITLE:	
SITE PLAN	
SHEET NUMBER:	
C-302	