


PROFILE	BY	DATE
SURVEYED		
PLOTTED		
GRAPHS CHECKED		
B. M.'S. NOTED		

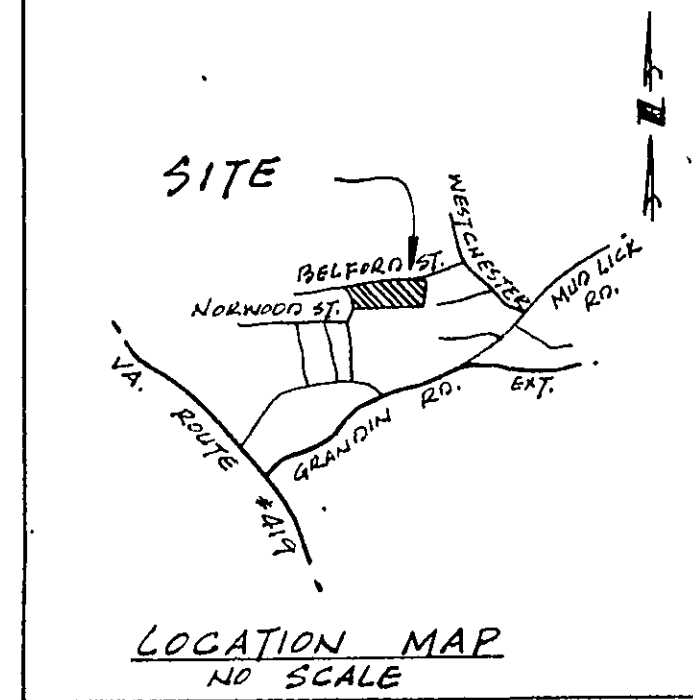

APPROVED: Richard B. Bunn 7 MAR '83
CITY ENGINEER, ROANOKE, VIRGINIA DATE


Shirley J. Higginbotham 7 MAR '83
AGENT ROANOKE CITY PLANNING COMMISSION DATE

NOTE:
SANITARY SEWER INSTALLATION SHALL BE IN ACCORDANCE WITH THE
CITY OF ROANOKE STANDARDS AND SPECIFICATIONS.

USE P.V.C. SDR-35 PIPE.

AS BUILT

PLAN
1" = 50'

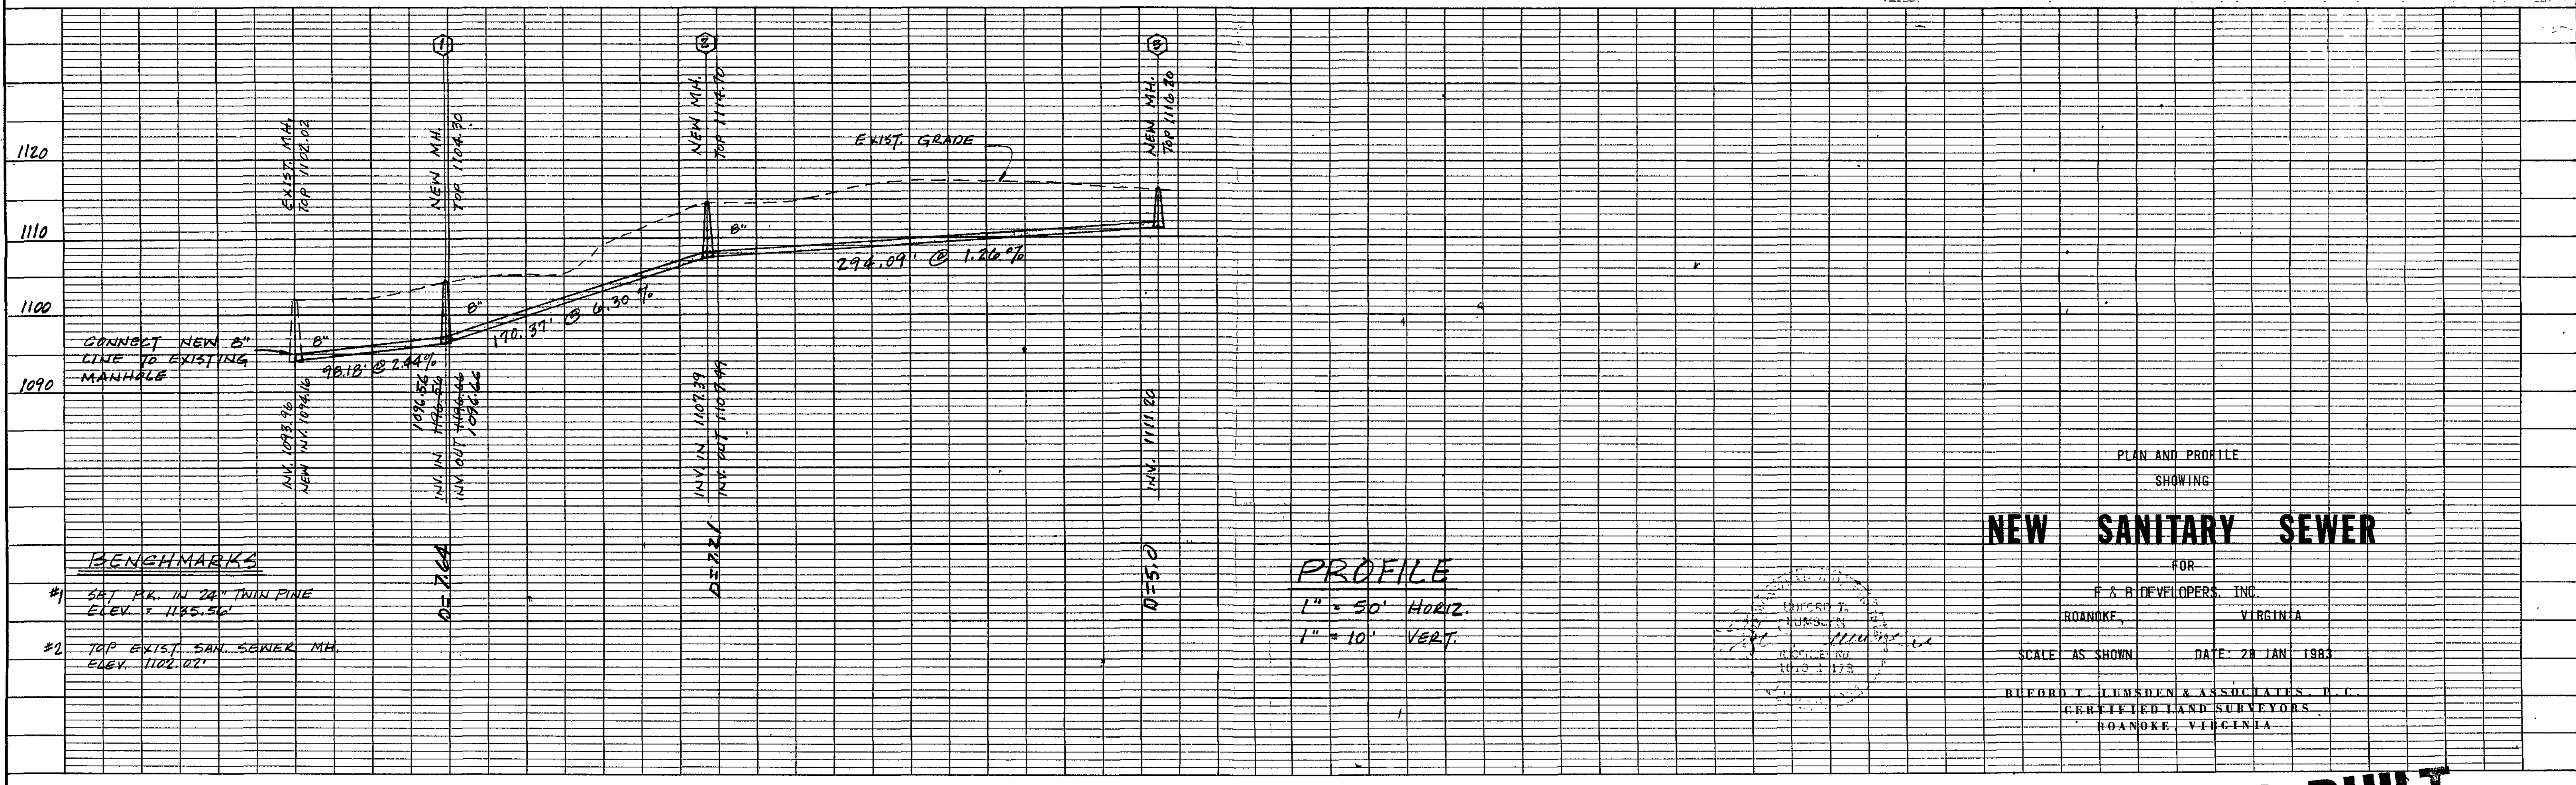

PLAN AND PROFILE
SHOWING
NEW SANITARY SEWER
FOR
F & B DEVELOPERS, INC.
ROANOKE, VIRGINIA
SCALE AS SHOWN DATE: 28 JAN 1983
RUFORD T. LUMSHEN & ASSOCIATES, P. C.
CERTIFIED LAND SURVEYORS
ROANOKE, VIRGINIA

AS BUILT

COMM. No. B2-234

BELFORD ST. & S.W.