


BERKLEY ROAD SANITARY SEWER REPLACEMENT WESTERN VIRGINIA WATER AUTHORITY

ROANOKE, VIRGINIA
APR. 5, 2021
COMM. NO. 3941


SHEET LIST


- 1 TITLE SHEET
- 2 GENERAL NOTES & LEGEND
- 3 PLAN AND PROFILE - 18" SANITARY SEWER
- 4 PLAN AND PROFILE - 18" SANITARY SEWER
- 5 PLAN AND PROFILE - 18" SANITARY SEWER
- 6 PLAN AND PROFILE - 18" SANITARY SEWER
- 7 DETAILS
- 8 DETAILS
- 9 EROSION & SEDIMENT CONTROL
- 10 TEMPORARY TRAFFIC CONTROL

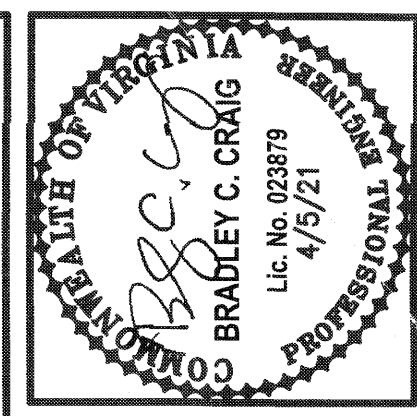

Revisions	Date

Issue Date: APR. 5, 2021	Drawn By: RPK/MLC Designed By: RPK Checked By: SCC Date: 4/5/21
------------------------------------	--

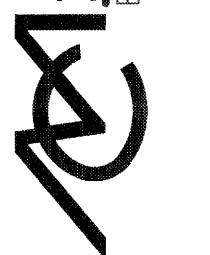
**Mattern & Craig**
ENGINEERS/SURVEYORS
701 FIRST STREET, S.W.
ROANOKE, VIRGINIA 24016
(540) 345-9342
FAX (540) 345-7891

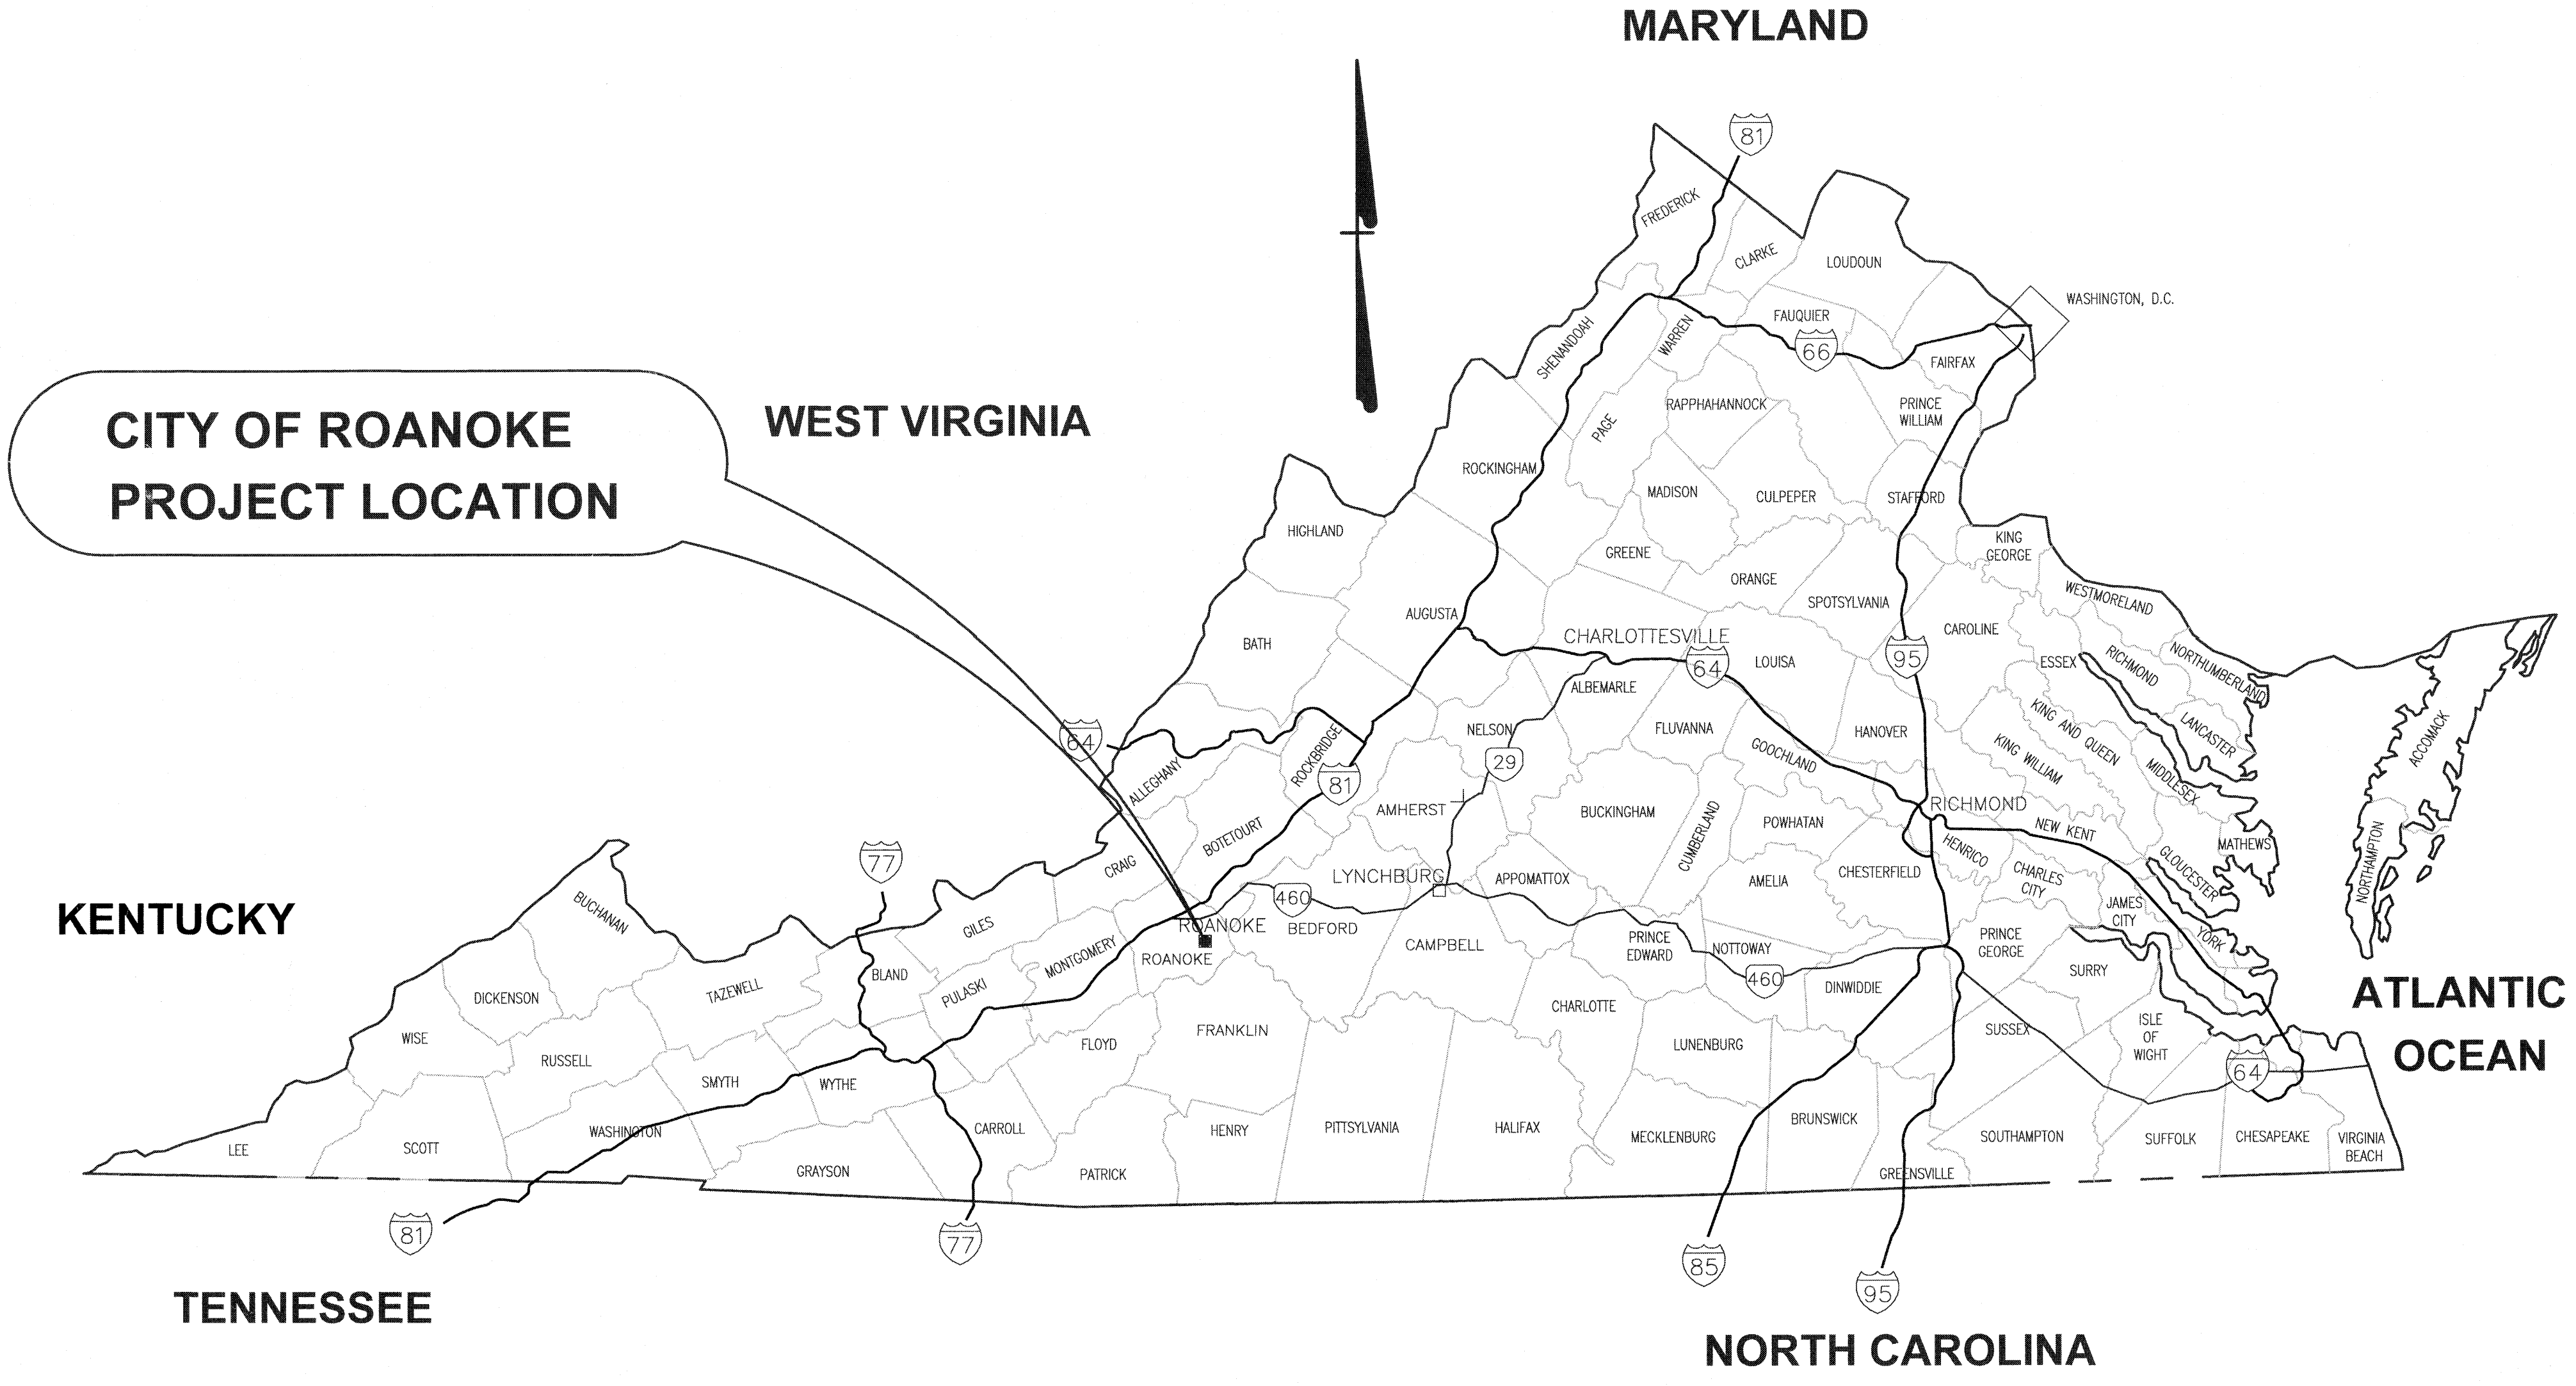

PREPARED FOR



APPROVED FOR CONSTRUCTION

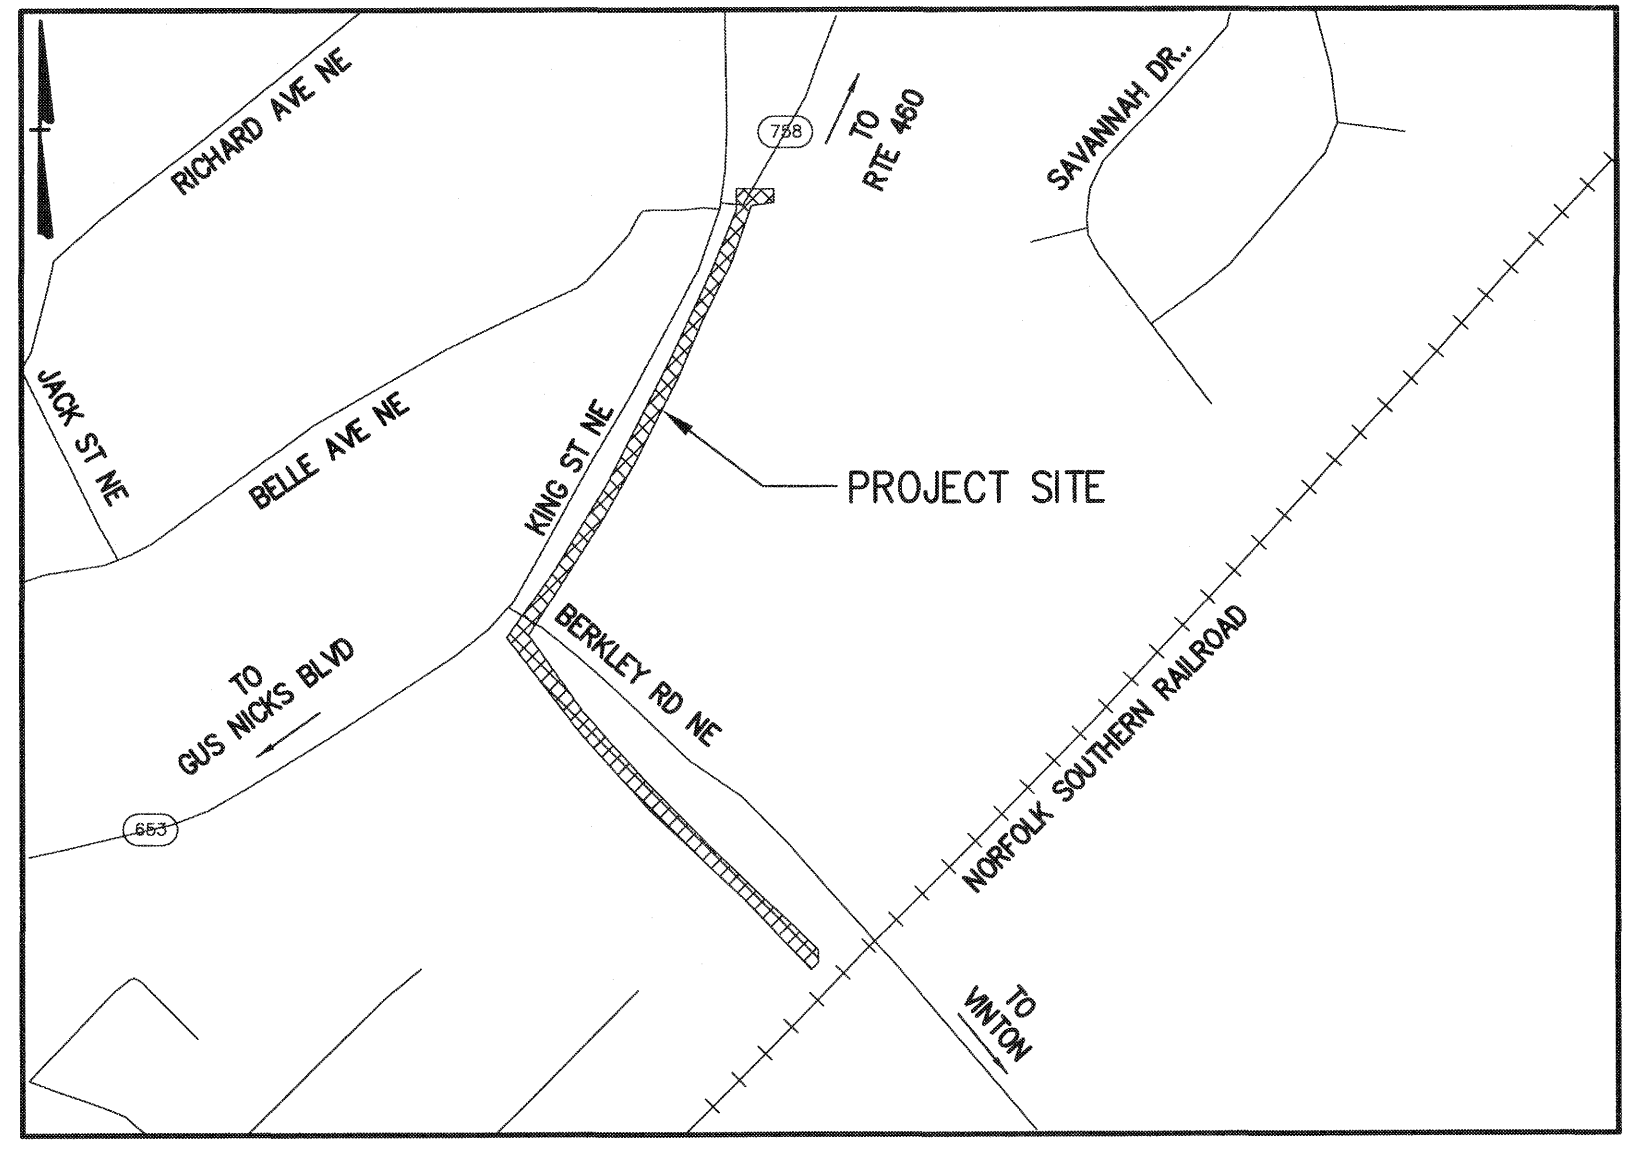

LOCATION MAP
NOT TO SCALE

BERKLEY ROAD SANITARY SEWER REPLACEMENT
TITLE SHEET
ROANOKE, VIRGINIA

Vertical Scale:	N/A
Horizontal Scale:	N/A
Commission Number:	3941
Sheet No.:	1