
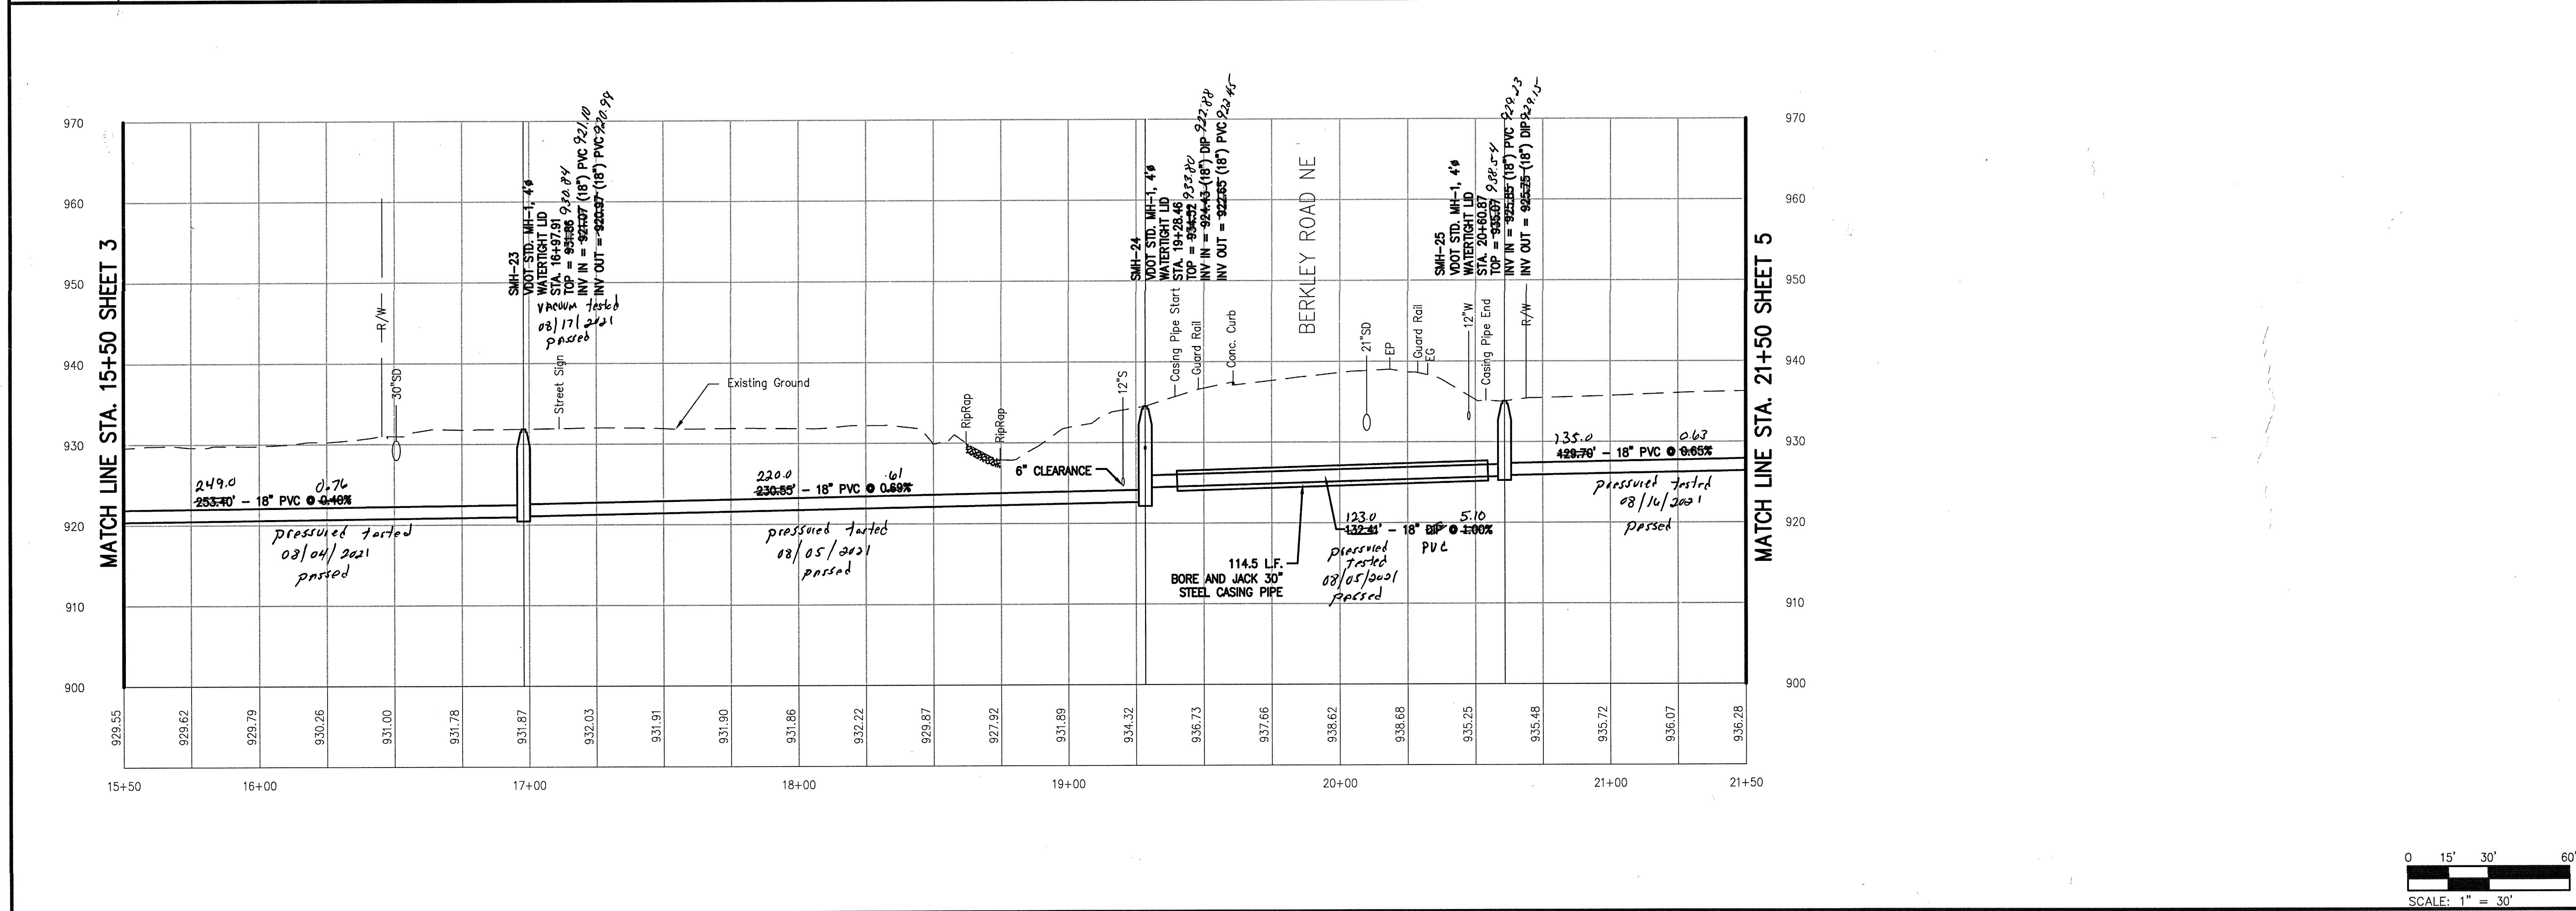


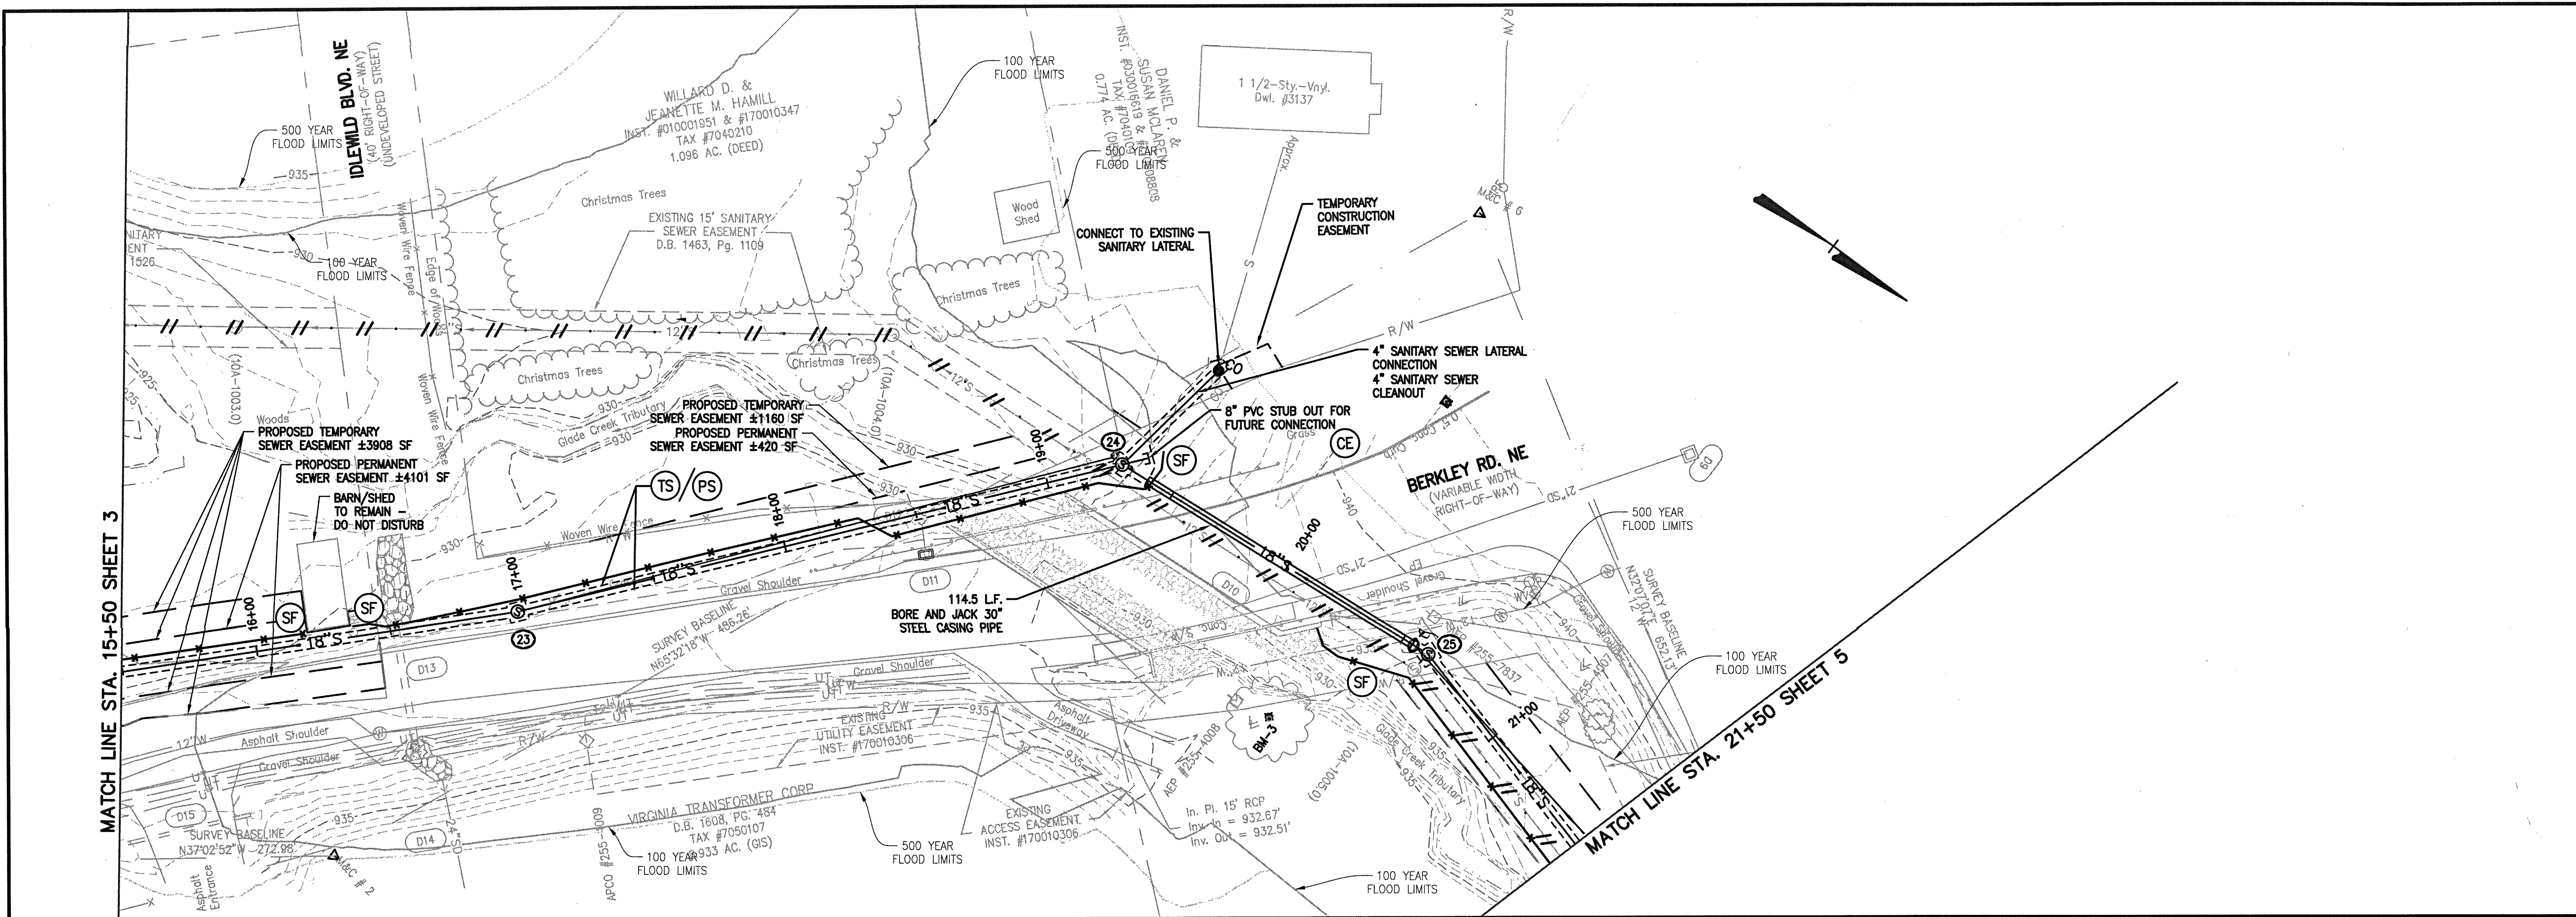

Revisions	Date

Issue Date: **APR. 5, 2021**

Drawn By: RPK/MLC

Designed By: RPK

Checked By: BCC

Date: 4/5/21

Mattern & Craig
ENGINEERS/SURVEYORS

701 FIRST STREET, S.W.
ROANOKE, VIRGINIA 24016
(540) 345-9342
FAX (540) 345-7891

BERKLEY ROAD SANITARY SEWER REPLACEMENT

PLAN AND PROFILE -

18" SANITARY SEWER

ROANOKE, VIRGINIA

Vertical Scale:
1"=10'

Horizontal Scale:
1"=30'

Commission Number:
3941

Sheet No.:
4

741 - WVWA - Berkley Road Sewer\DWG\3941 Design.dwg, 4/5/2021 10:18:14 AM, DWG To PDF(no layers) Lines Overwrite.pc3