




MATCH LINE STA. 21+50 SHEET 4

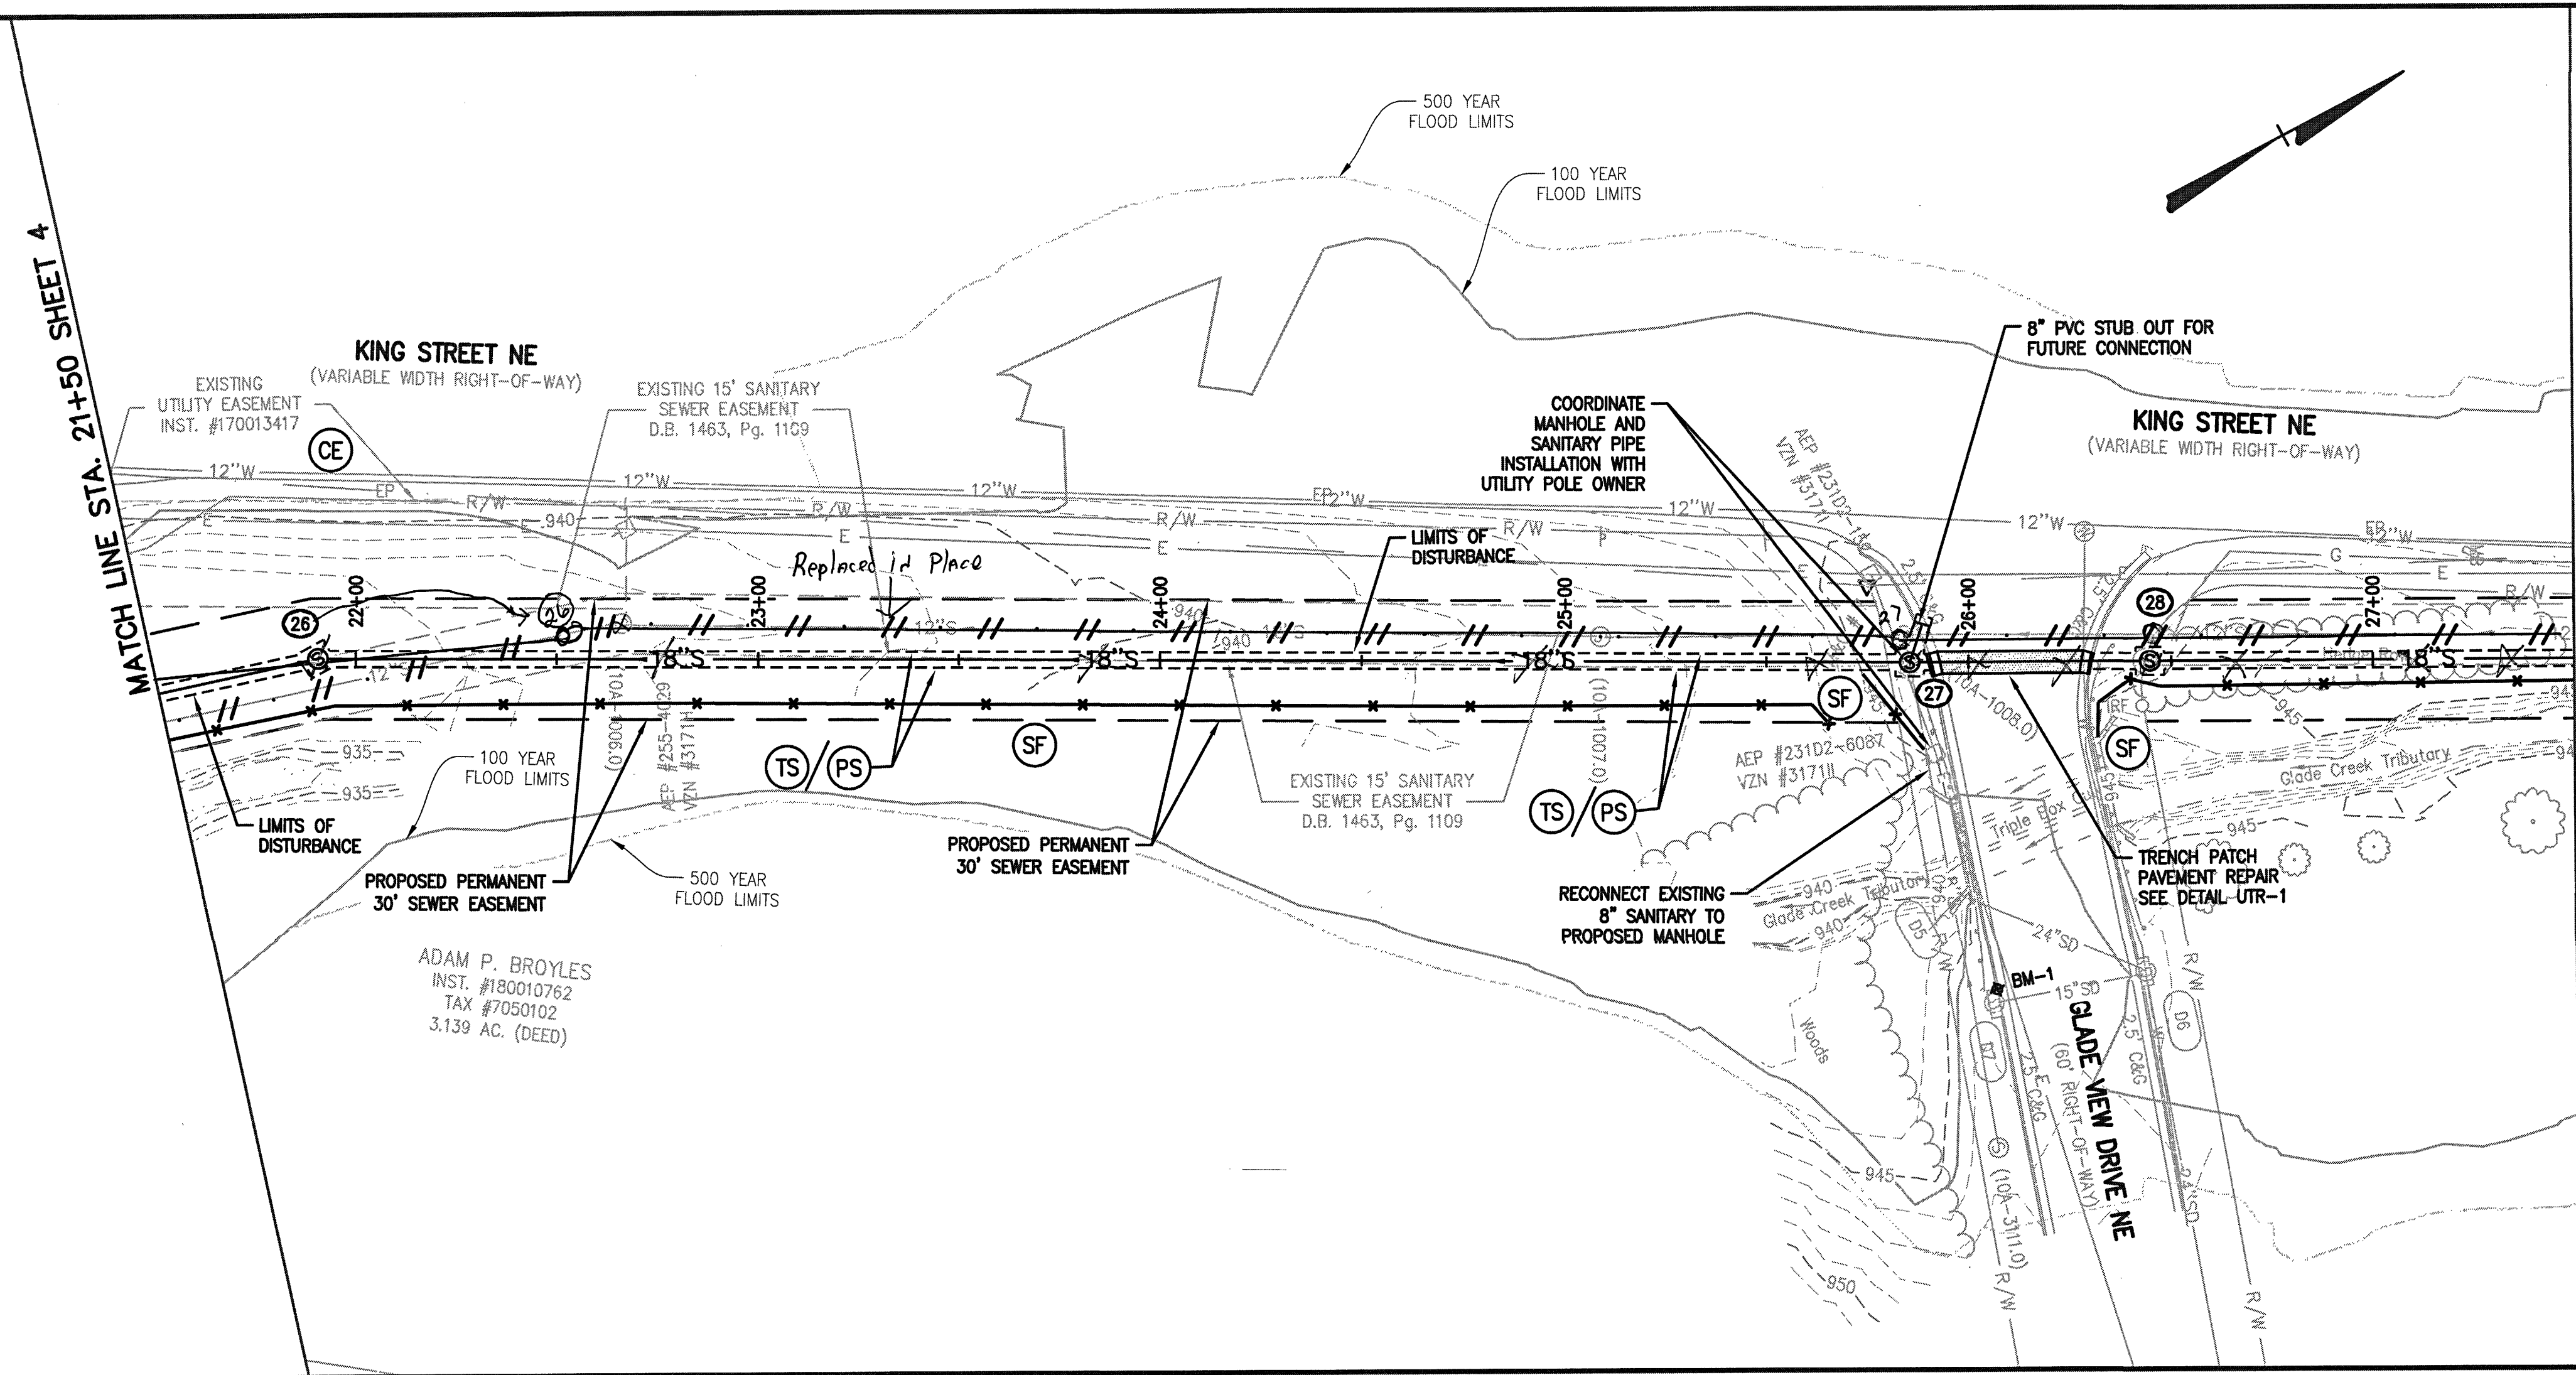

MATCH LINE STA. 27+50 SHEET 6

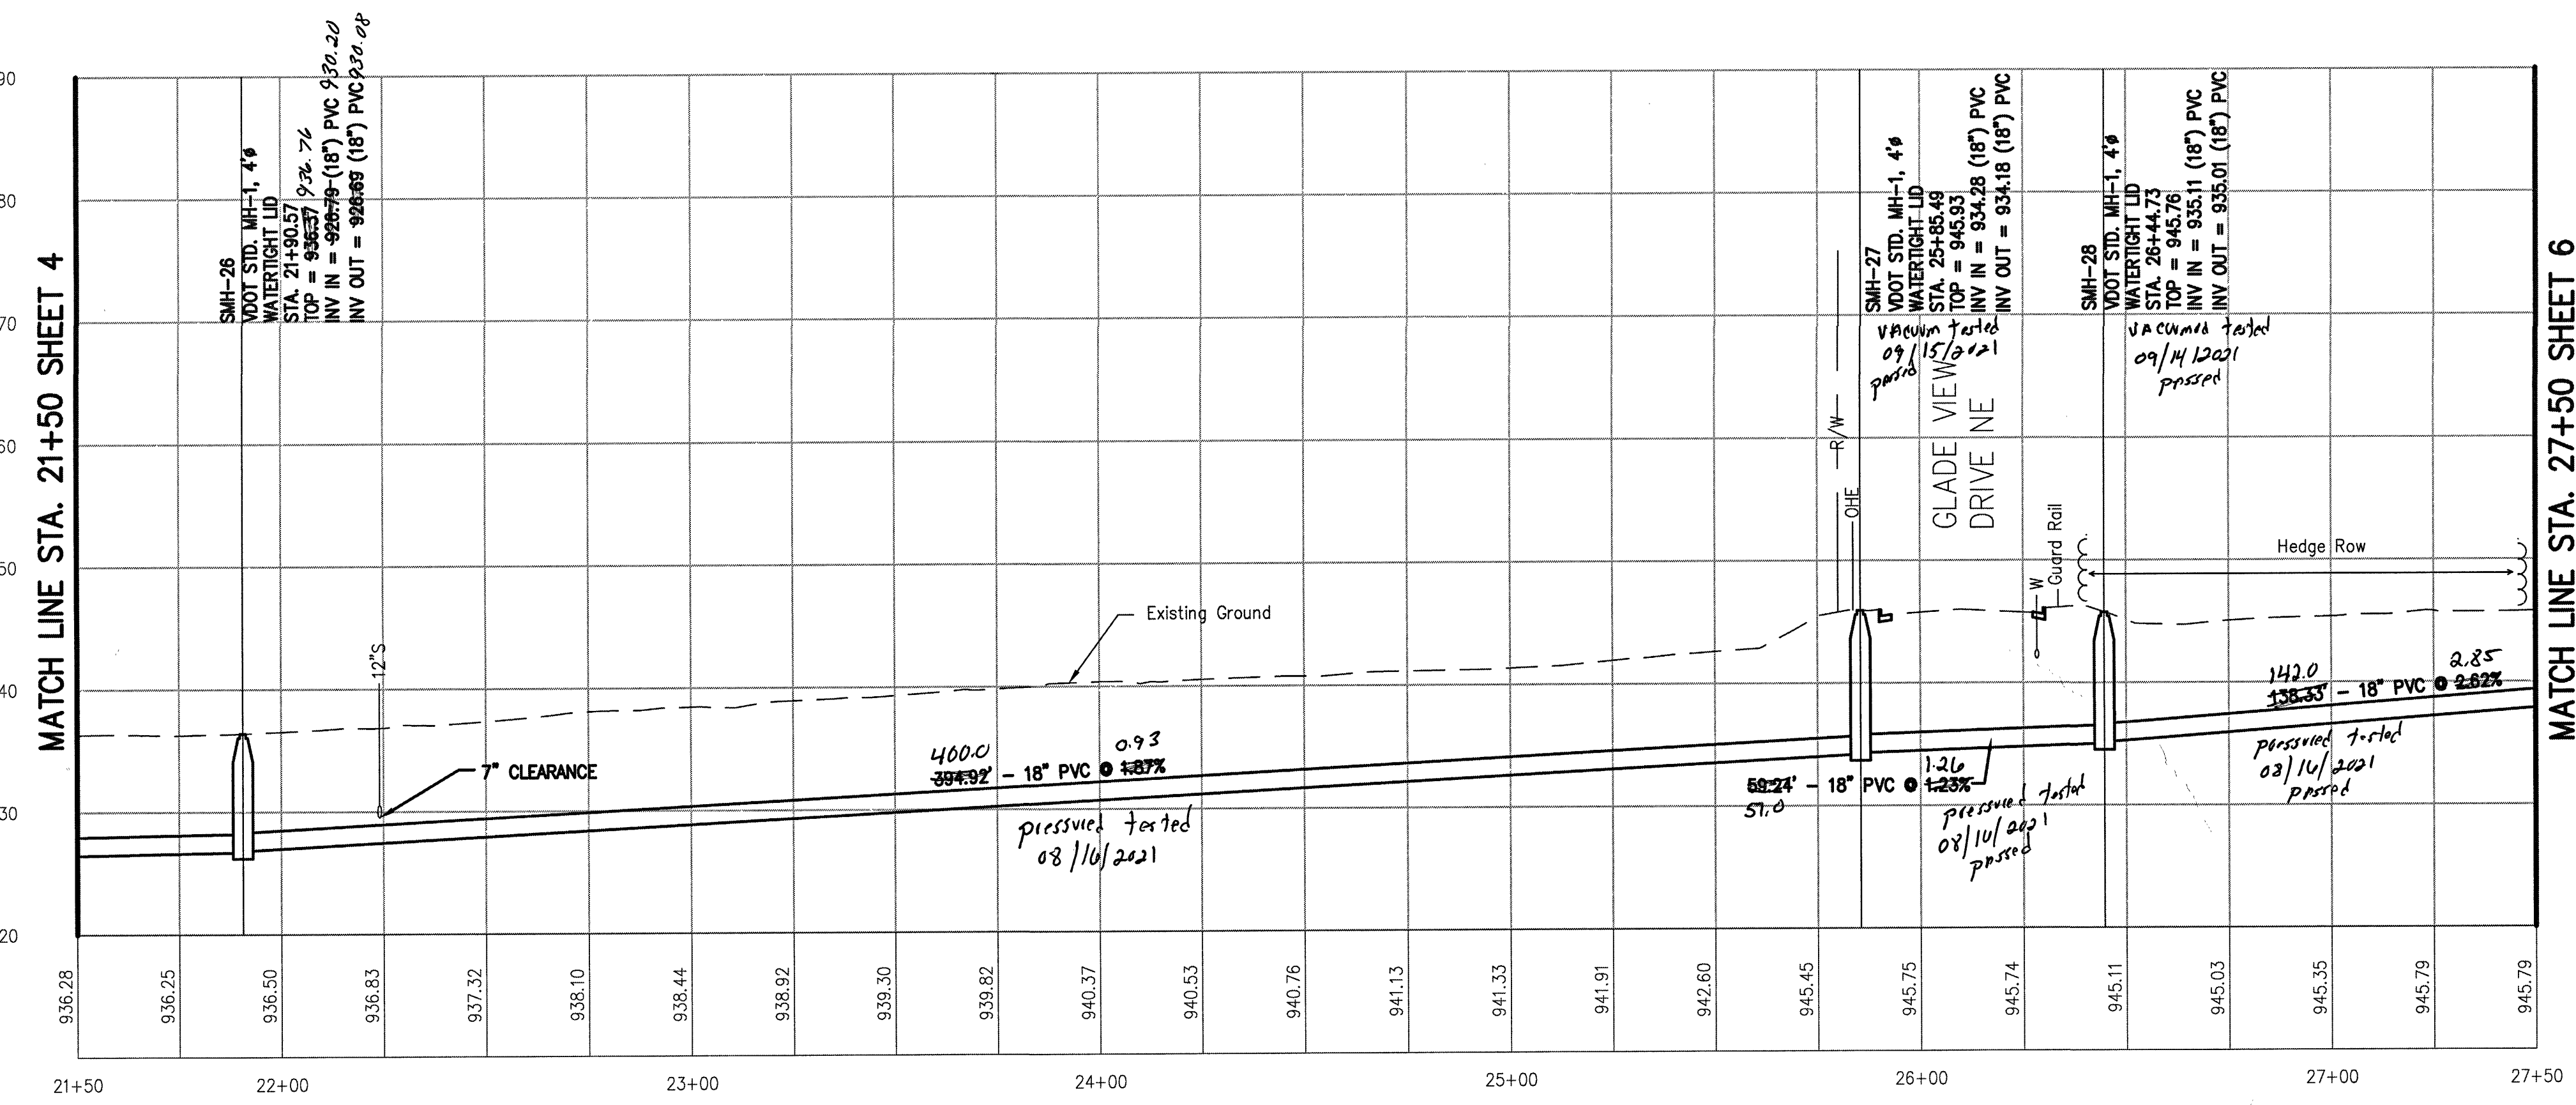

MATCH LINE STA. 27+50 SHEET 6

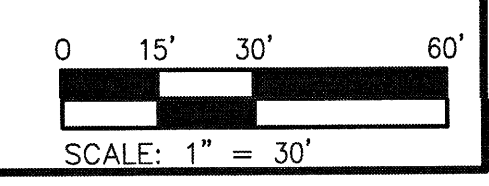

Issue Date:	APR. 5, 2021
Drawn By:	RPK/MJC
Designed By:	RPK
Checked By:	BCC
Date:	4/5/21

Mattern & Craig
ENGINEERS & SURVEYORS
701 FIRST STREET, SW
ROANOKE, VIRGINIA 24016
(800) 345-9342
(540) 345-9342
FAX (540) 345-7691

BERKLEY ROAD SANITARY SEWER REPLACEMENT
PLAN AND PROFILE -
18" SANITARY SEWER
ROANOKE, VIRGINIA

Vertical Scale:
1"=10'

Horizontal Scale:
1"=30'

Commission Number:
3941

Sheet No.:
5