



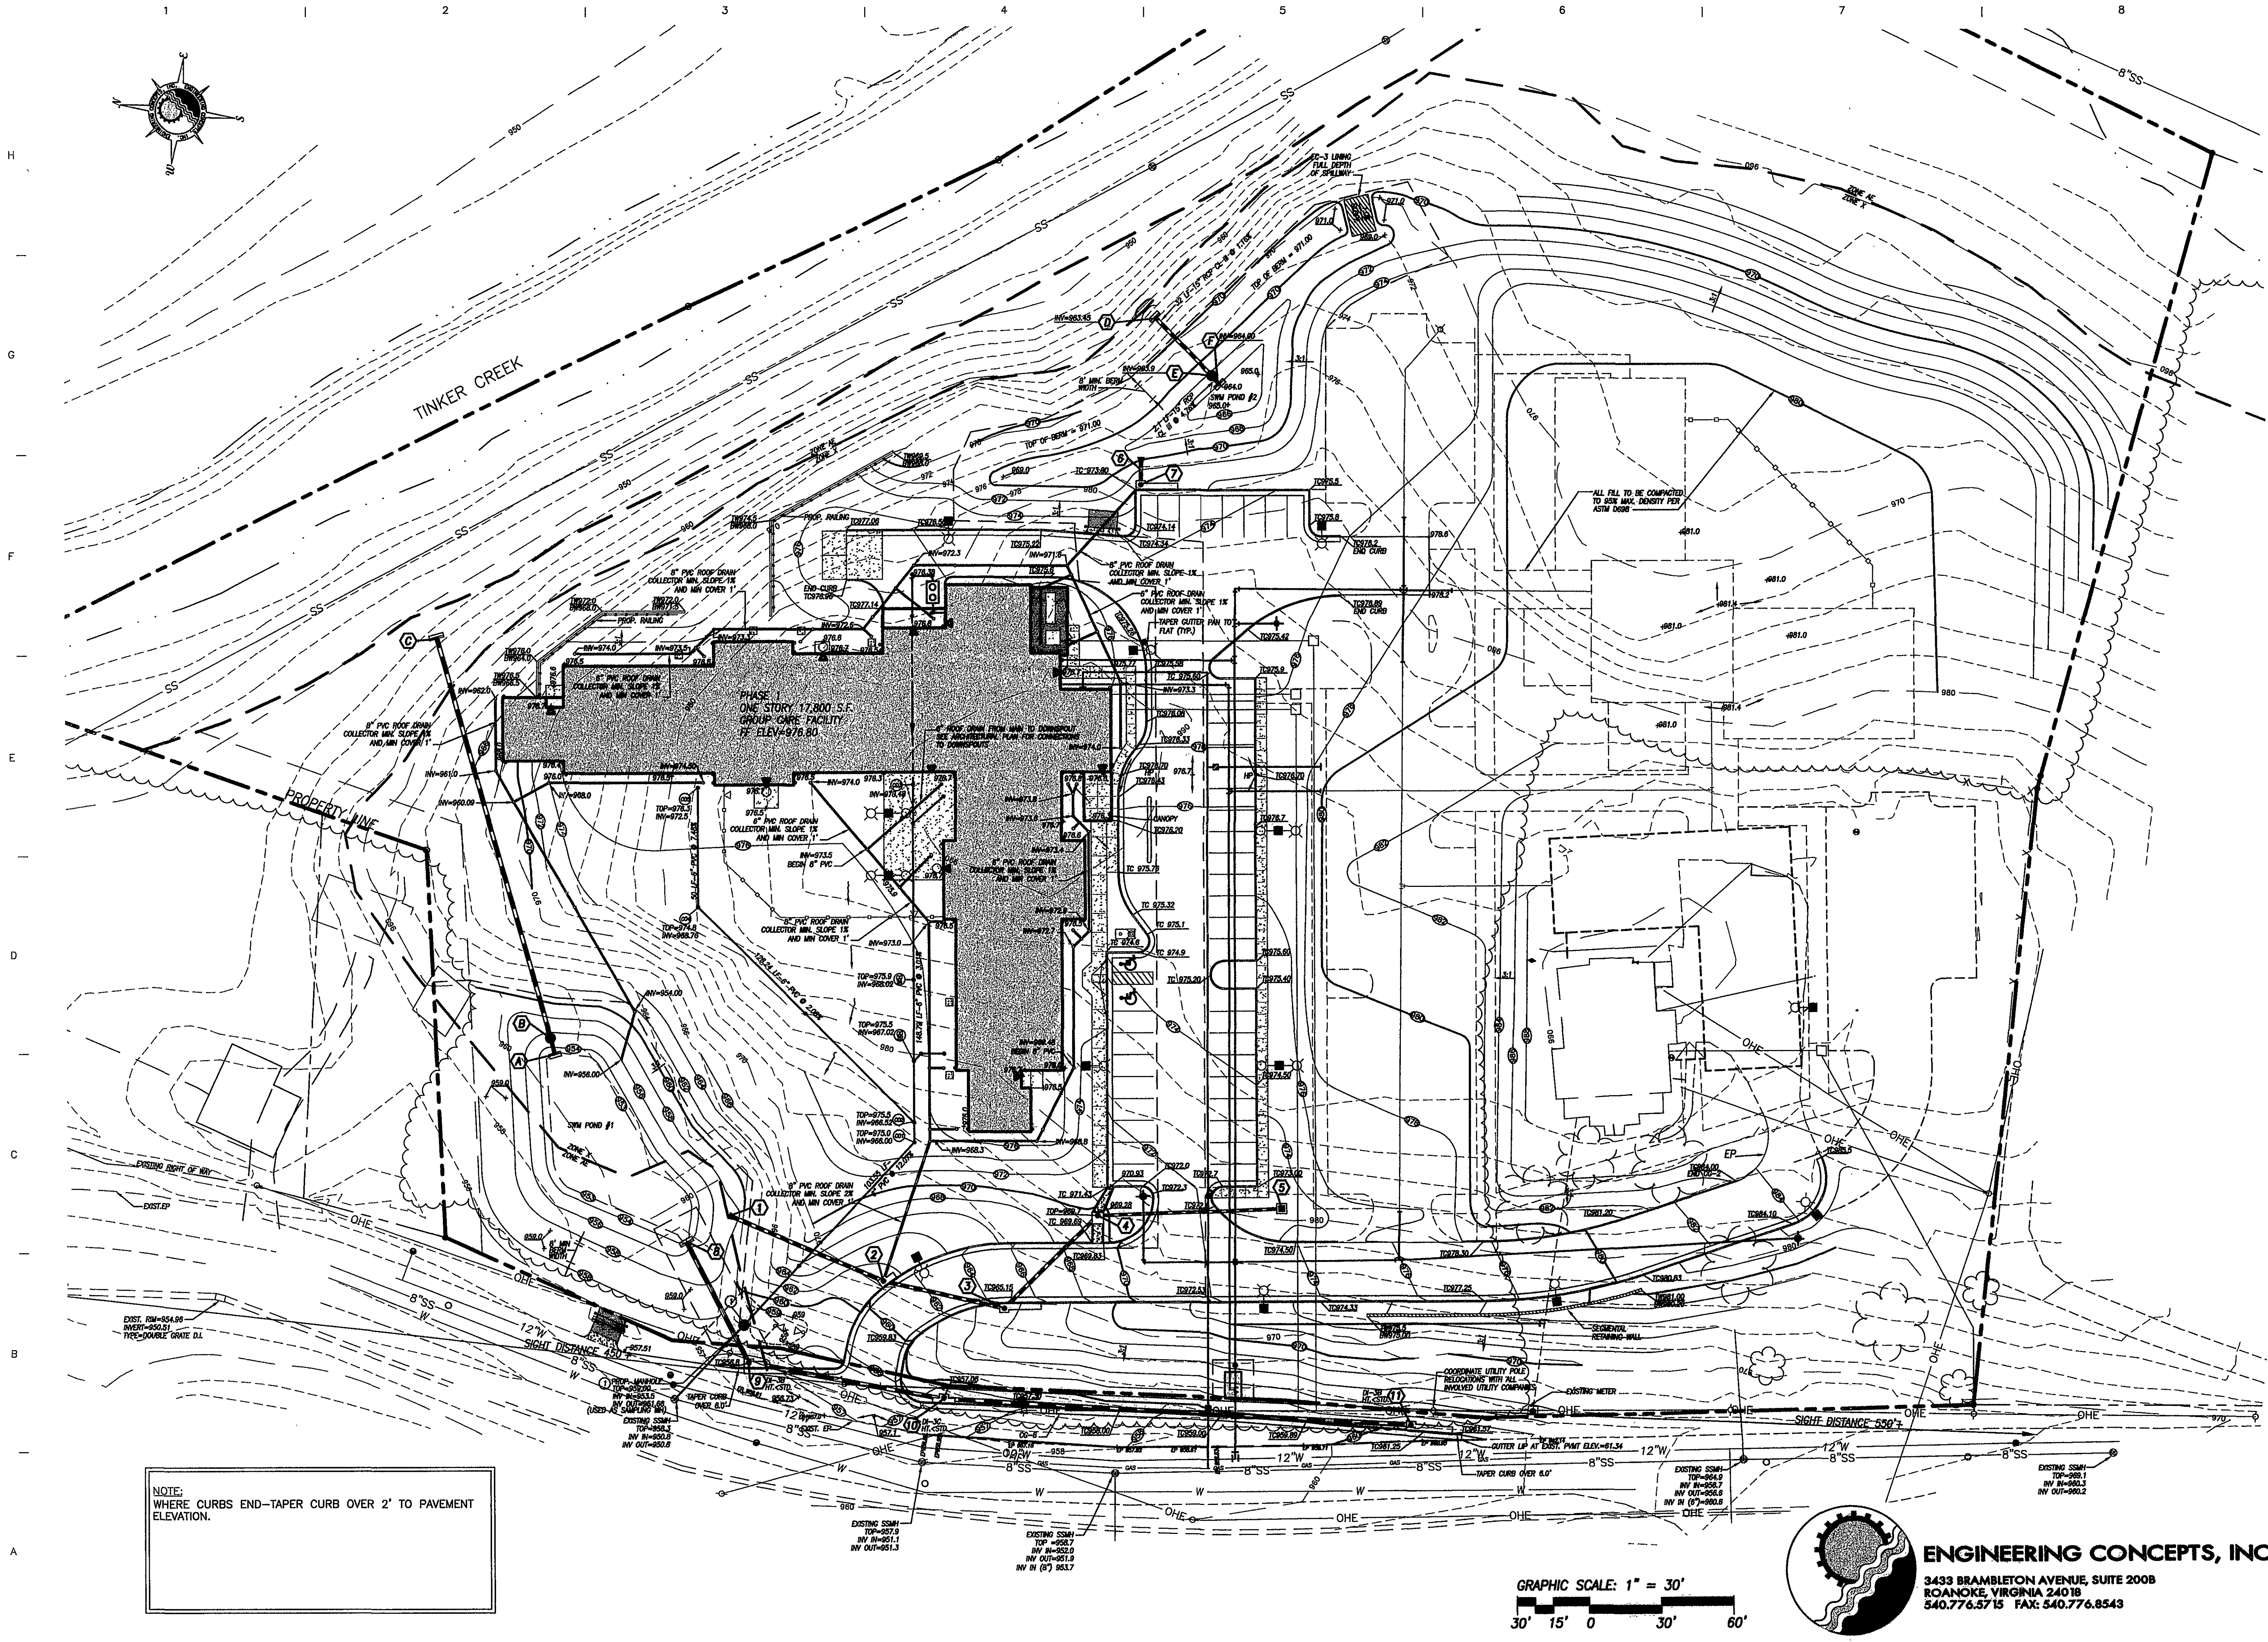

date	project	designed	drawn	checked	revisions
May 30, 2007	08/22/00	JDE	DRB	JDE	
					1
					2
					3
					10.04.07
					09.06.07
					07.30.07
					06.04.07
					05.26.07
					04.08.07
					03.06.07
					02.04.07
					01.04.07
					01.04.07

RODRIGUEZ
RIPLEY
MADDUX
MOTLEY
ARCHITECTS

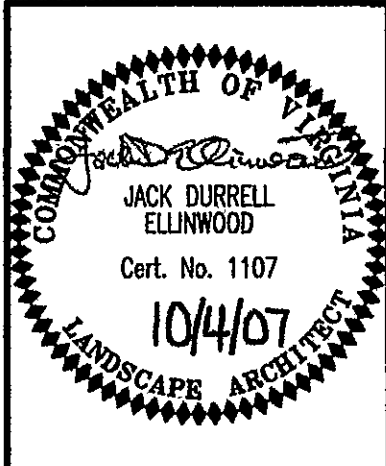

BRBH - HOLLINS ROAD PROJECT
OVERALL GRADING PLAN
sheet 6

C1.04

ENGINEERING CONCEPTS, INC.
3433 BRAMBLETON AVENUE, SUITE 200B
ROANOKE, VIRGINIA 24018
540.776.5715 FAX: 540.776.8543