




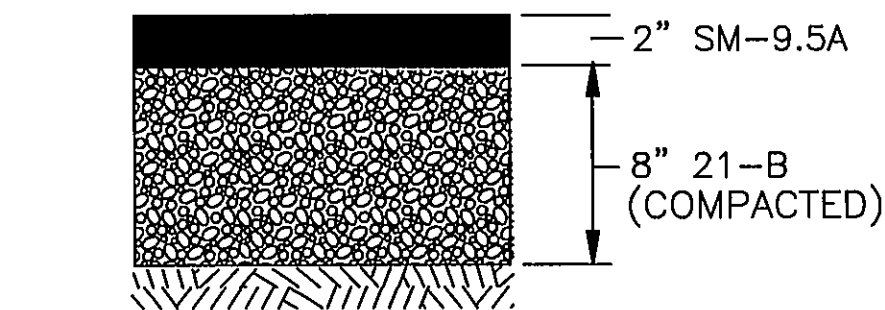





STD PAVEMENT SECTION
NO SCALE

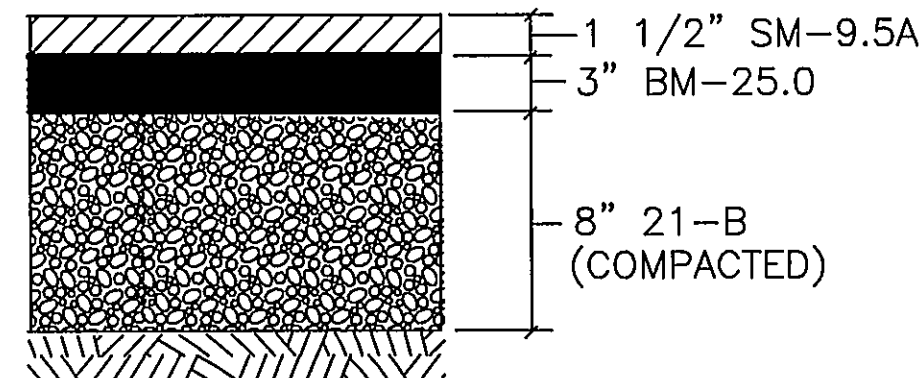


HEAVY DUTY/ROADWAY PAVEMENT SECTION
NO SCALE

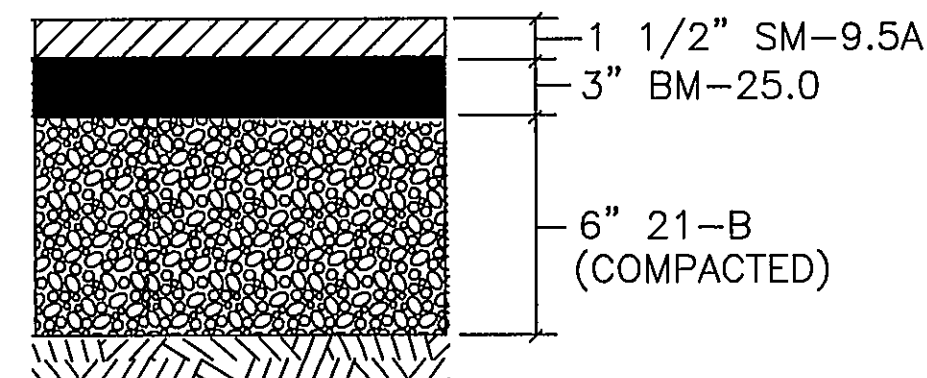


ROUTE 117 PAVEMENT SECTION
NO SCALE
NOTE: MATCH MAINLINE PAVEMENT STRUCTURE IF GREATER

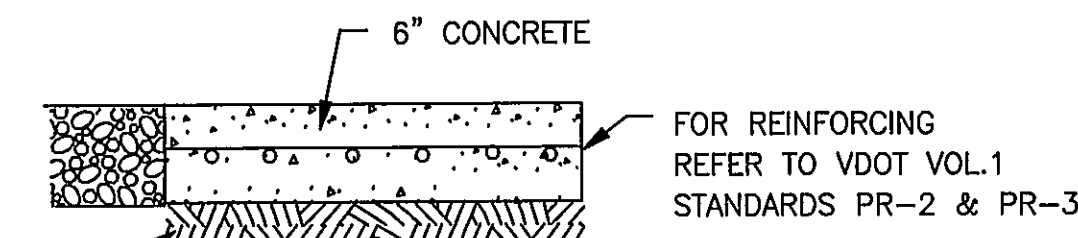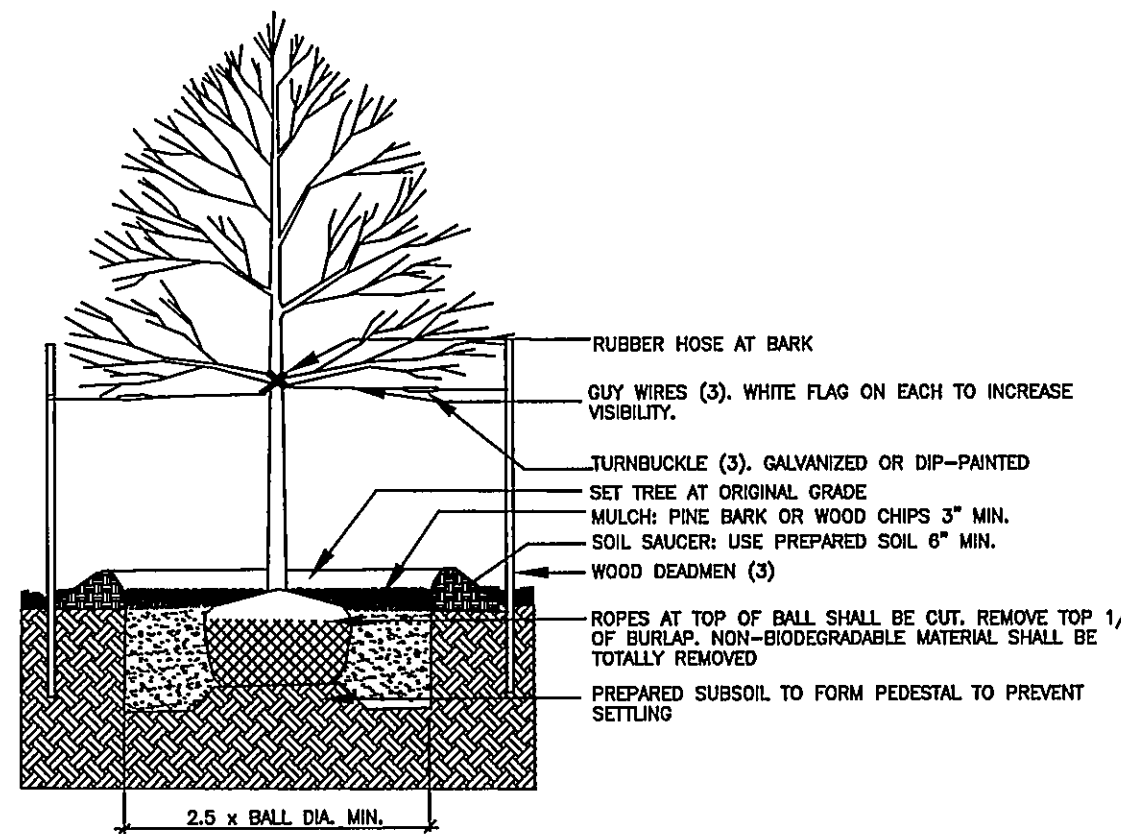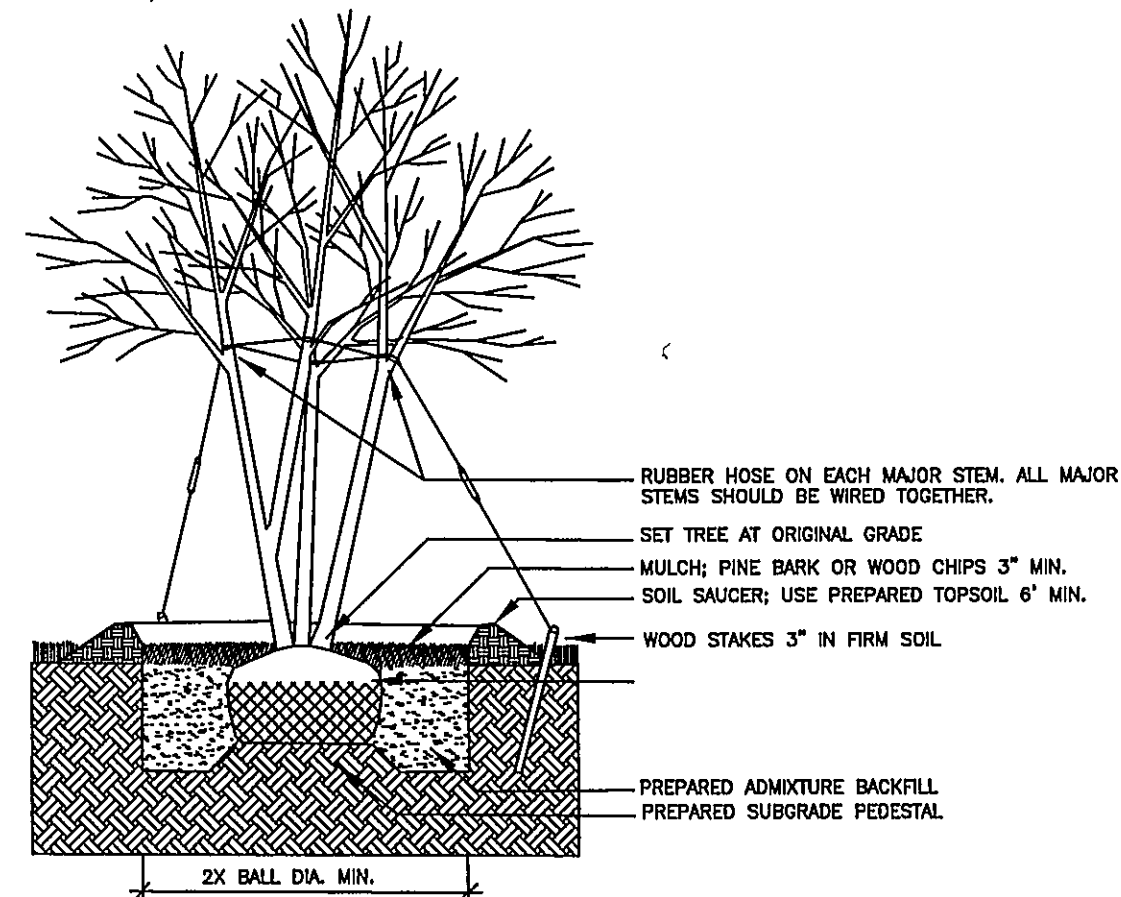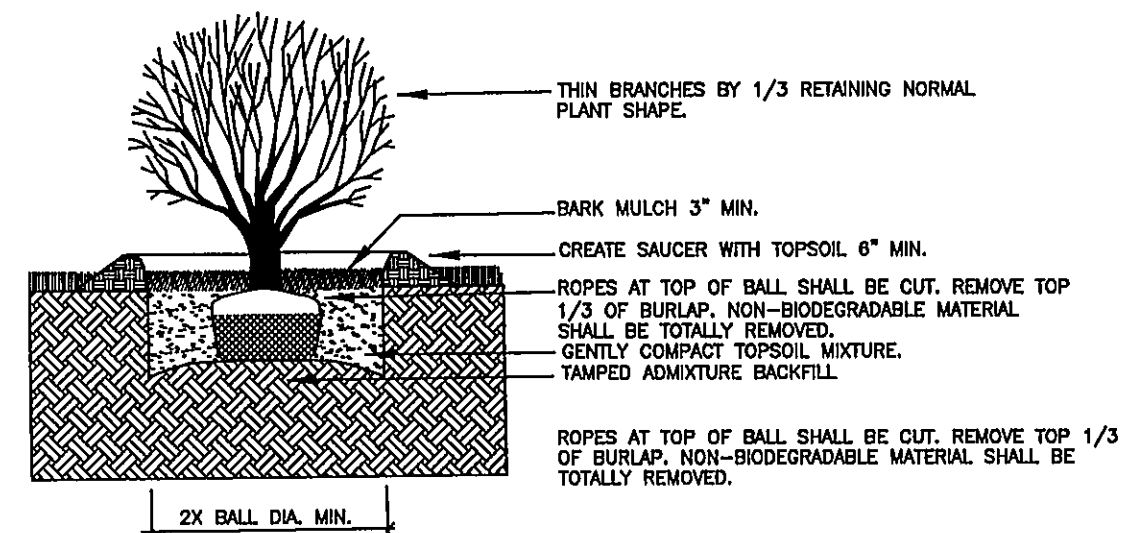


SECTION THROUGH DUMPSTER PAD
NO SCALE

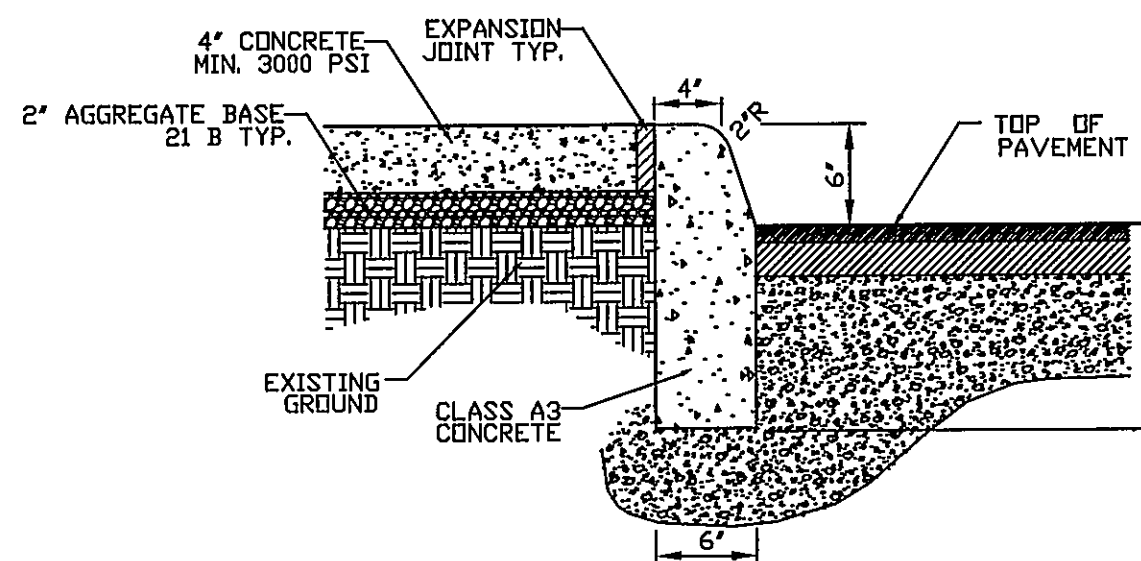

TYPICAL SIDEWALK DETAIL
NO SCALE


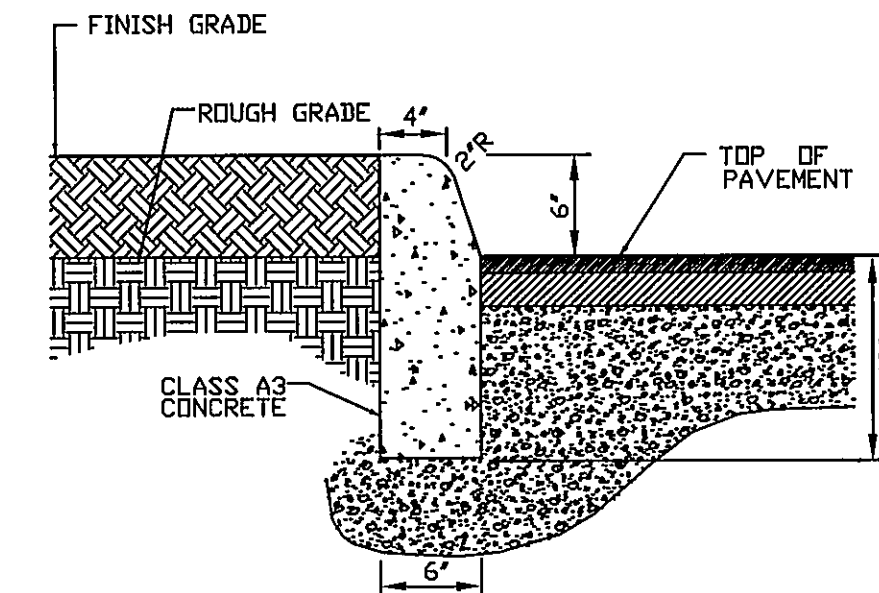


CG-2 DETAIL
N.T.S.

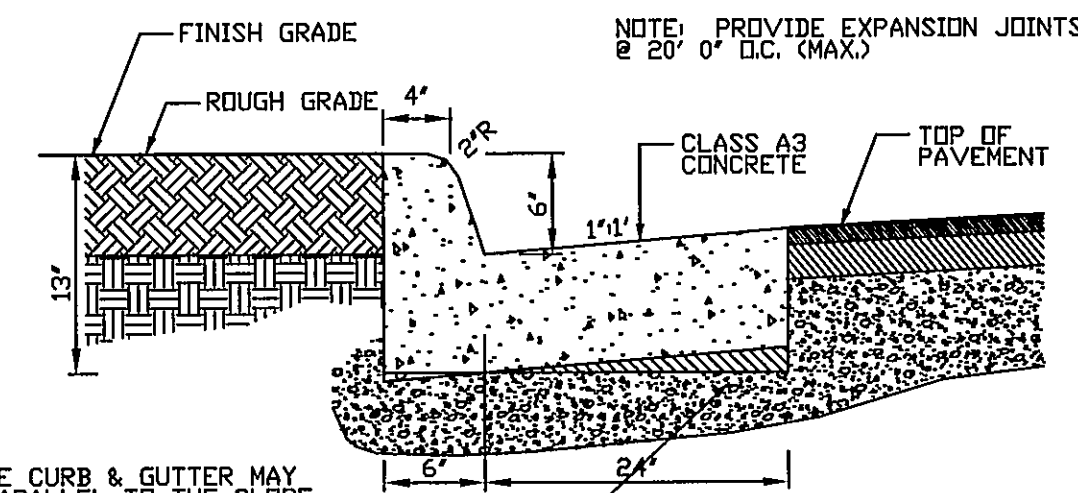




CG-6 (WET) DETAIL
N.T.S.

GREASE INTERCEPTOR DESIGN

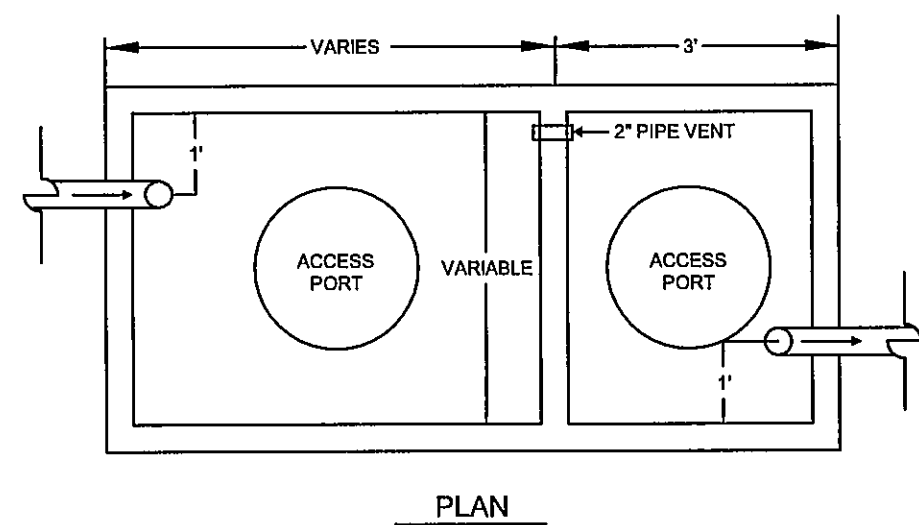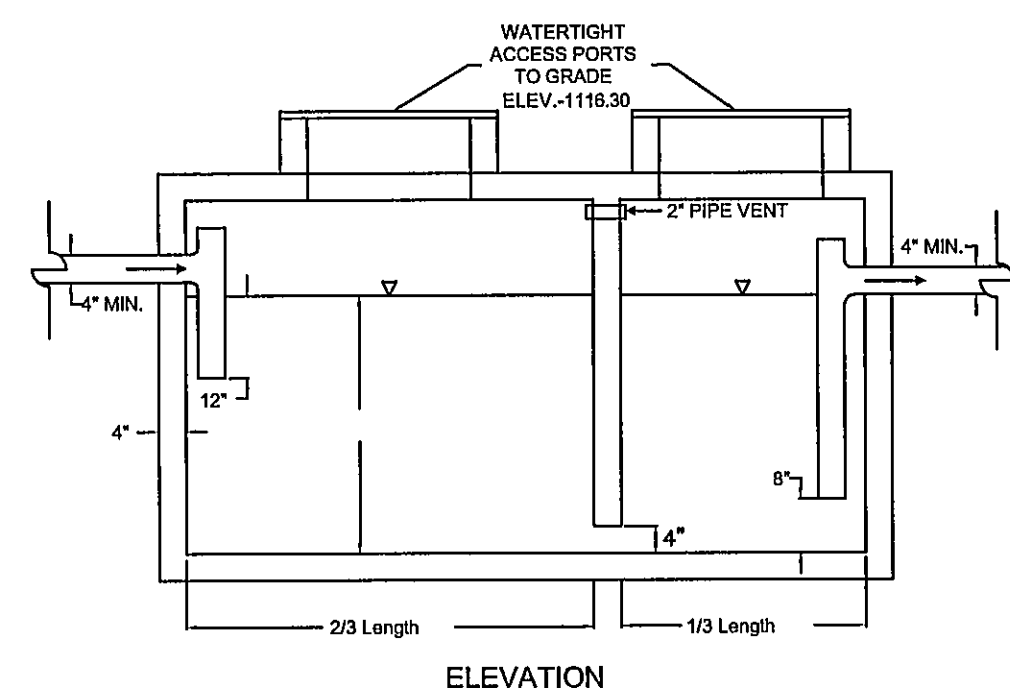


NOTES:


1. MINIMUM RETENTION TIME SHOULD BE 30 MINUTES AT PEAK FLOW
2. GREASE TRAP SHOULD BE DESIGNED TO WITHSTAND TRAFFIC LOADS.
3. THE GREASE TRAP SIZE SHALL BE 1,500 GALLONS
4. SEE PLUMBING PLANS FOR EXACT BLDG. CONNECTION DETAILS AND GREASE TRAP DESIGN CALCULATIONS
5. GREASE INTERCEPTOR SHALL BE INSPECTED AND APPROVED BY WESTERN VIRGINIA WATER AUTHORITY PRIOR TO SITE RECEIVING WATER SERVICE CONNECTION.
6. FORTY-EIGHT(48) HOURS PRIOR TO INSTALLATION, THE CONTRACTOR SHALL COMPLETE THE FOLLOWING:
 - a. SUBMIT SHOP DRAWINGS TO CASSIE ALTICE 601 S. JEFFERSON STREET ROANOKE, VA 24011
 - b. CALL (540) 853-5698 TO SCHEDULE GREASE INTERCEPTOR INSPECTION
7. A GREASE CONTAINER WILL BE UTILIZED ONSITE AND STORED IN THE DUMPSTER ENCLOSURE. (SEE DUMPSTER DETAIL ON ARCH. PLANS)

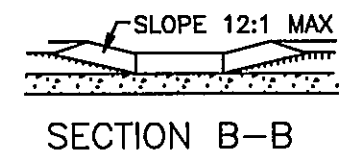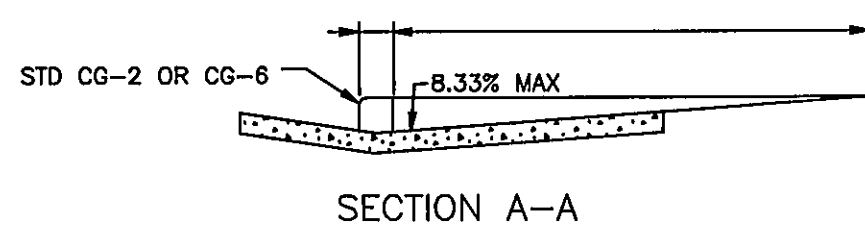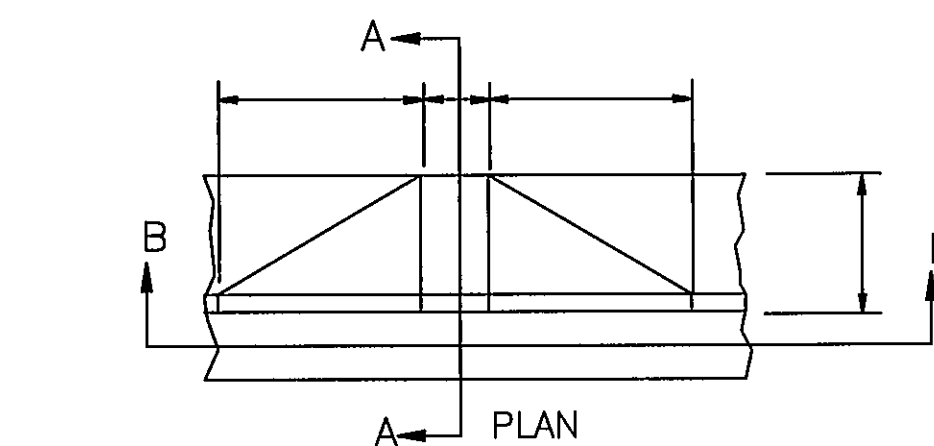

H.C. CURB RAMP
NO SCALE

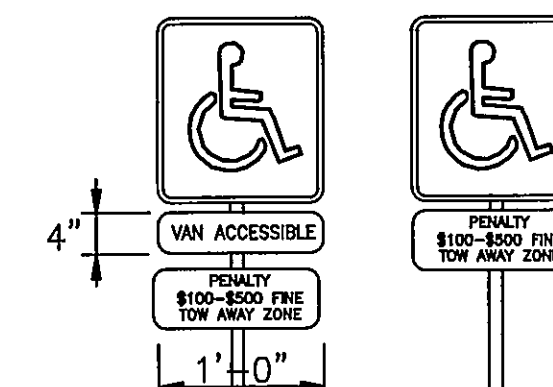

HANDICAP SIGN DETAIL
NO SCALE

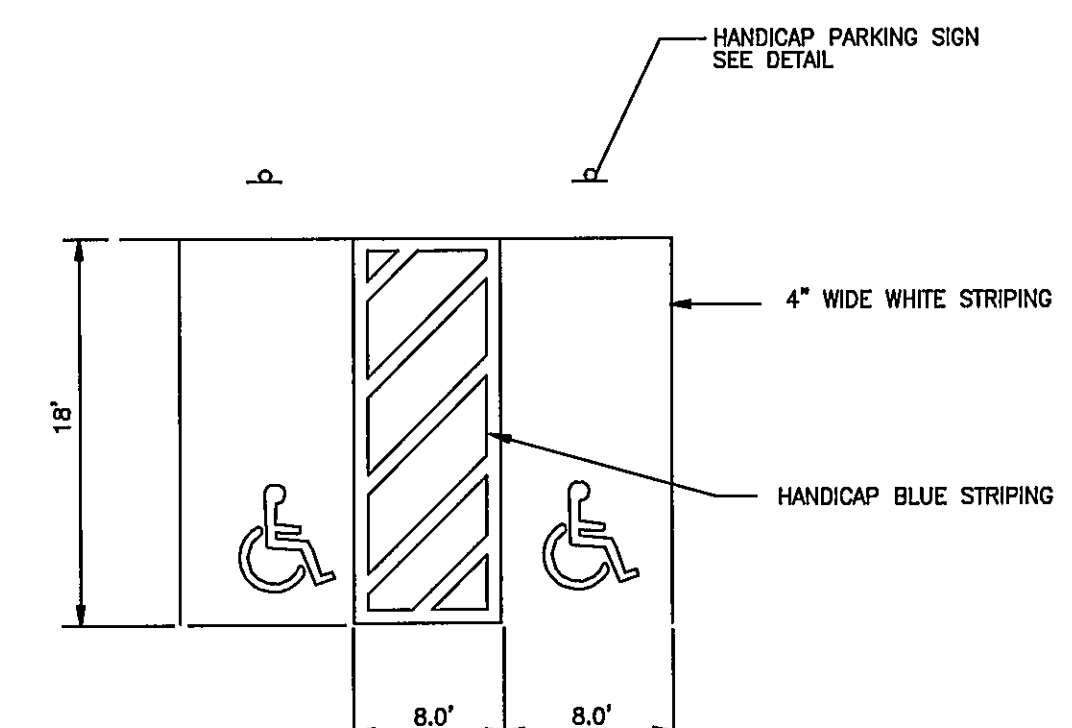

HANDICAPPED PARKING DETAIL
N.T.S.

APPROVED

BOJANGLES RESTAURANT

SITE DETAILS

HOLLINS
COUNTY OF ROANOKE, VIRGINIA

DRAWN BY: BTC
DESIGNED BY:BTC
CHECKED BY:RIS
DATE: 2-15-07


REVISIONS:
4-18-07
6-5-07
6-29-07

SCALE: AS SHOWN

SHEET NO.

C-13

JOB NO.
R0600307.00

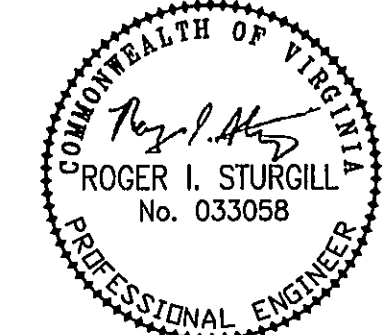

PLANNERS • ARCHITECTS
ENGINEERS • SURVEYORS

1208 Corporate Circle
Roanoke, Virginia 24018
Phone: 540/772-9580
FAX: 540/772-8050

501 Branchway Road
Richmond, Virginia 23226
Phone: 804/794-0571
FAX: 804/794-0535

880 Technology Park Drive
Suite 200
Glen Allen, Virginia 23059
Phone: 804/553-0132
FAX: 804/553-0133

448 Peppers Ferry Road, NW
Christiansburg, Virginia 24073
Phone: 540/381-4290
FAX: 540/381-4291

1591 Commerce Road
Suite 401
Norfolk, Virginia 24482
Phone: 540/248-3220
FAX: 540/248-3221