



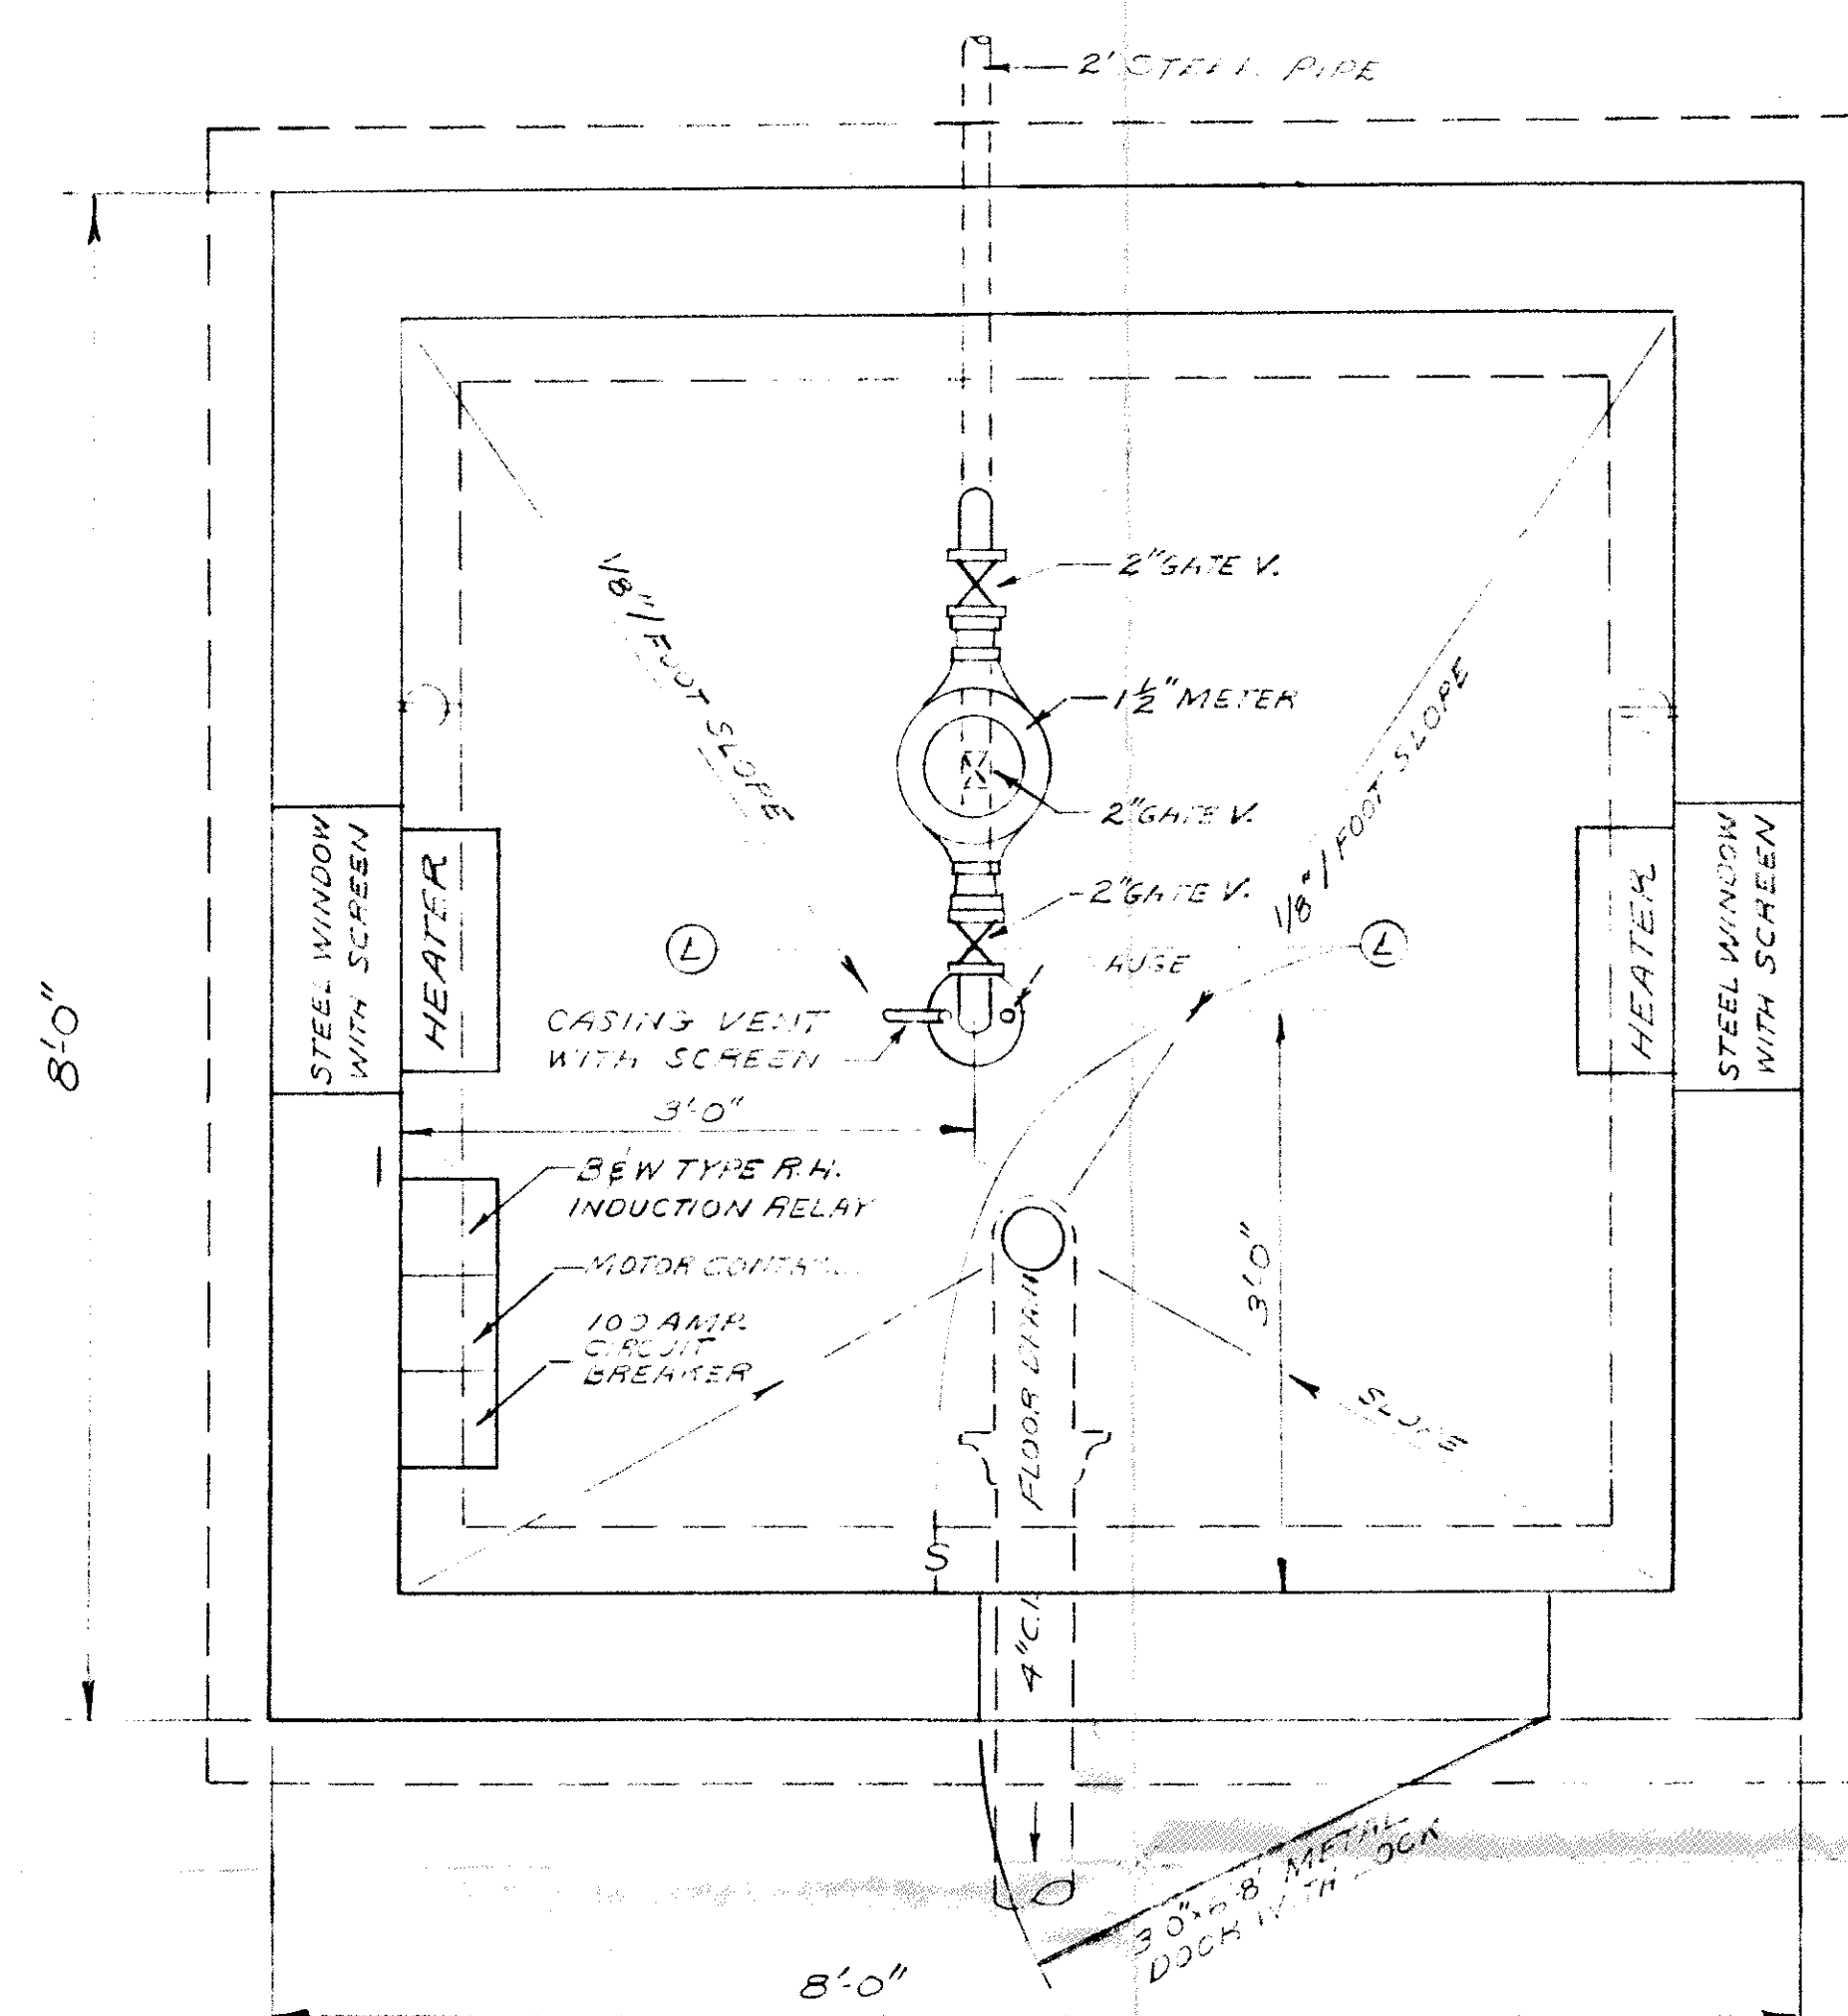


PLAN SECTION WELL HOUSE

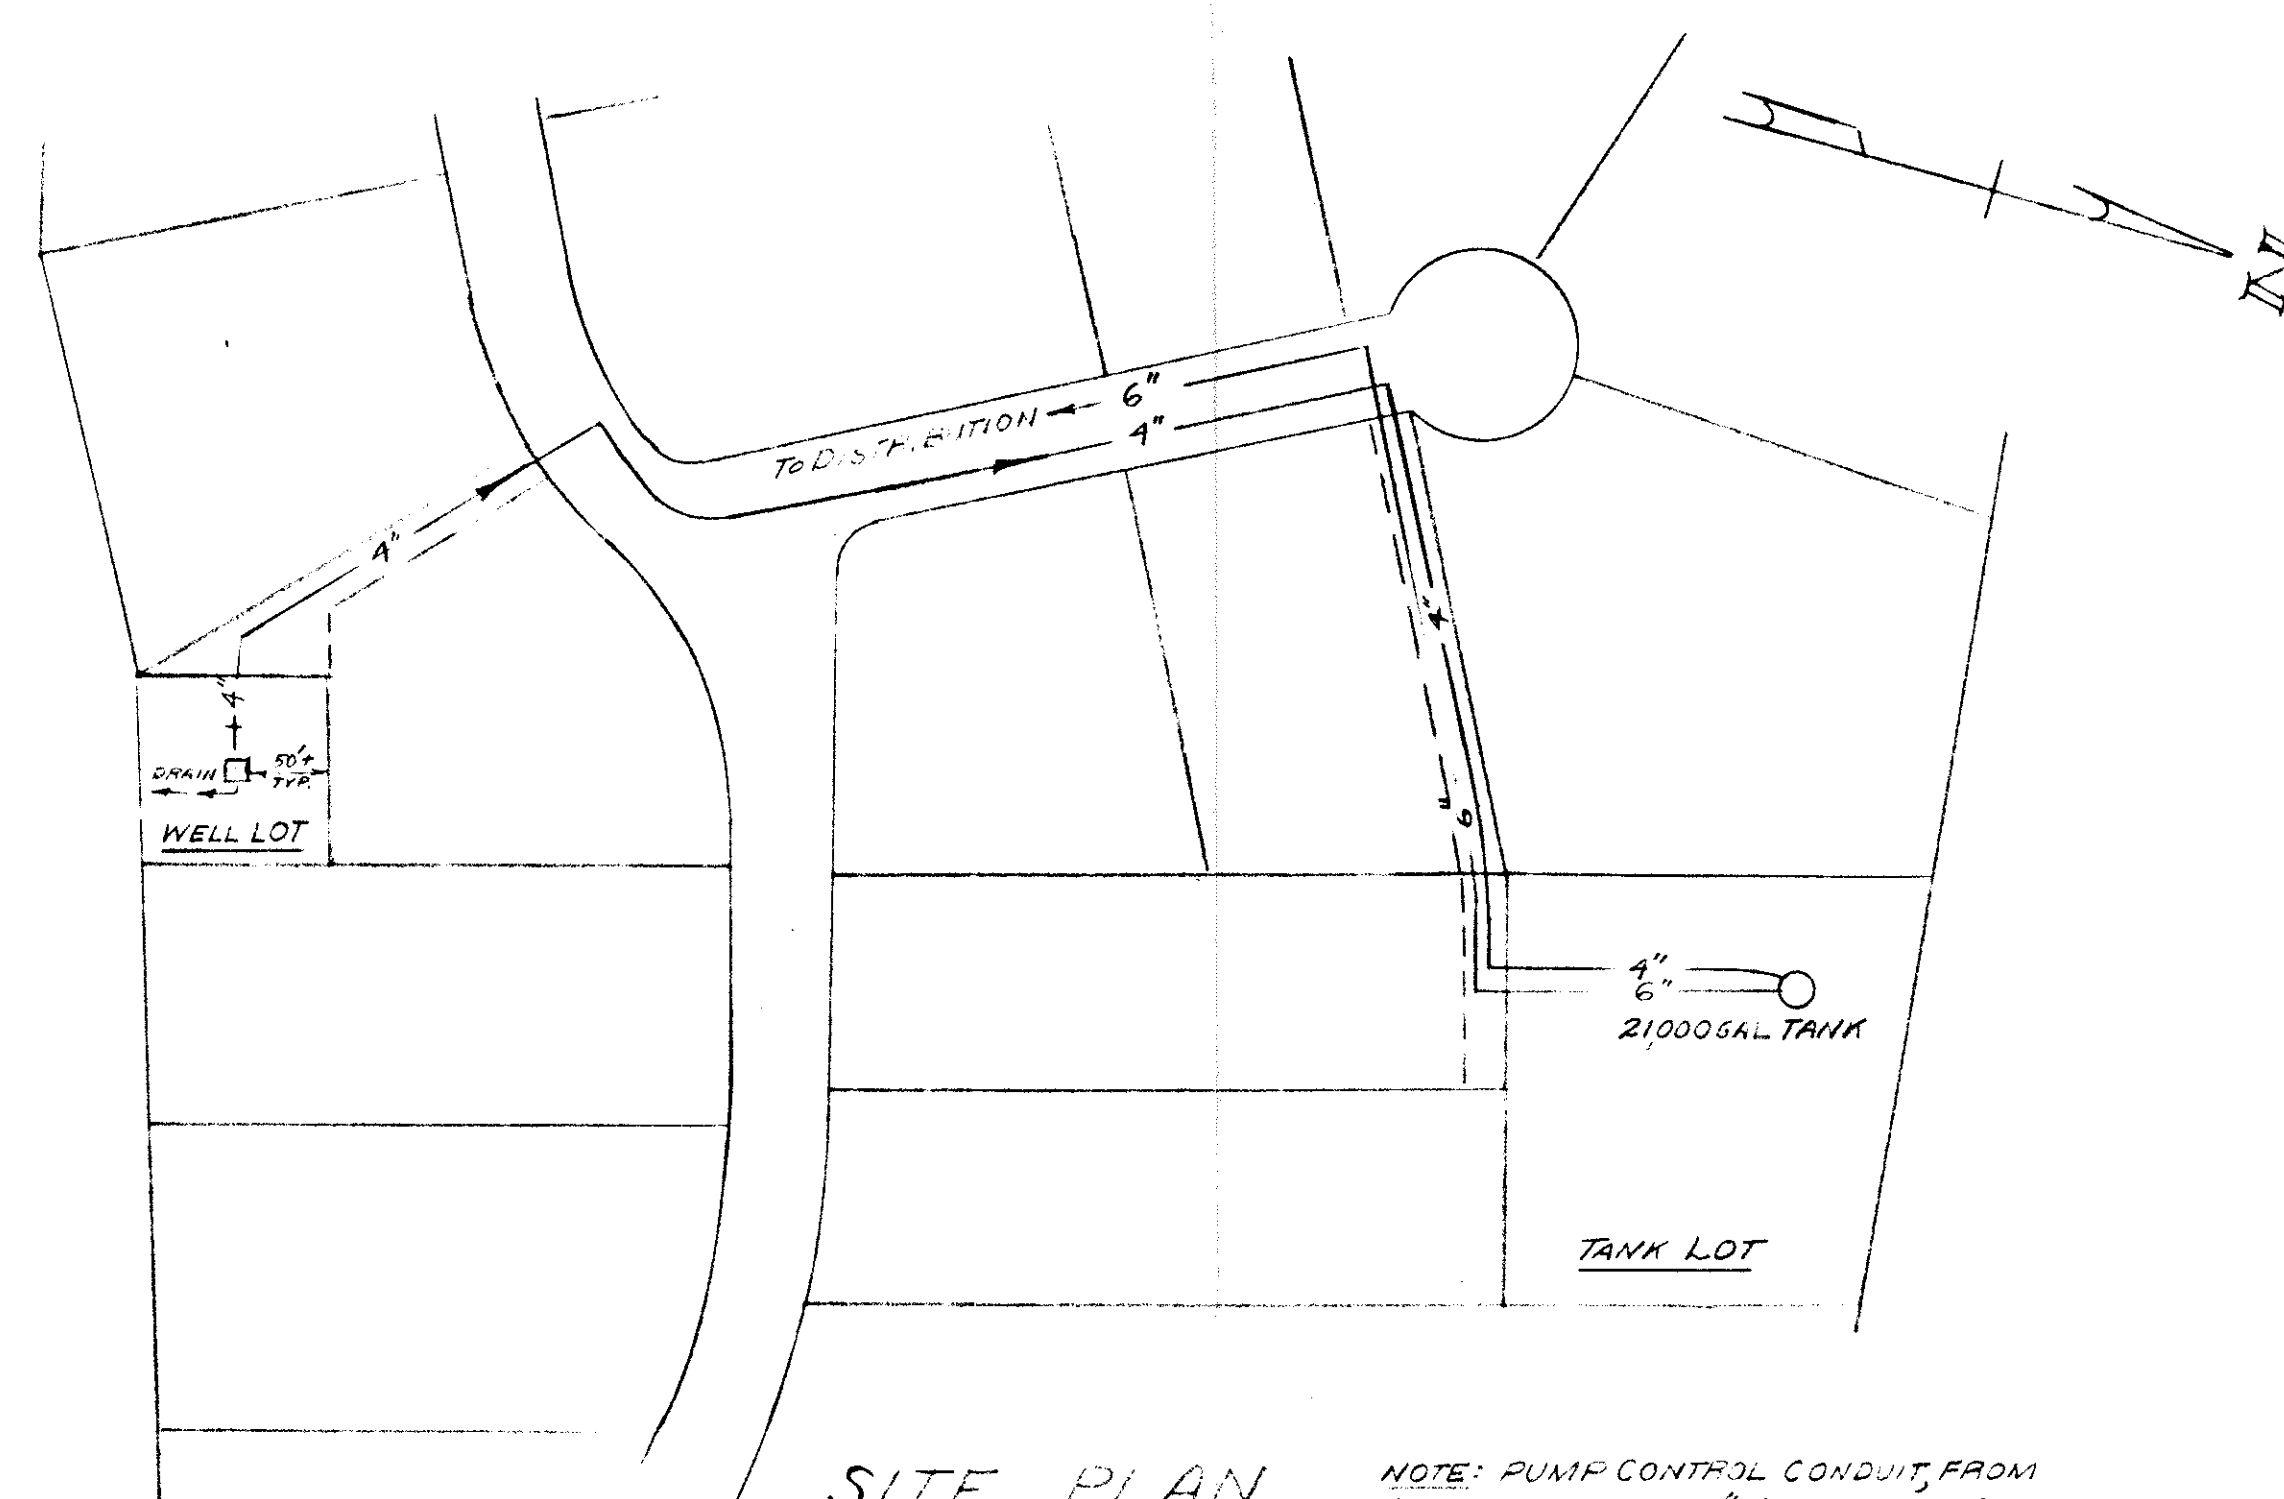

SITE PLAN
SCALE 1"=100'

NOTE: PUMP CONTROL CONDUIT, FROM
PUMP TO TANK, IN 4" PIPELINE DITCH.

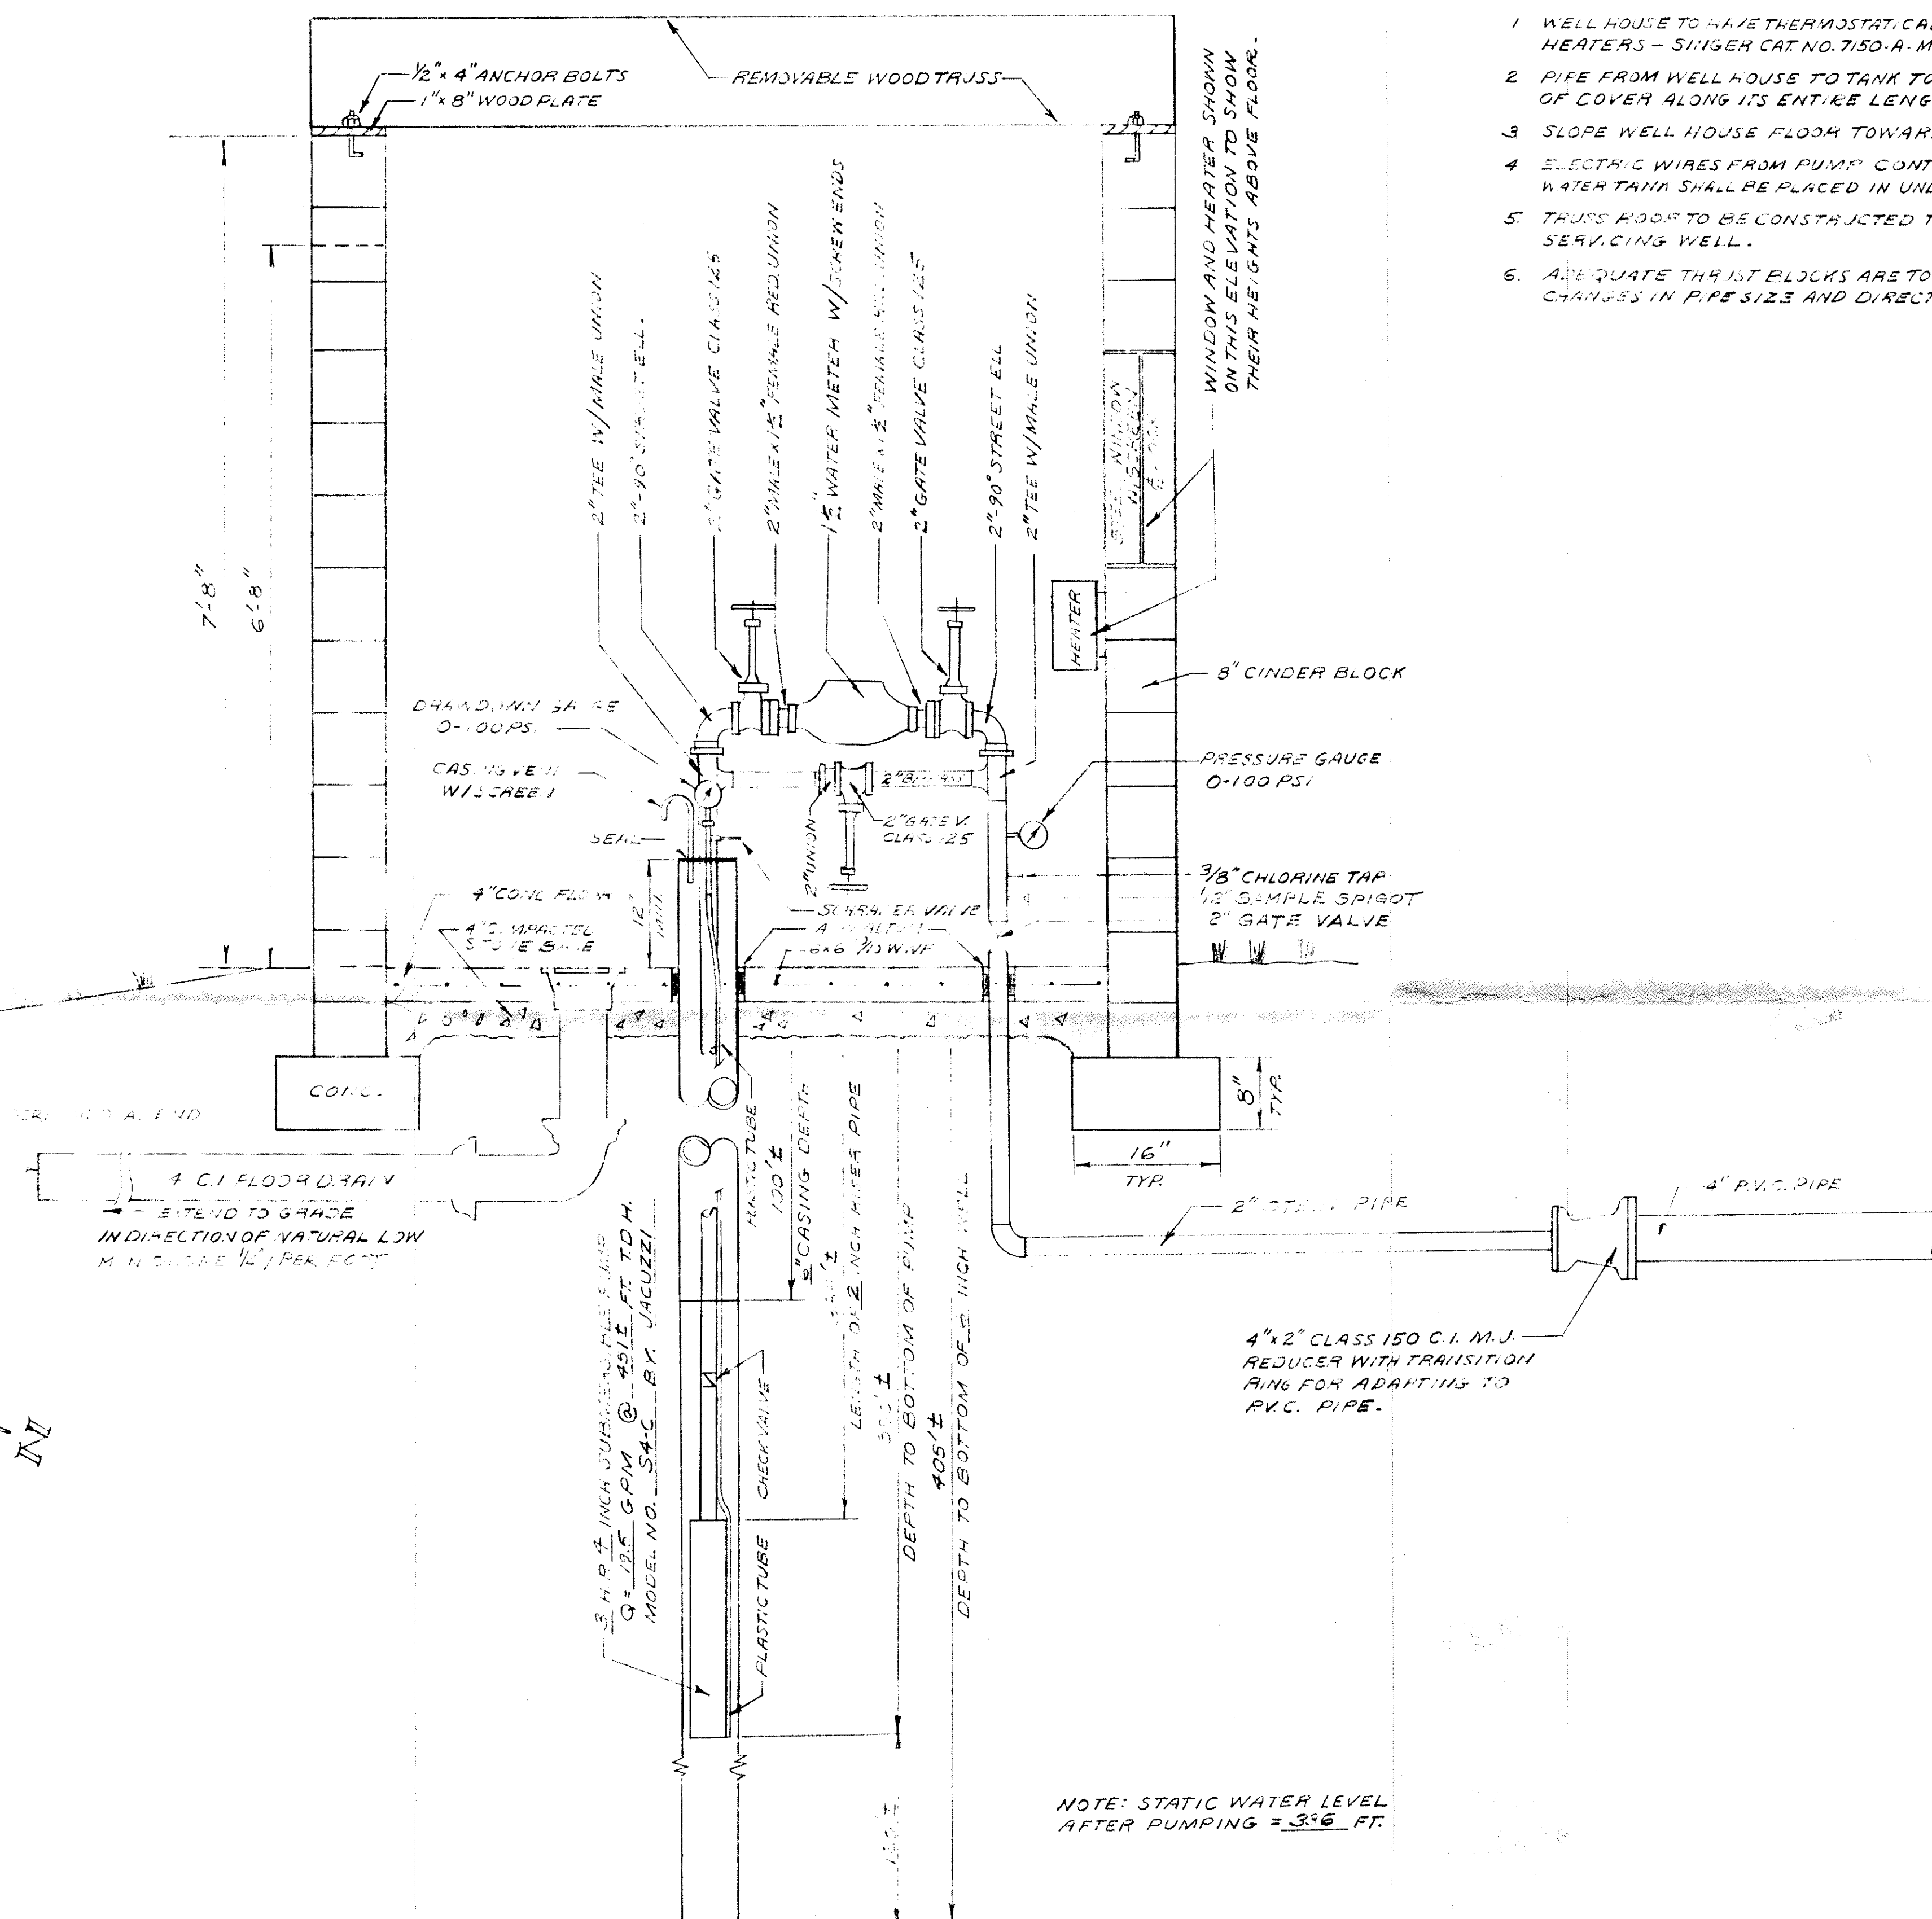

WELL & WELL HOUSE ELEVATION
NO SCALE

NO SCALE

- NOTES

1. WELL HOUSE TO HAVE THERMOSTATICALLY CONTROLLED SPACE HEATERS - SINGER CAT. NO. 7150-A, MOD NO. PA-5, 500W, 240V-2 RES.
2. PIPE FROM WELL HOUSE TO TANK TO HAVE A MINIMUM OF 3 FEET OF COVER ALONG ITS ENTIRE LENGTH.
3. SLOPE WELL HOUSE FLOOR TOWARD DRAIN AND DOOR.
4. ELECTRIC WIRES FROM PUMP CONTROLS TO ELECTRODES ON WATER TANK SHALL BE PLACED IN UNDERGROUND CONDUIT.
5. TRUSS ROOF TO BE CONSTRUCTED TO ALLOW REMOVAL FOR SERVICING WELL.
6. ADEQUATE THRUST BLOCKS ARE TO BE PROVIDED FOR ALL CHANGES IN PIPE SIZE AND DIRECTION.

NOTE: STATIC WATER LEVEL
AFTER PUMPING = 3.6 FT.

DAL-NITA HILLS WATER SYSTEM
WELL HOUSE DETAILS
PROPERTY OF
DALLAS BYRD
BOTETFOUR COUNTY, VIRGINIA
DATE: JUNE 1, 1974 SCALE: AS NOTED
T. P. PARKER & SON
ENGINEERS AND SURVEYORS
SALEM, VIRGINIA