





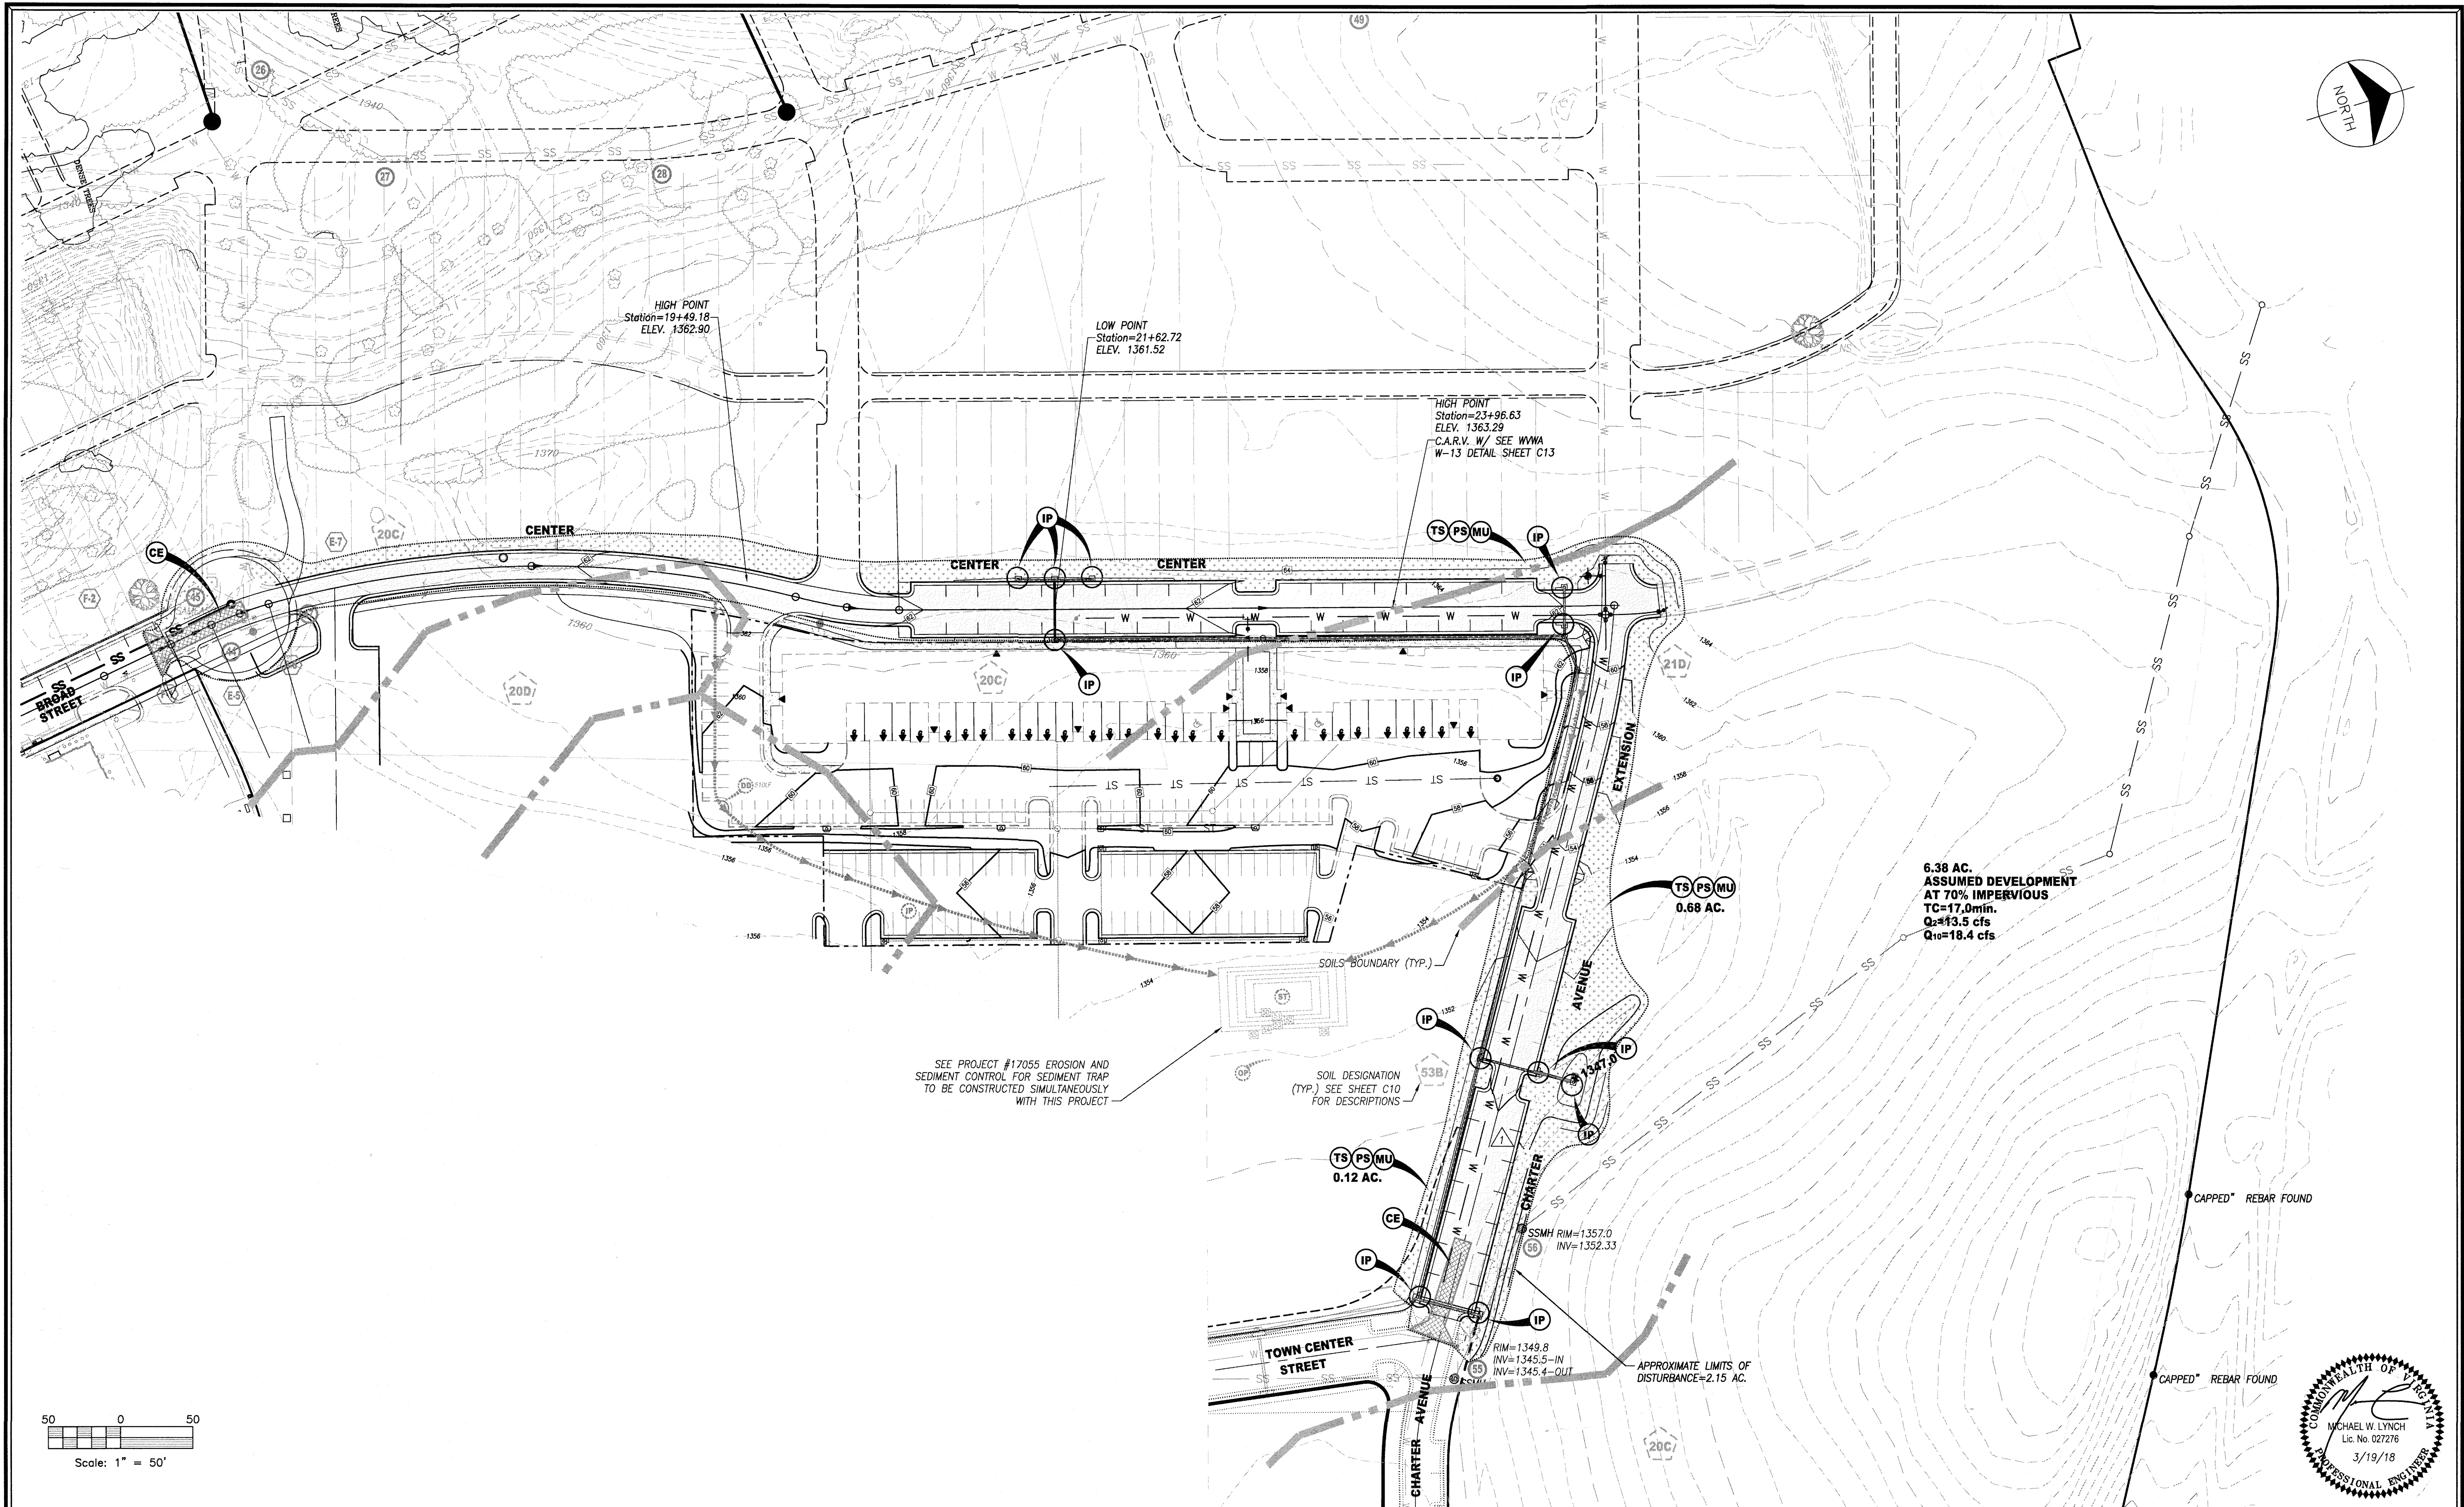

ENGINEERING CONCEPTS, INC.
94 GREENFIELD STREET
DALEVILLE, VIRGINIA 24083
540.473.1253

No.	Revision	By	Appd.	Date	Drawn	ECI	OVERALL PLAN & EROSION CONTROL BROAD ST. & CHARTER AVE. EXTENSIONS DALEVILLE TOWN CENTER BOTETOURT COUNTY, VIRGINIA	SCALE: 1" = 50'
					Designed	ECI		DATE: FEB 7, 2018
					Checked	ECI		PROJECT: 17056
					Approved	ECI		C03
1	Removed Sewer on Charter Ave	MwL	BW	3/19/18				

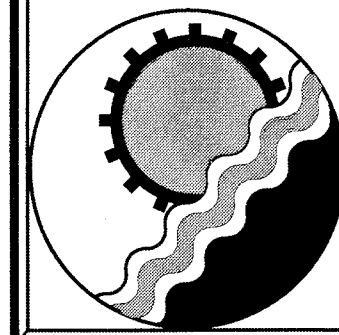