
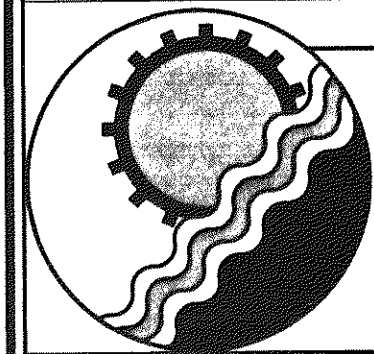
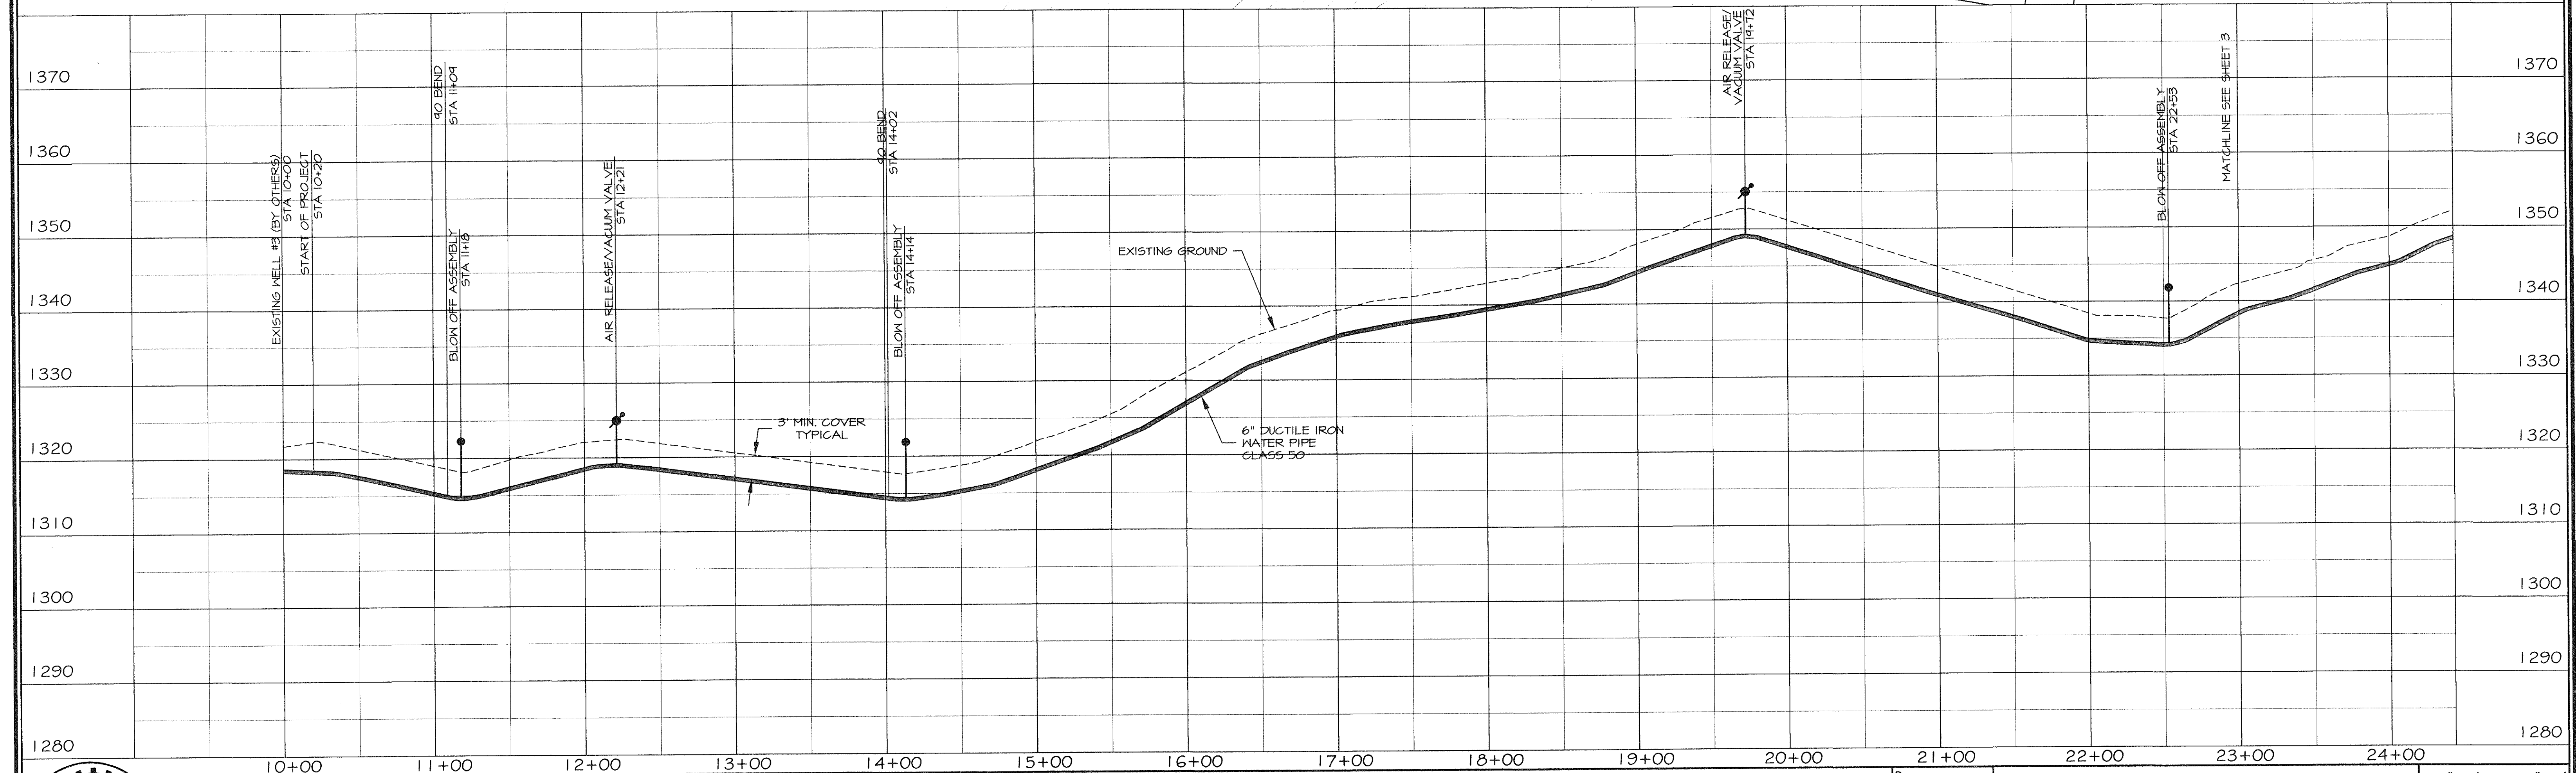


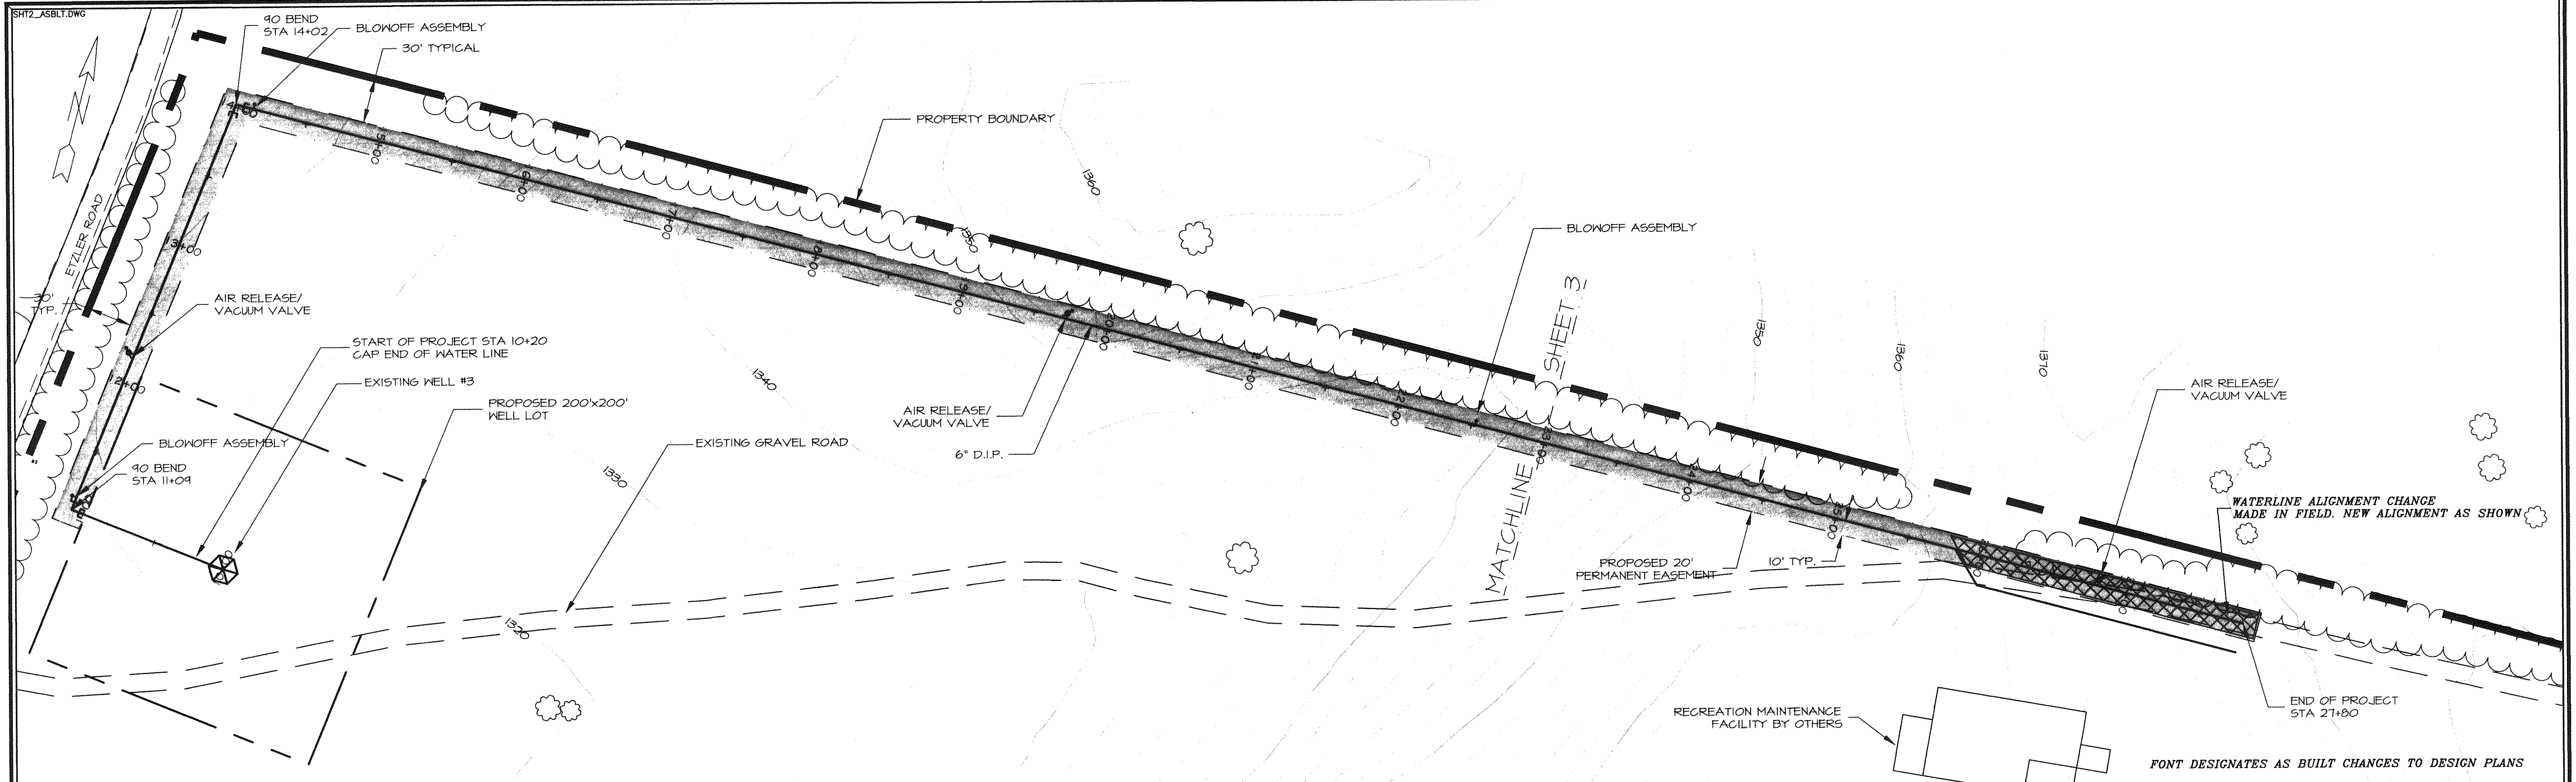

ENGINEERING CONCEPTS, INC.

20 S. ROANOKE ST., PO BOX 619
FINCASTLE, VIRGINIA 24090
540.473.1253 FAX: 540.473.1254

AS-BUILT

Drawn RHW
Designed RHW
Checked WPJ
Approved JST

**GREENFIELD
RAW WATER LINE #3**
PLAN AND PROFILE
STA 10+00 - STA 24+00

H: 1"=50' V: 1"=10'
JUNE 18, 1998
PROJECT: 97075
2 of 4