
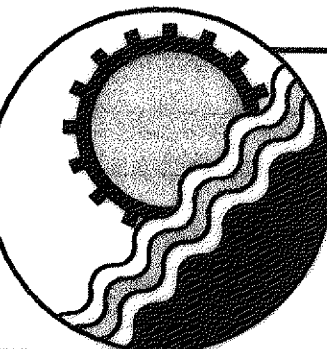
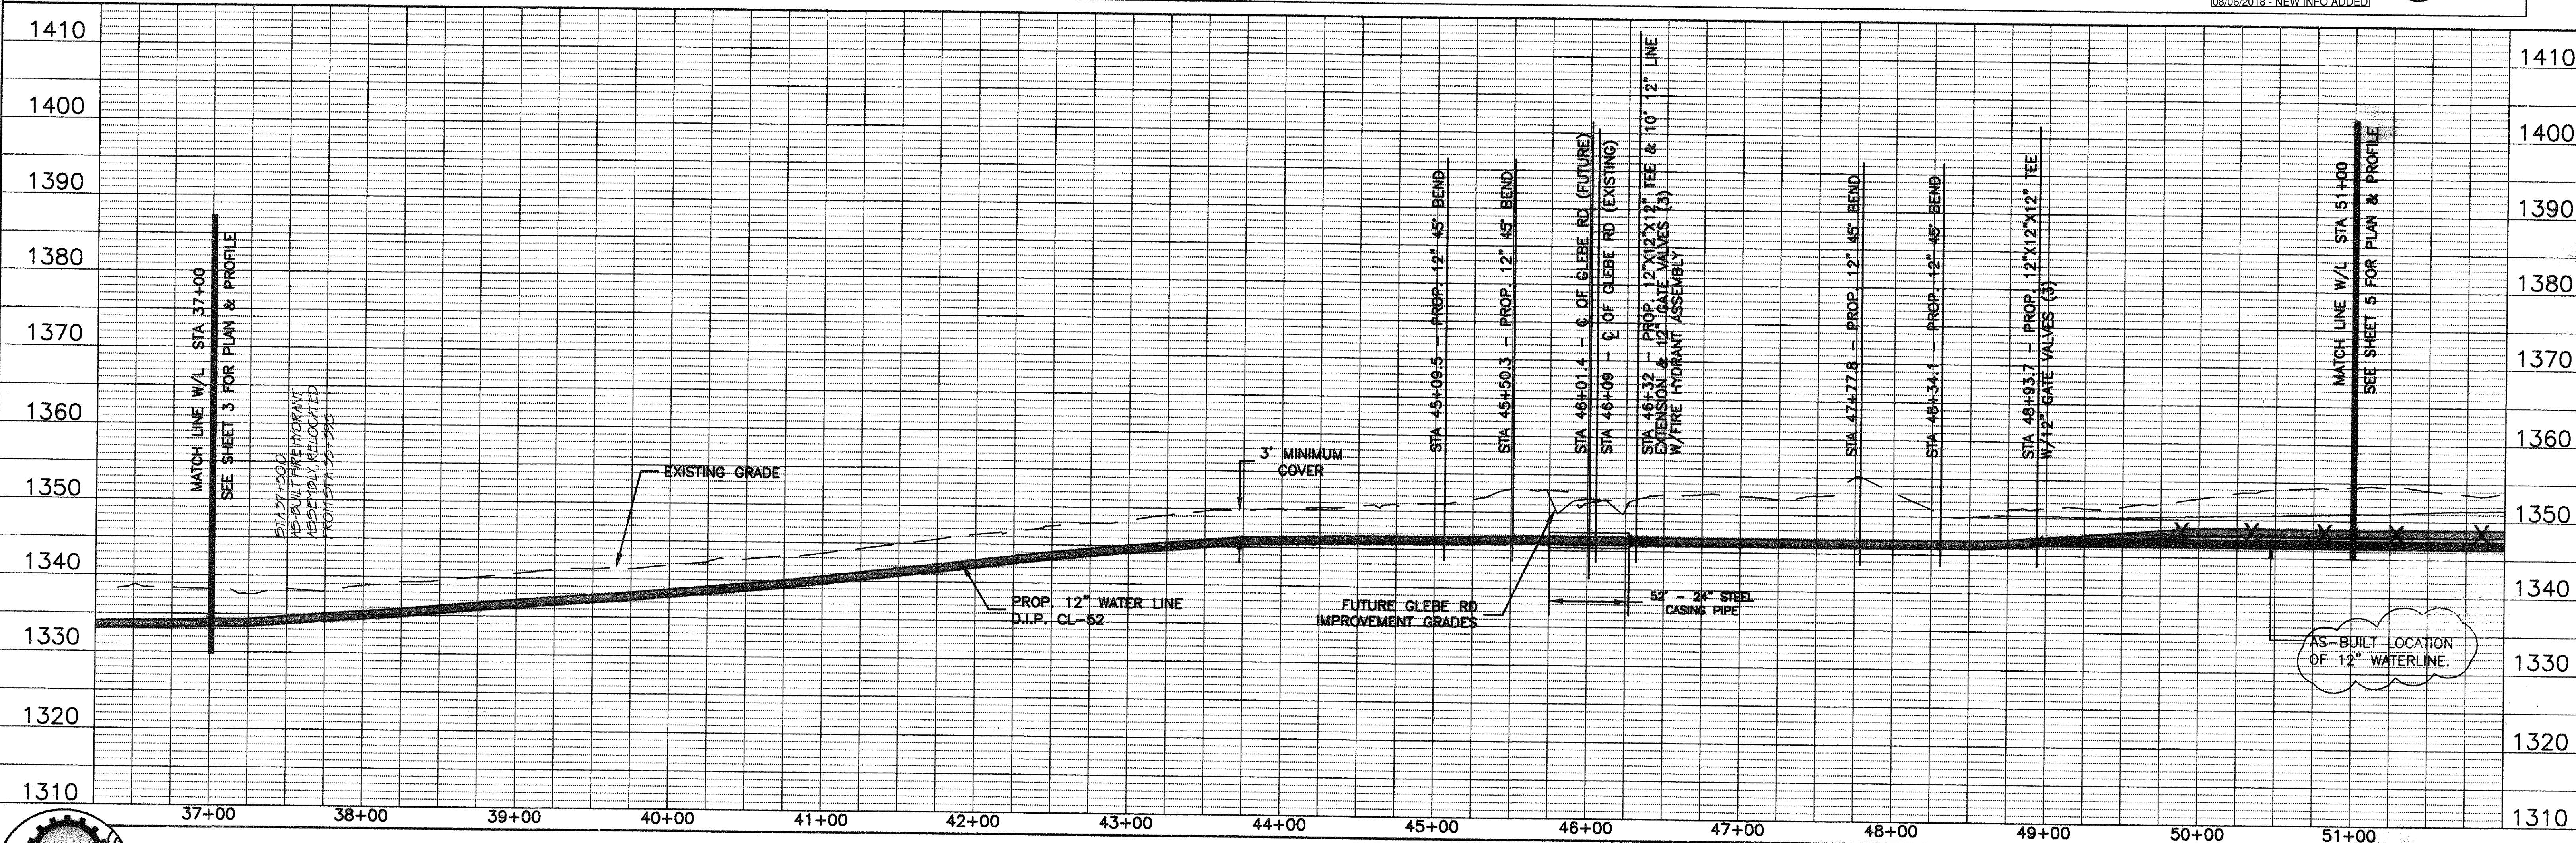


TOWN CENTER ST ↑

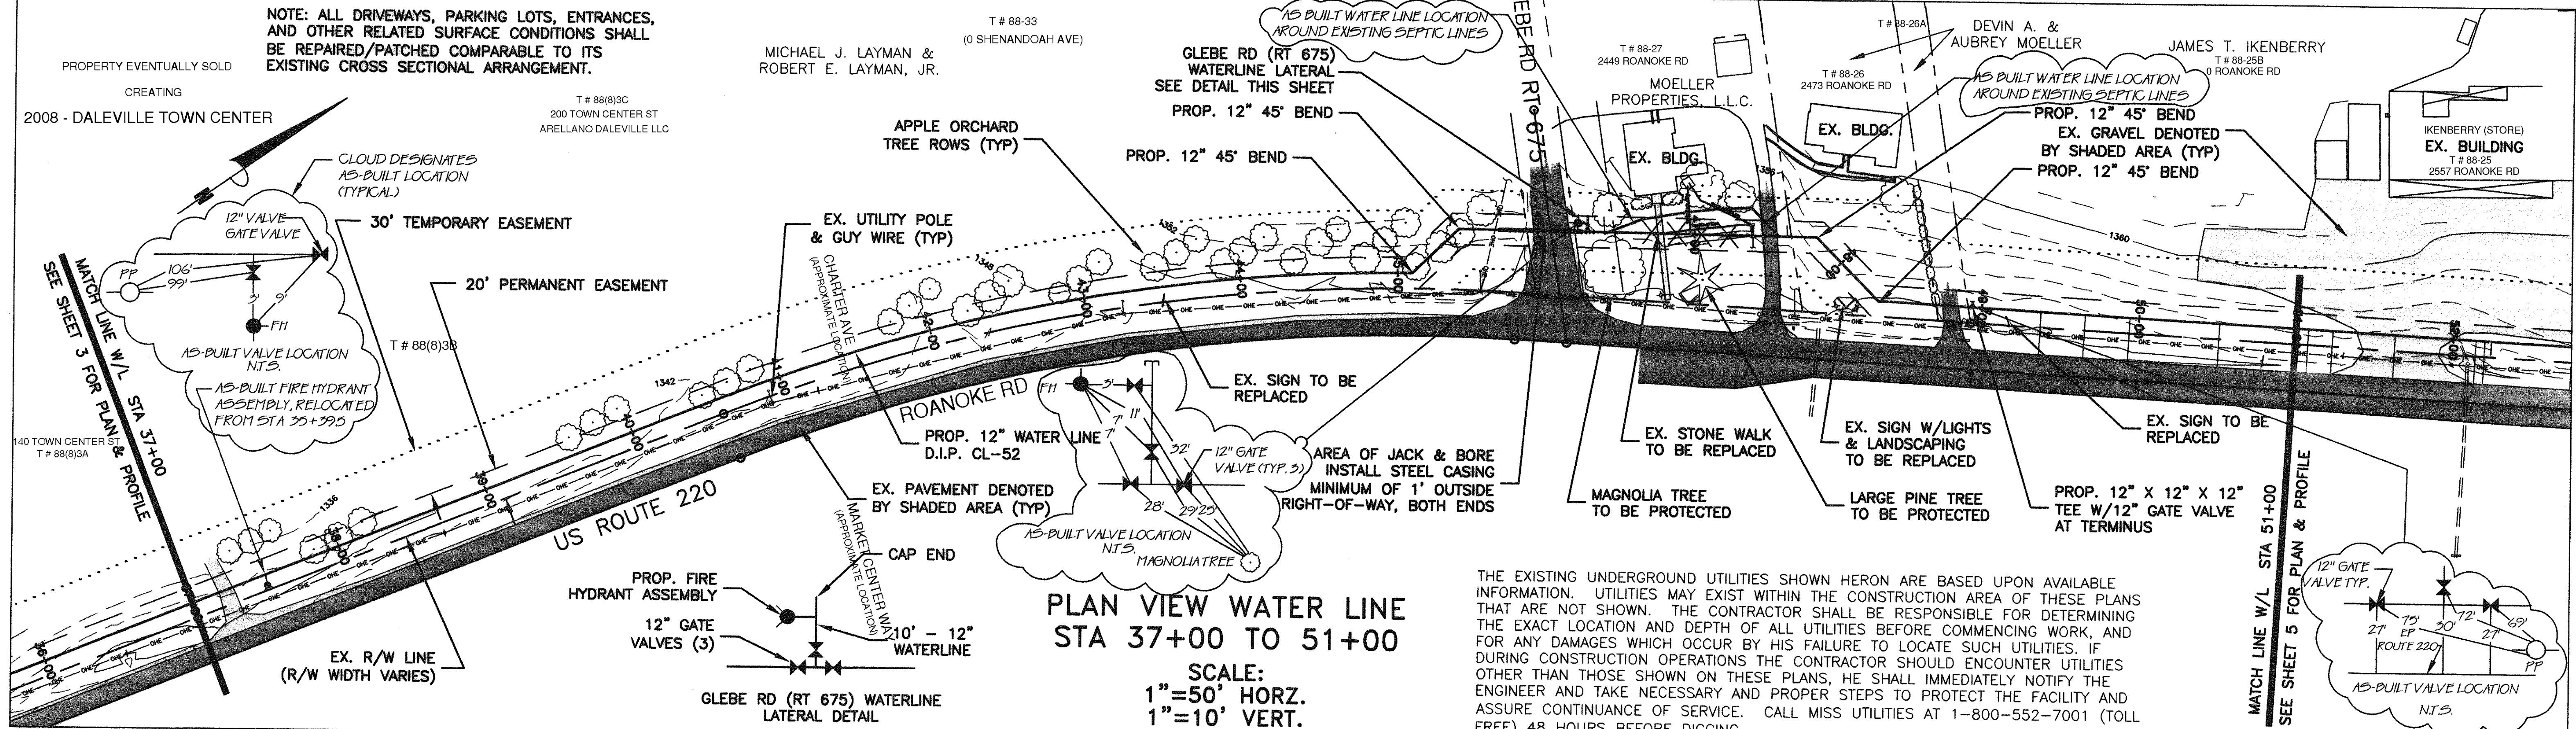

ENGINEERING CONCEPTS, INC.
20 S. ROANOKE ST., PO BOX 619
FINCASTLE, VIRGINIA 24090
540.473.1253 FAX: 540.473.1254

AS-BUILT

Drawn	JHG	GREENFIELD TO WETHERWOOD WATERLINE PLAN AND PROFILE STA 37+00 TO 51+00	SCALE: AS SHOWN
Designed	PSN		DECEMBER 2000
Checked	JST		PROJECT: 99035
Approved	PSN		4 of 13