
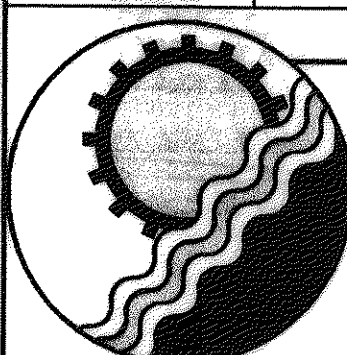
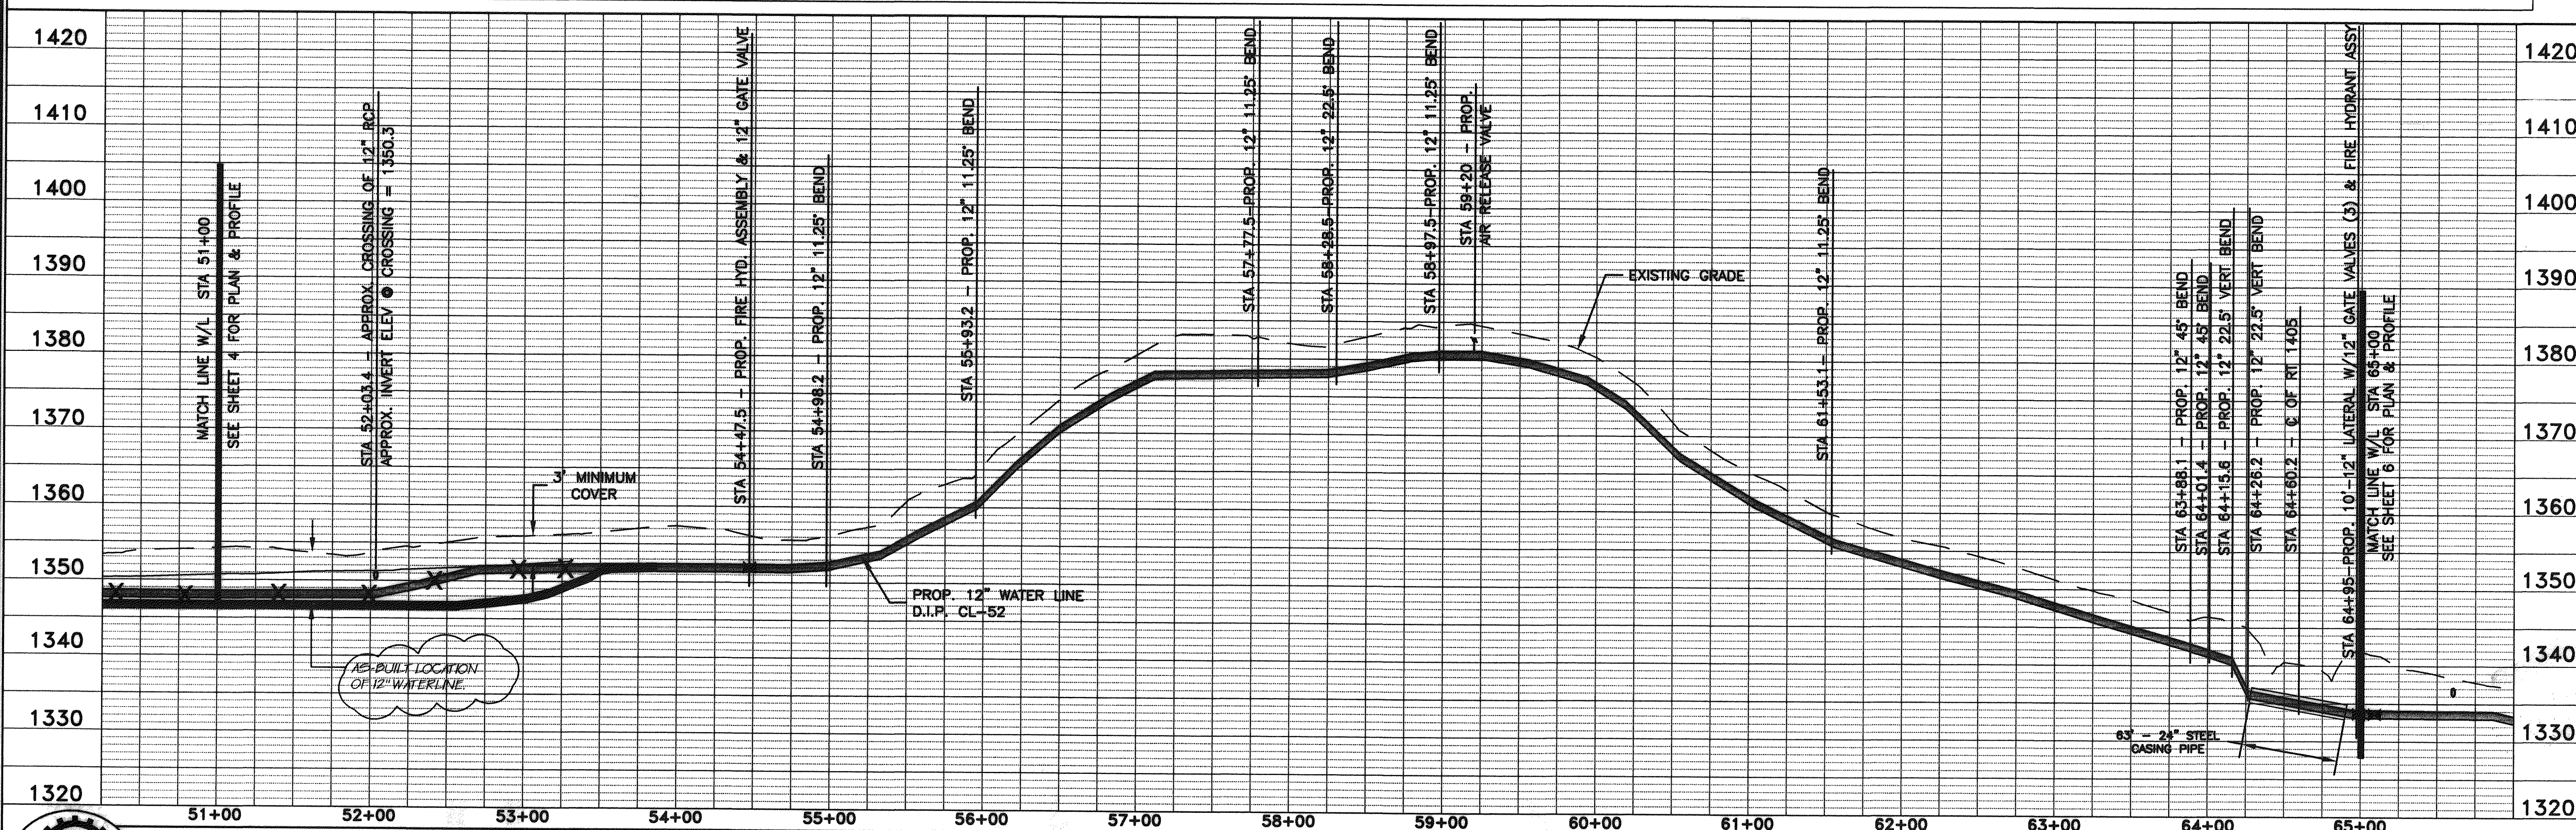


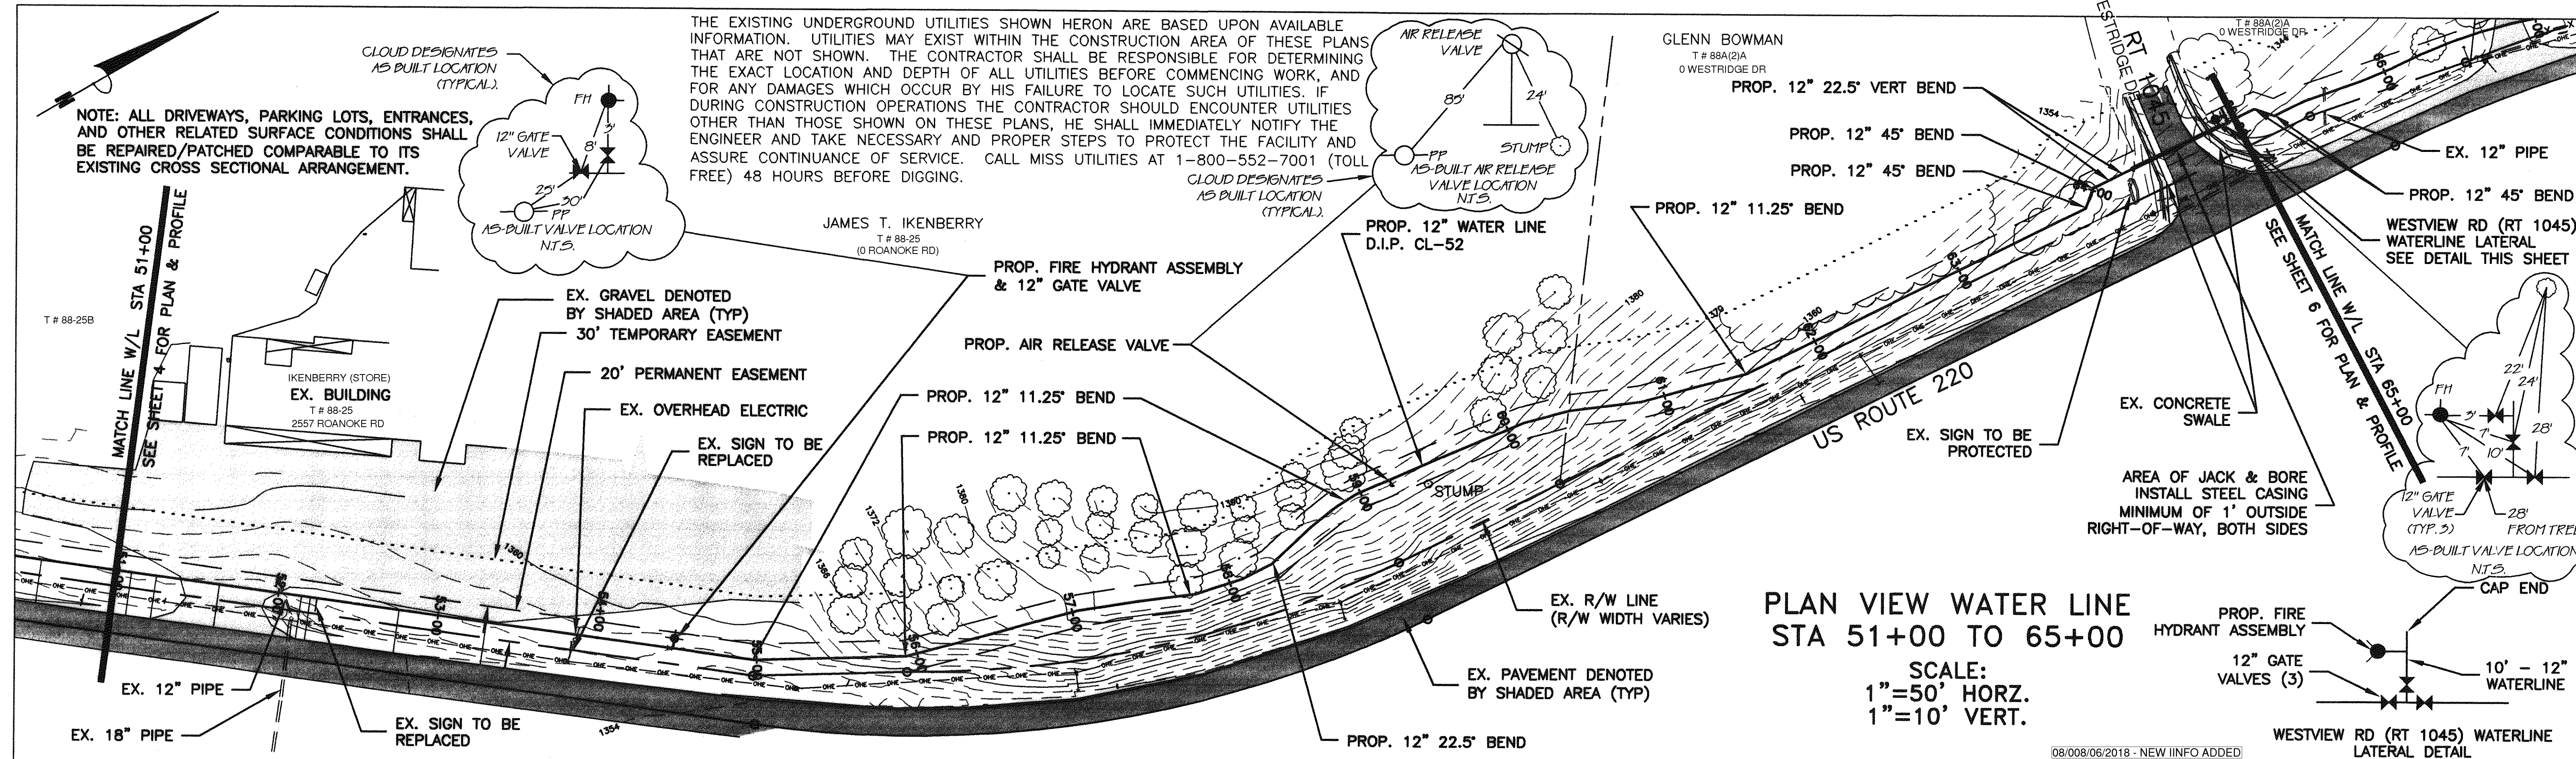

ENGINEERING CONCEPTS, INC.

20 S. ROANOKE ST., PO BOX 619
FINCASTLE, VIRGINIA 24090
540.473.1253 FAX: 540.473.1254

AS-BUILT

Drawn	JHG	GREENFIELD TO WETHERWOOD WATERLINE PLAN AND PROFILE STA 51+00 TO 65+00	SCALE: AS SHOWN
Designed	PSN		DECEMBER 2000
Checked	JST		PROJECT: 99035
Approved	PSN		5 of 13