
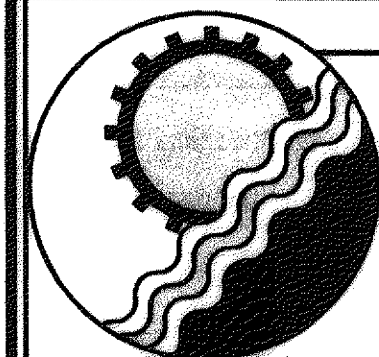
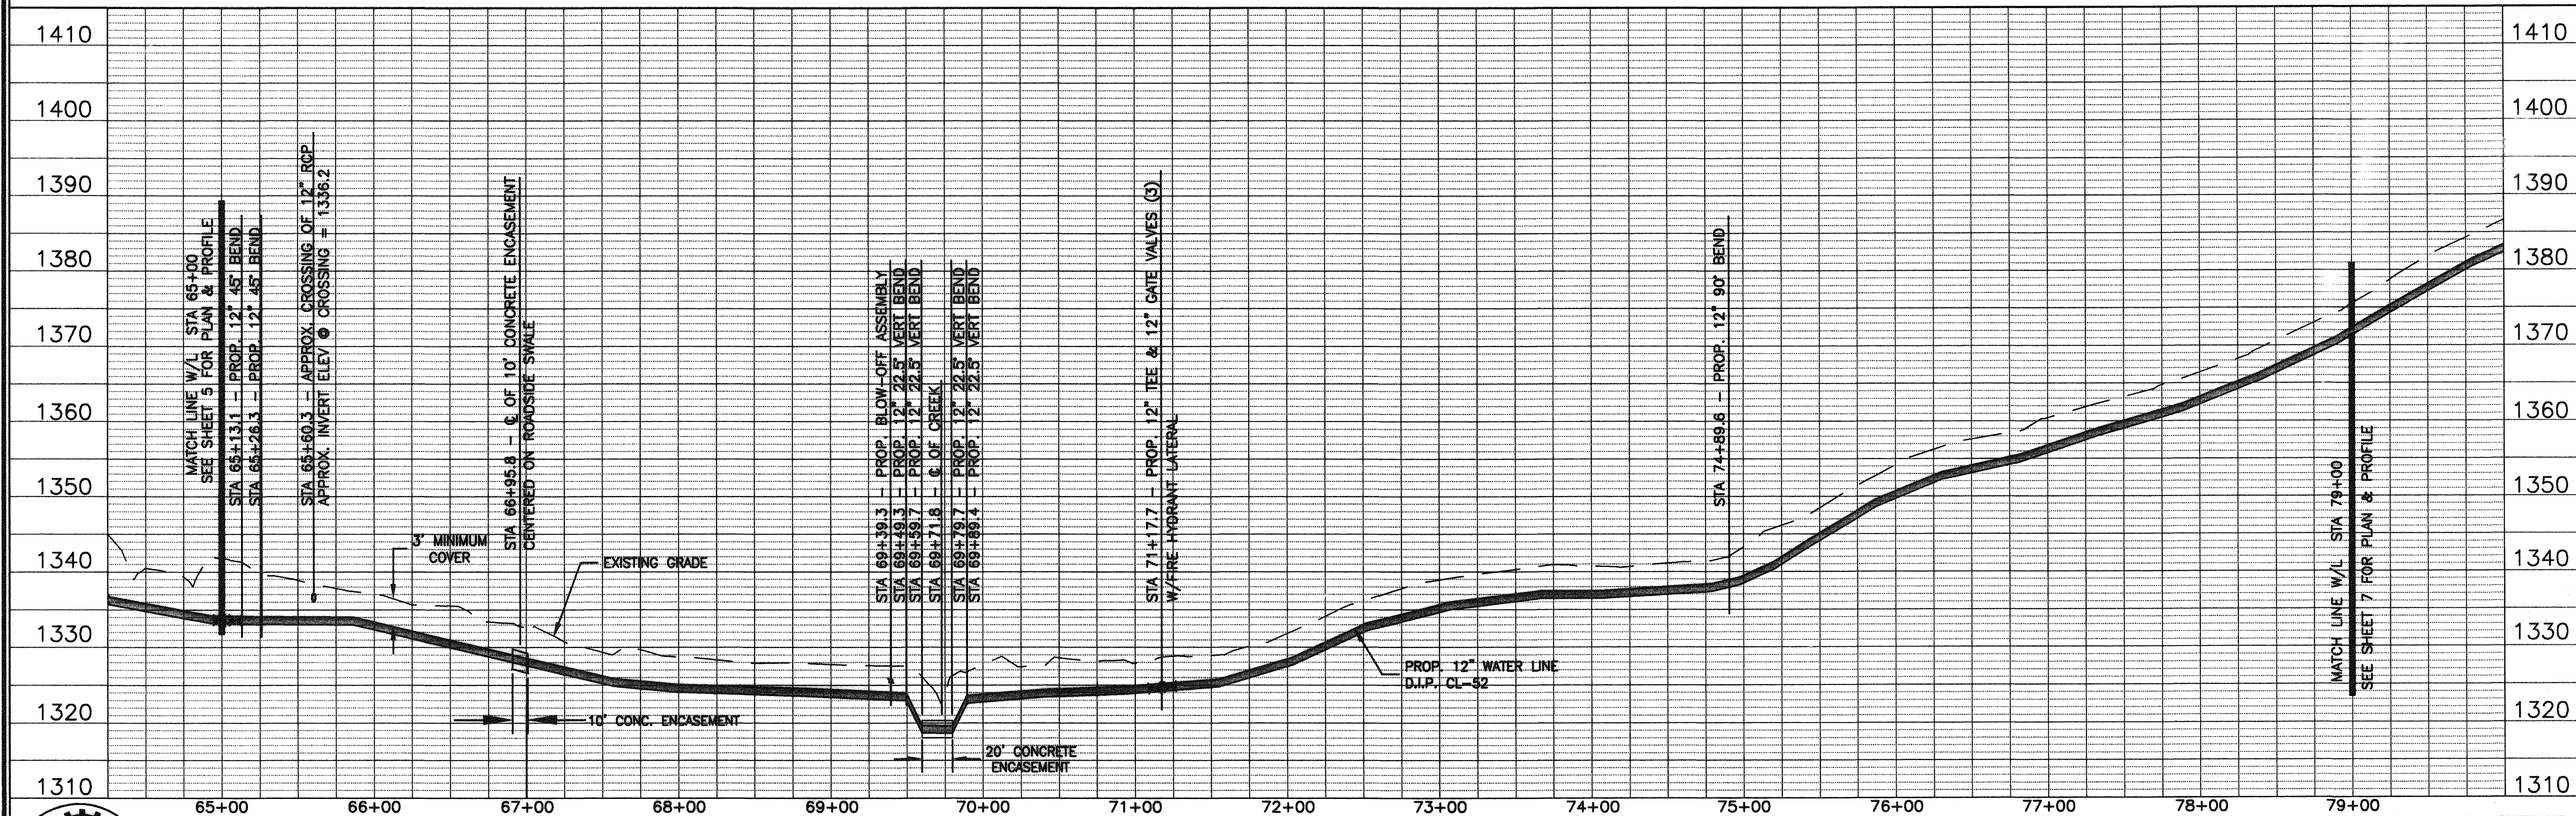


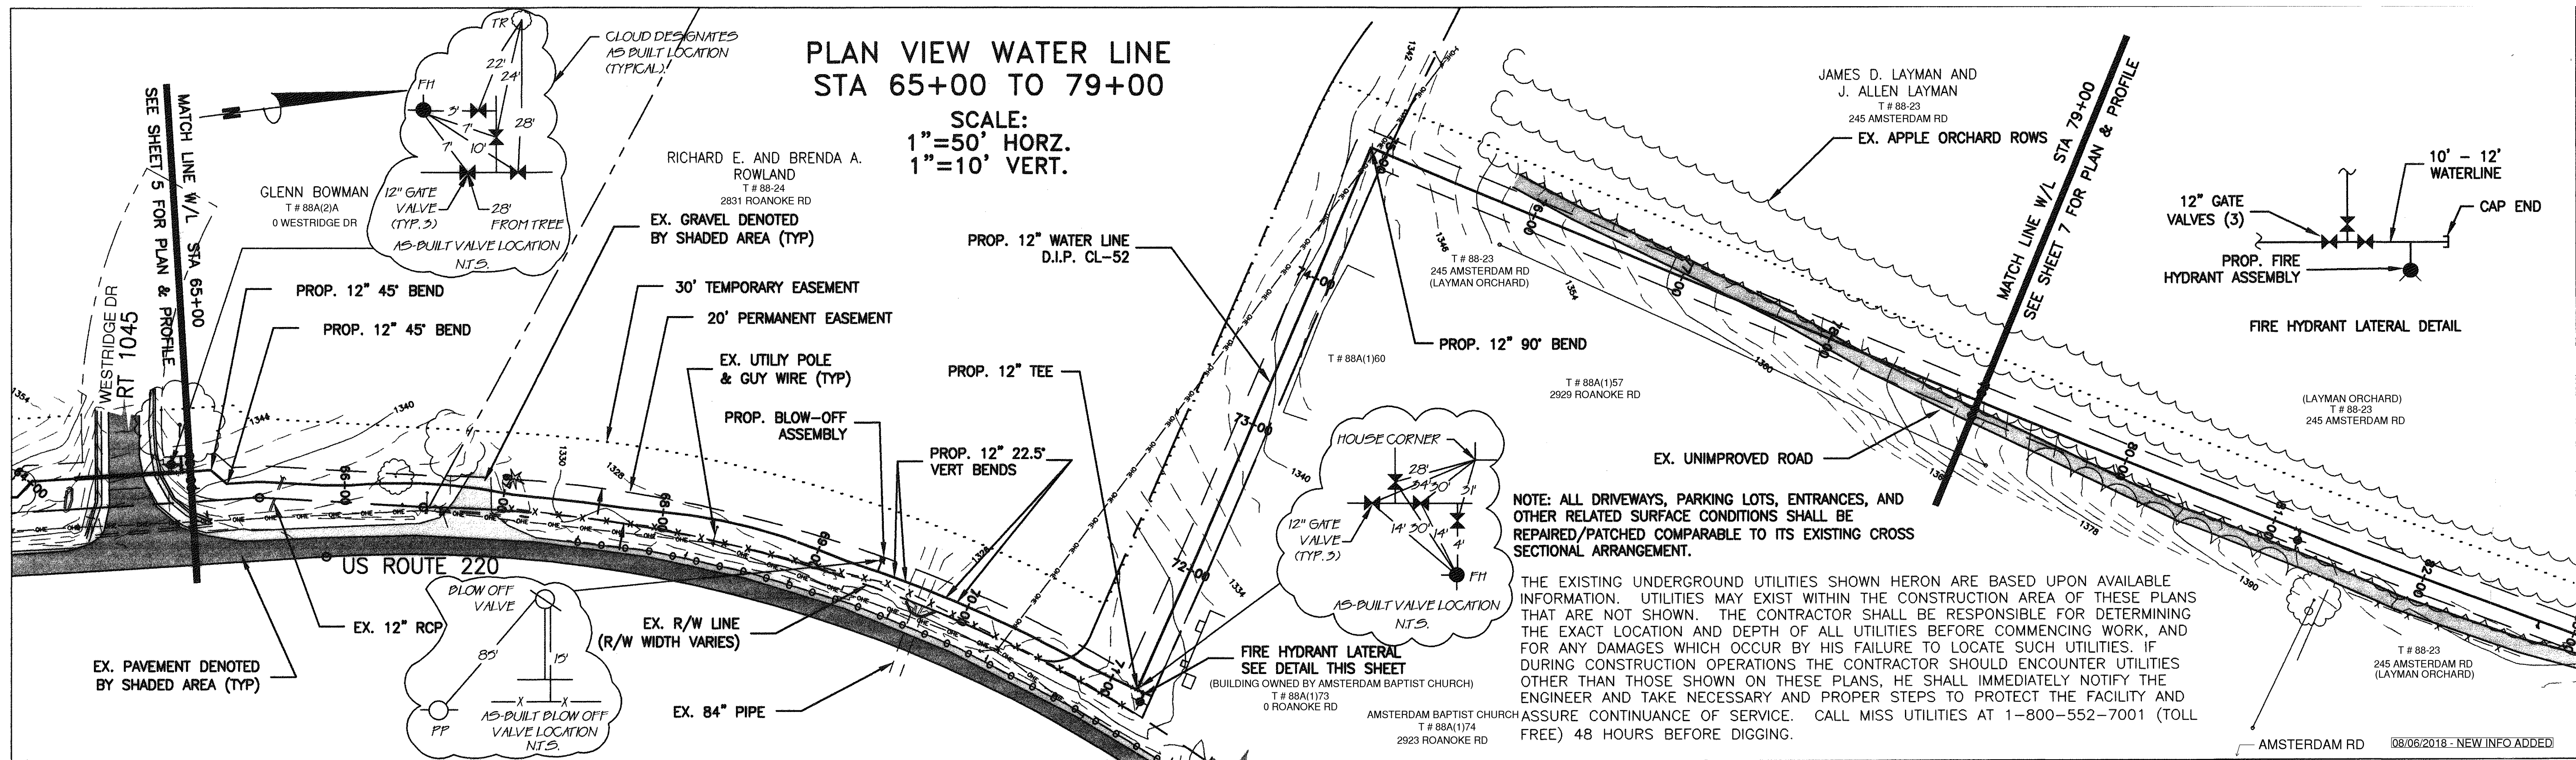

ENGINEERING CONCEPTS, INC.

20 S. ROANOKE ST., PO BOX 619
 FINCASTLE, VIRGINIA 24090
 540.473.1253 FAX: 540.473.1254

AS-BUILT

Drawn JHG
 Designed PSN
 Checked JST
 Approved PSN

GREENFIELD TO WETHERWOOD WATERLINE

PLAN AND PROFILE
 STA 65+00 TO 79+00

SCALE: AS SHOWN

DECEMBER 2000

PROJECT: 99035

6 of 13