

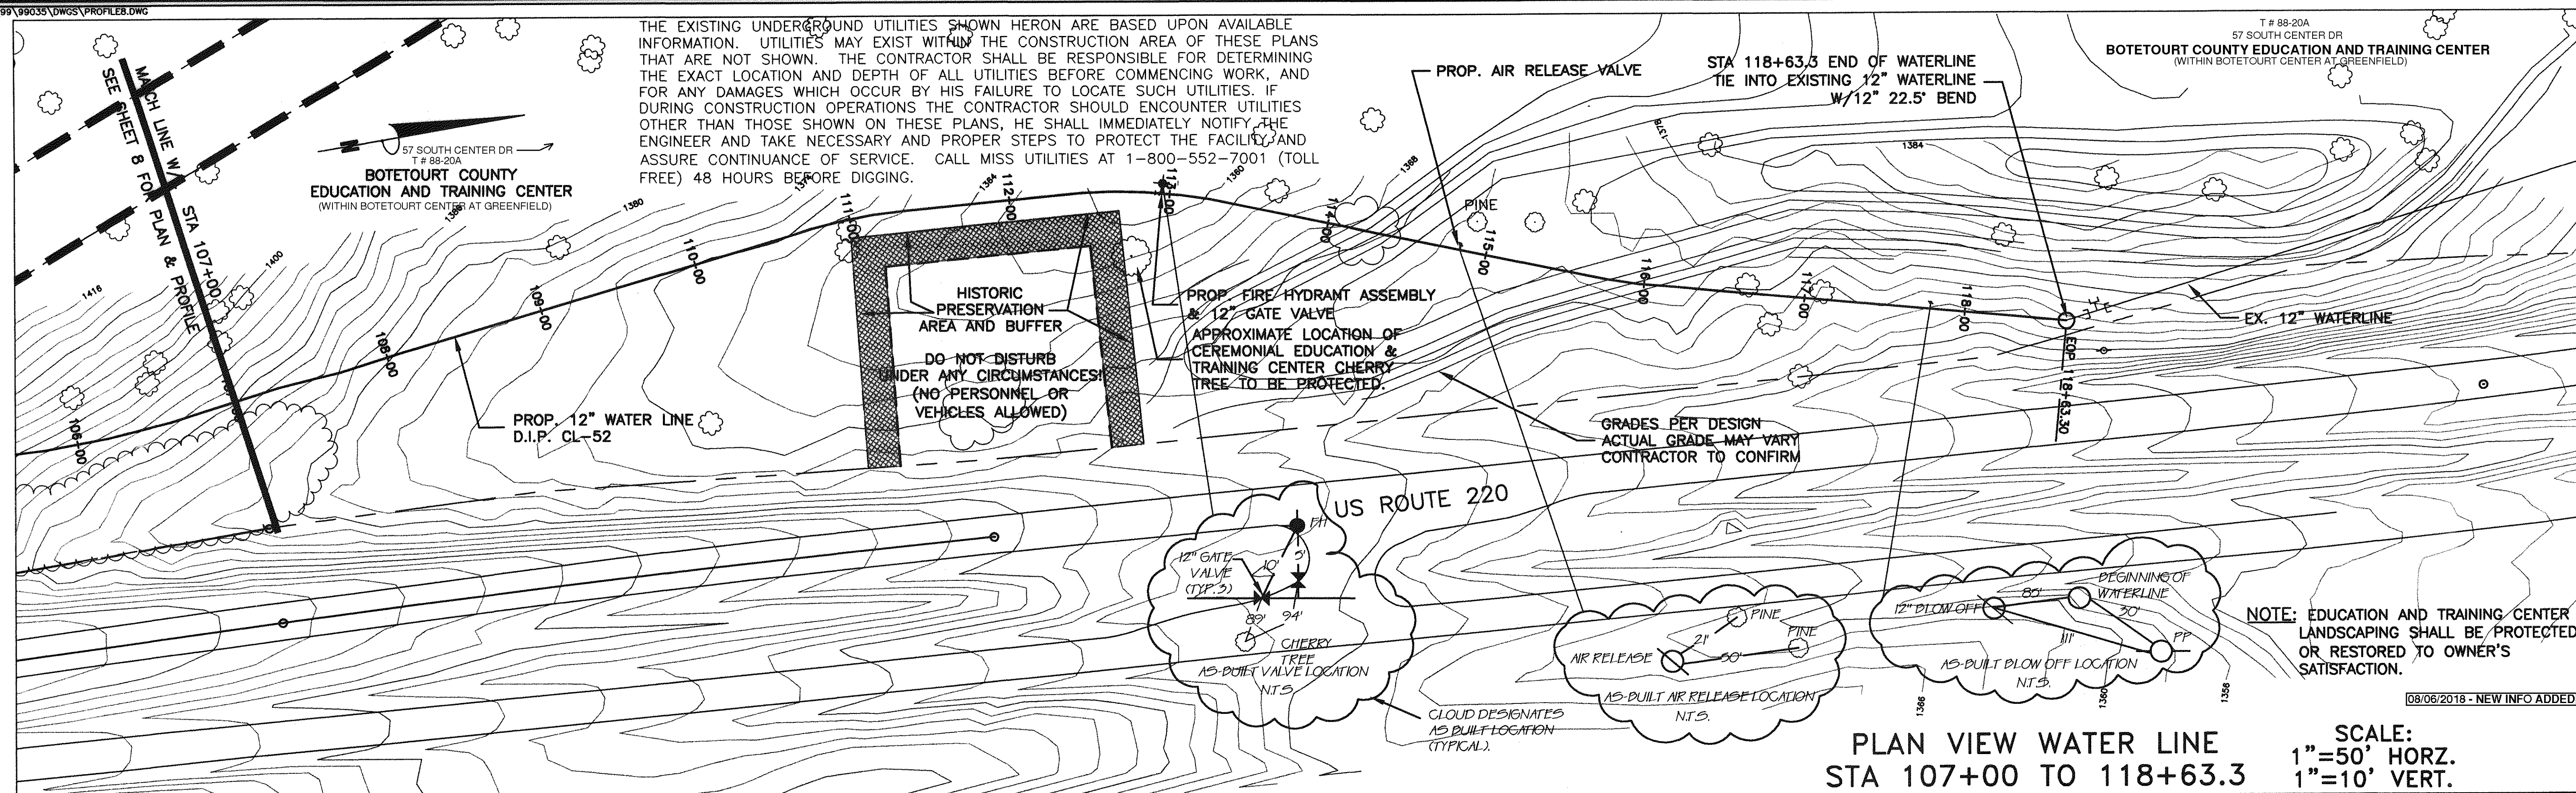


THE EXISTING UNDERGROUND UTILITIES SHOWN HEREON ARE BASED UPON AVAILABLE INFORMATION. UTILITIES MAY EXIST WITHIN THE CONSTRUCTION AREA OF THESE PLANS THAT ARE NOT SHOWN. THE CONTRACTOR SHALL BE RESPONSIBLE FOR DETERMINING THE EXACT LOCATION AND DEPTH OF ALL UTILITIES BEFORE COMMENCING WORK, AND FOR ANY DAMAGES WHICH OCCUR BY HIS FAILURE TO LOCATE SUCH UTILITIES. IF DURING CONSTRUCTION OPERATIONS THE CONTRACTOR SHOULD ENCOUNTER UTILITIES OTHER THAN THOSE SHOWN ON THESE PLANS, HE SHALL IMMEDIATELY NOTIFY THE ENGINEER AND TAKE NECESSARY AND PROPER STEPS TO PROTECT THE FACILITY AND ASSURE CONTINUANCE OF SERVICE. CALL MISS UTILITIES AT 1-800-552-7001 (TOLL FREE) 48 HOURS BEFORE DIGGING.

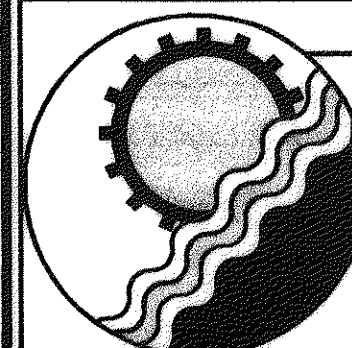

PLAN VIEW WATER LINE
STA 107+00 TO 118+63.3

SCALE:
1"=50' HORZ.
1"=10' VERT.

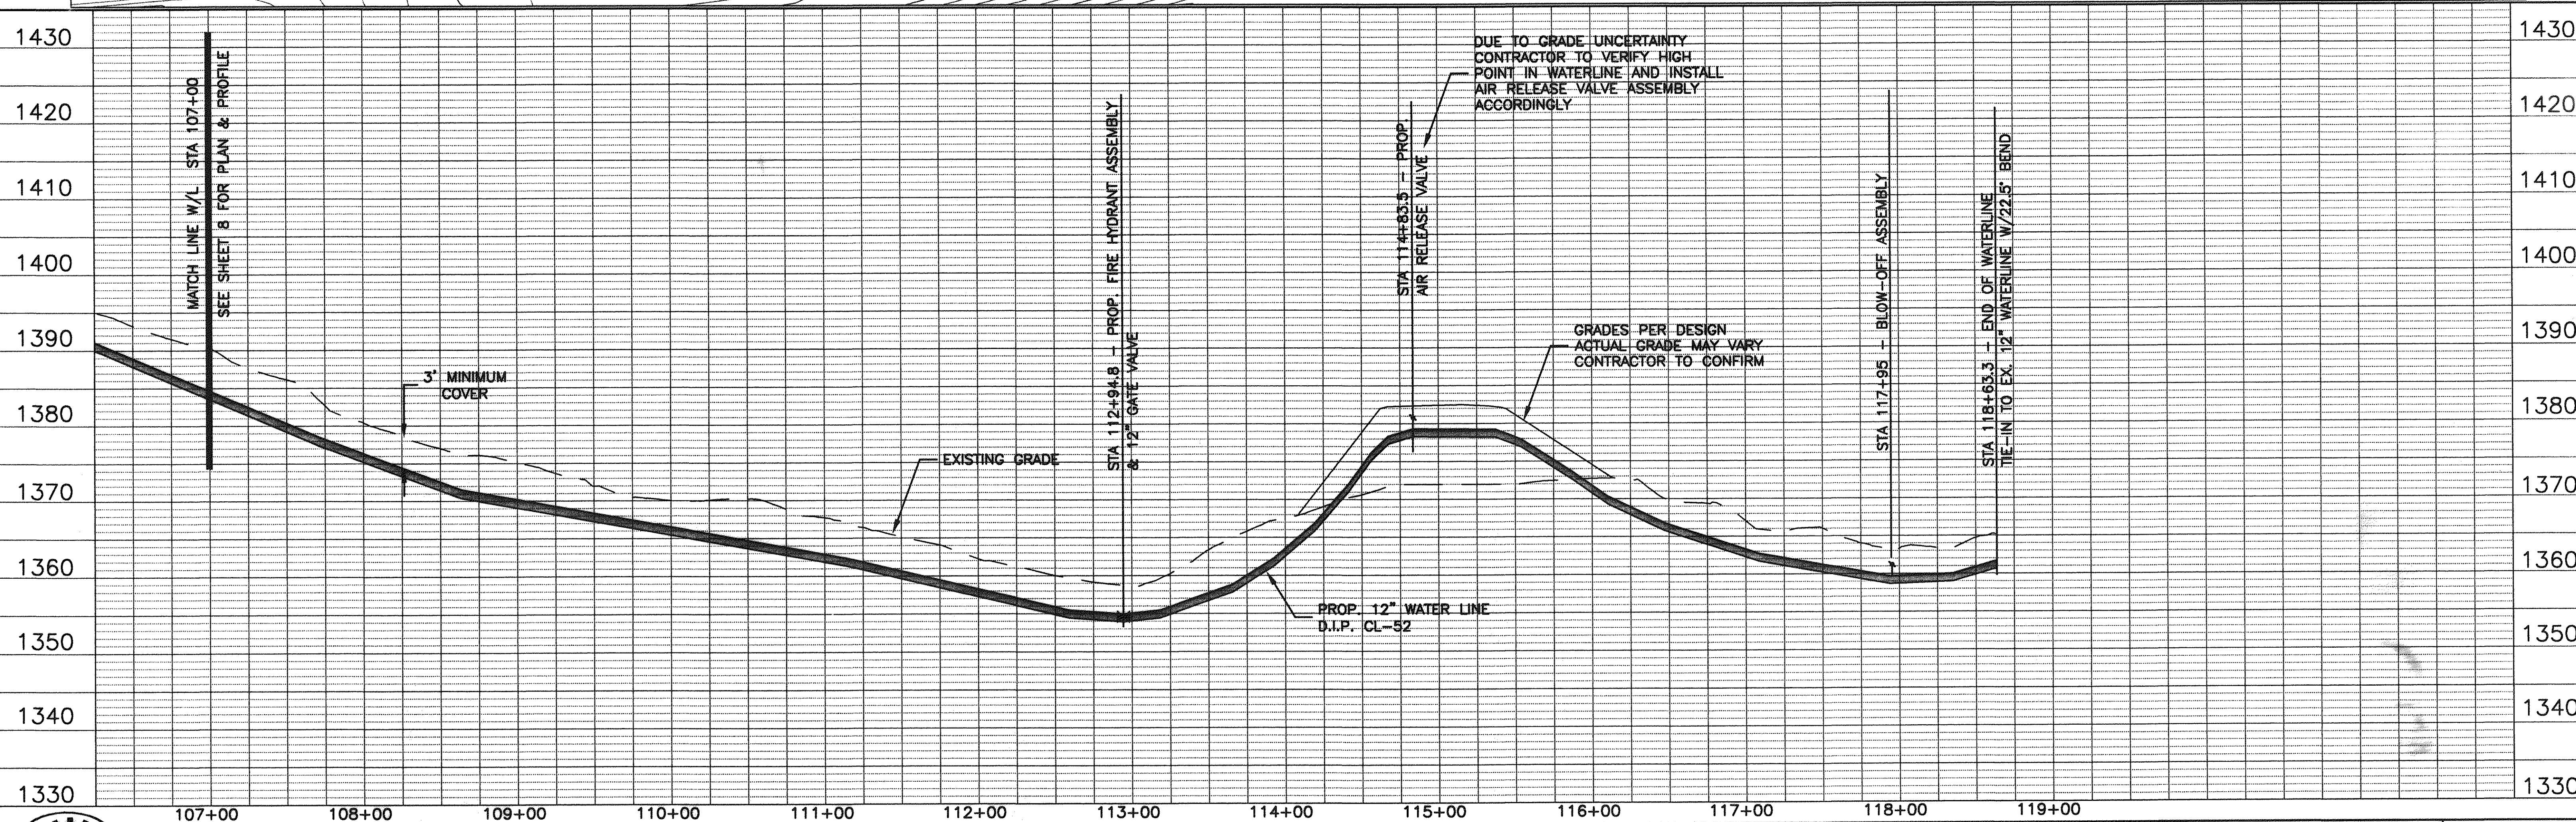

ENGINEERING CONCEPTS, INC.

20 S. ROANOKE ST., PO BOX 619
FINCASTLE, VIRGINIA 24090
540.473.1253 FAX: 540.473.1254

AS-BUILT

Drawn JHG
Designed PSN
Checked WPJ
Approved PSN

GREENFIELD TO WETHERWOOD
WATERLINE

PLAN AND PROFILE
STA 107+00 TO 118+63.3

SCALE: AS SHOWN
DECEMBER 2000
PROJECT: 99035
9 of 13