

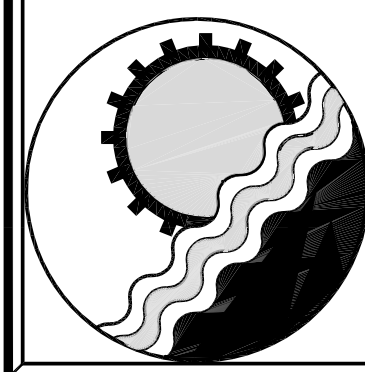


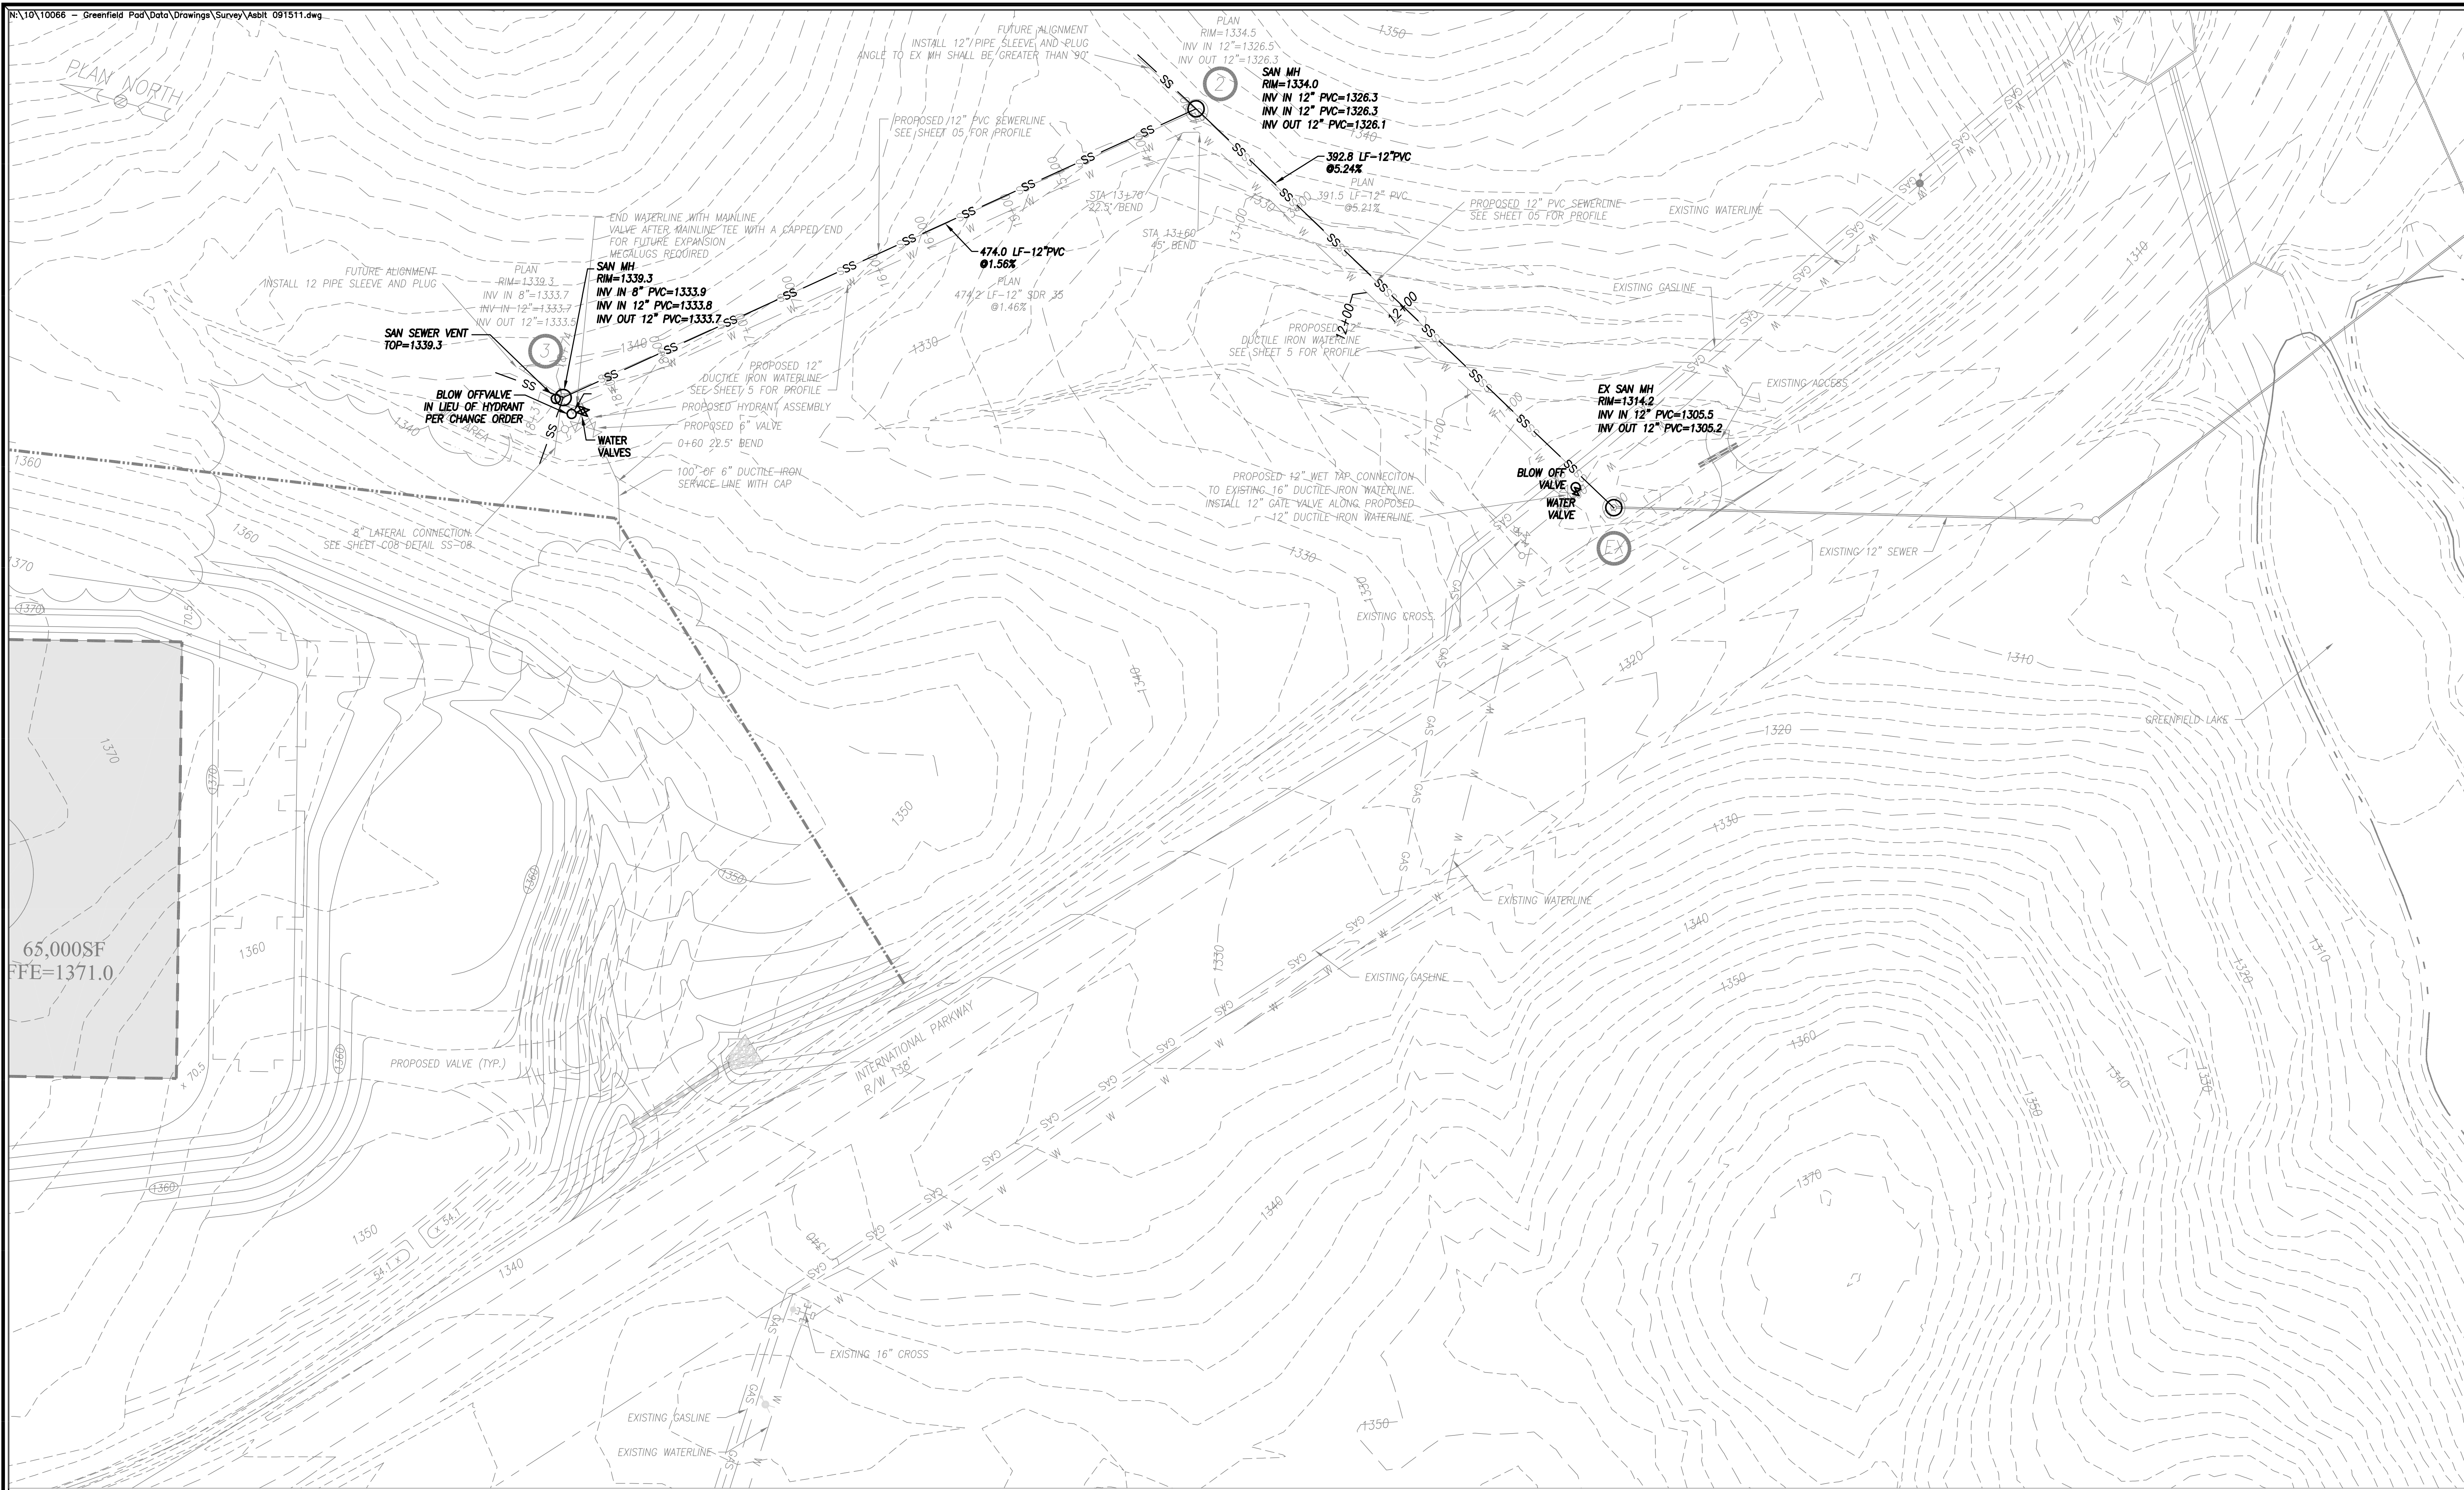

ENGINEERING CONCEPTS, INC.
20 S. ROANOKE ST., PO BOX 619
FINCASTLE, VIRGINIA 24090
540.473.1253 FAX: 540.473.1254

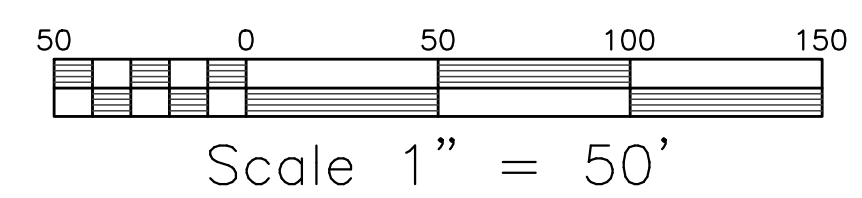

No.	Revision	By	Appd.	Date	Drawn
1	WATERLINE ALIGNMENT	JSC	JSC	6/15/11	SJB
2	WET TAP CONNECTION	JSC	JSC	6/20/11	JSC
					Checked SJB/JSC
					Approved SJB

SANITARY SEWER & WATER ASBUILT
GREENFIELD - PAD MASS GRADING
BOTETOURT COUNTY
UTILITY PLAN

1"=50'
09/19/11
PROJECT: 10066
C04