

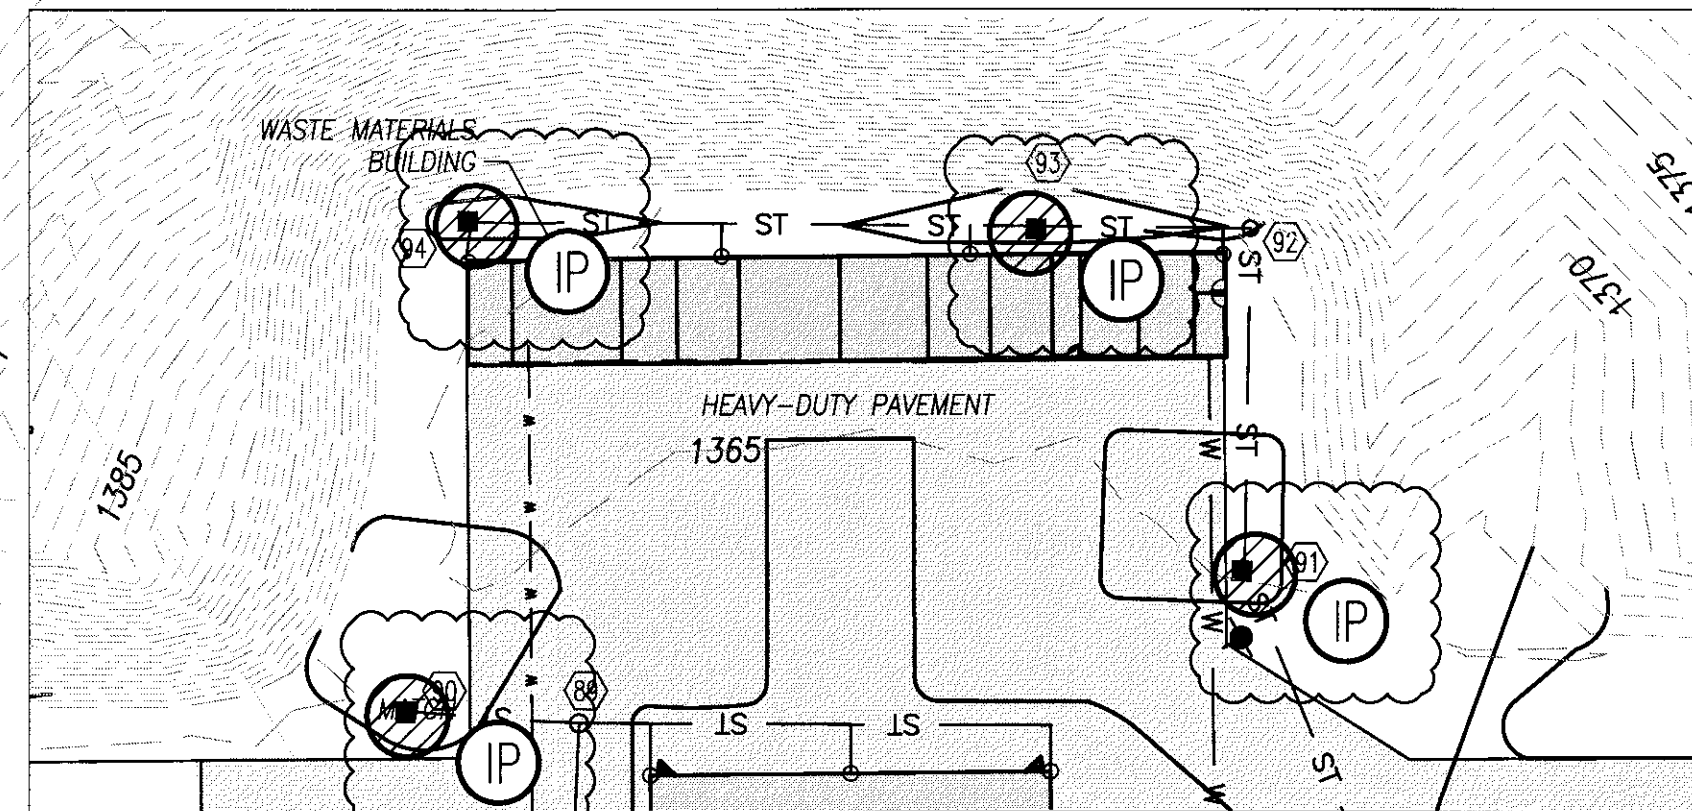


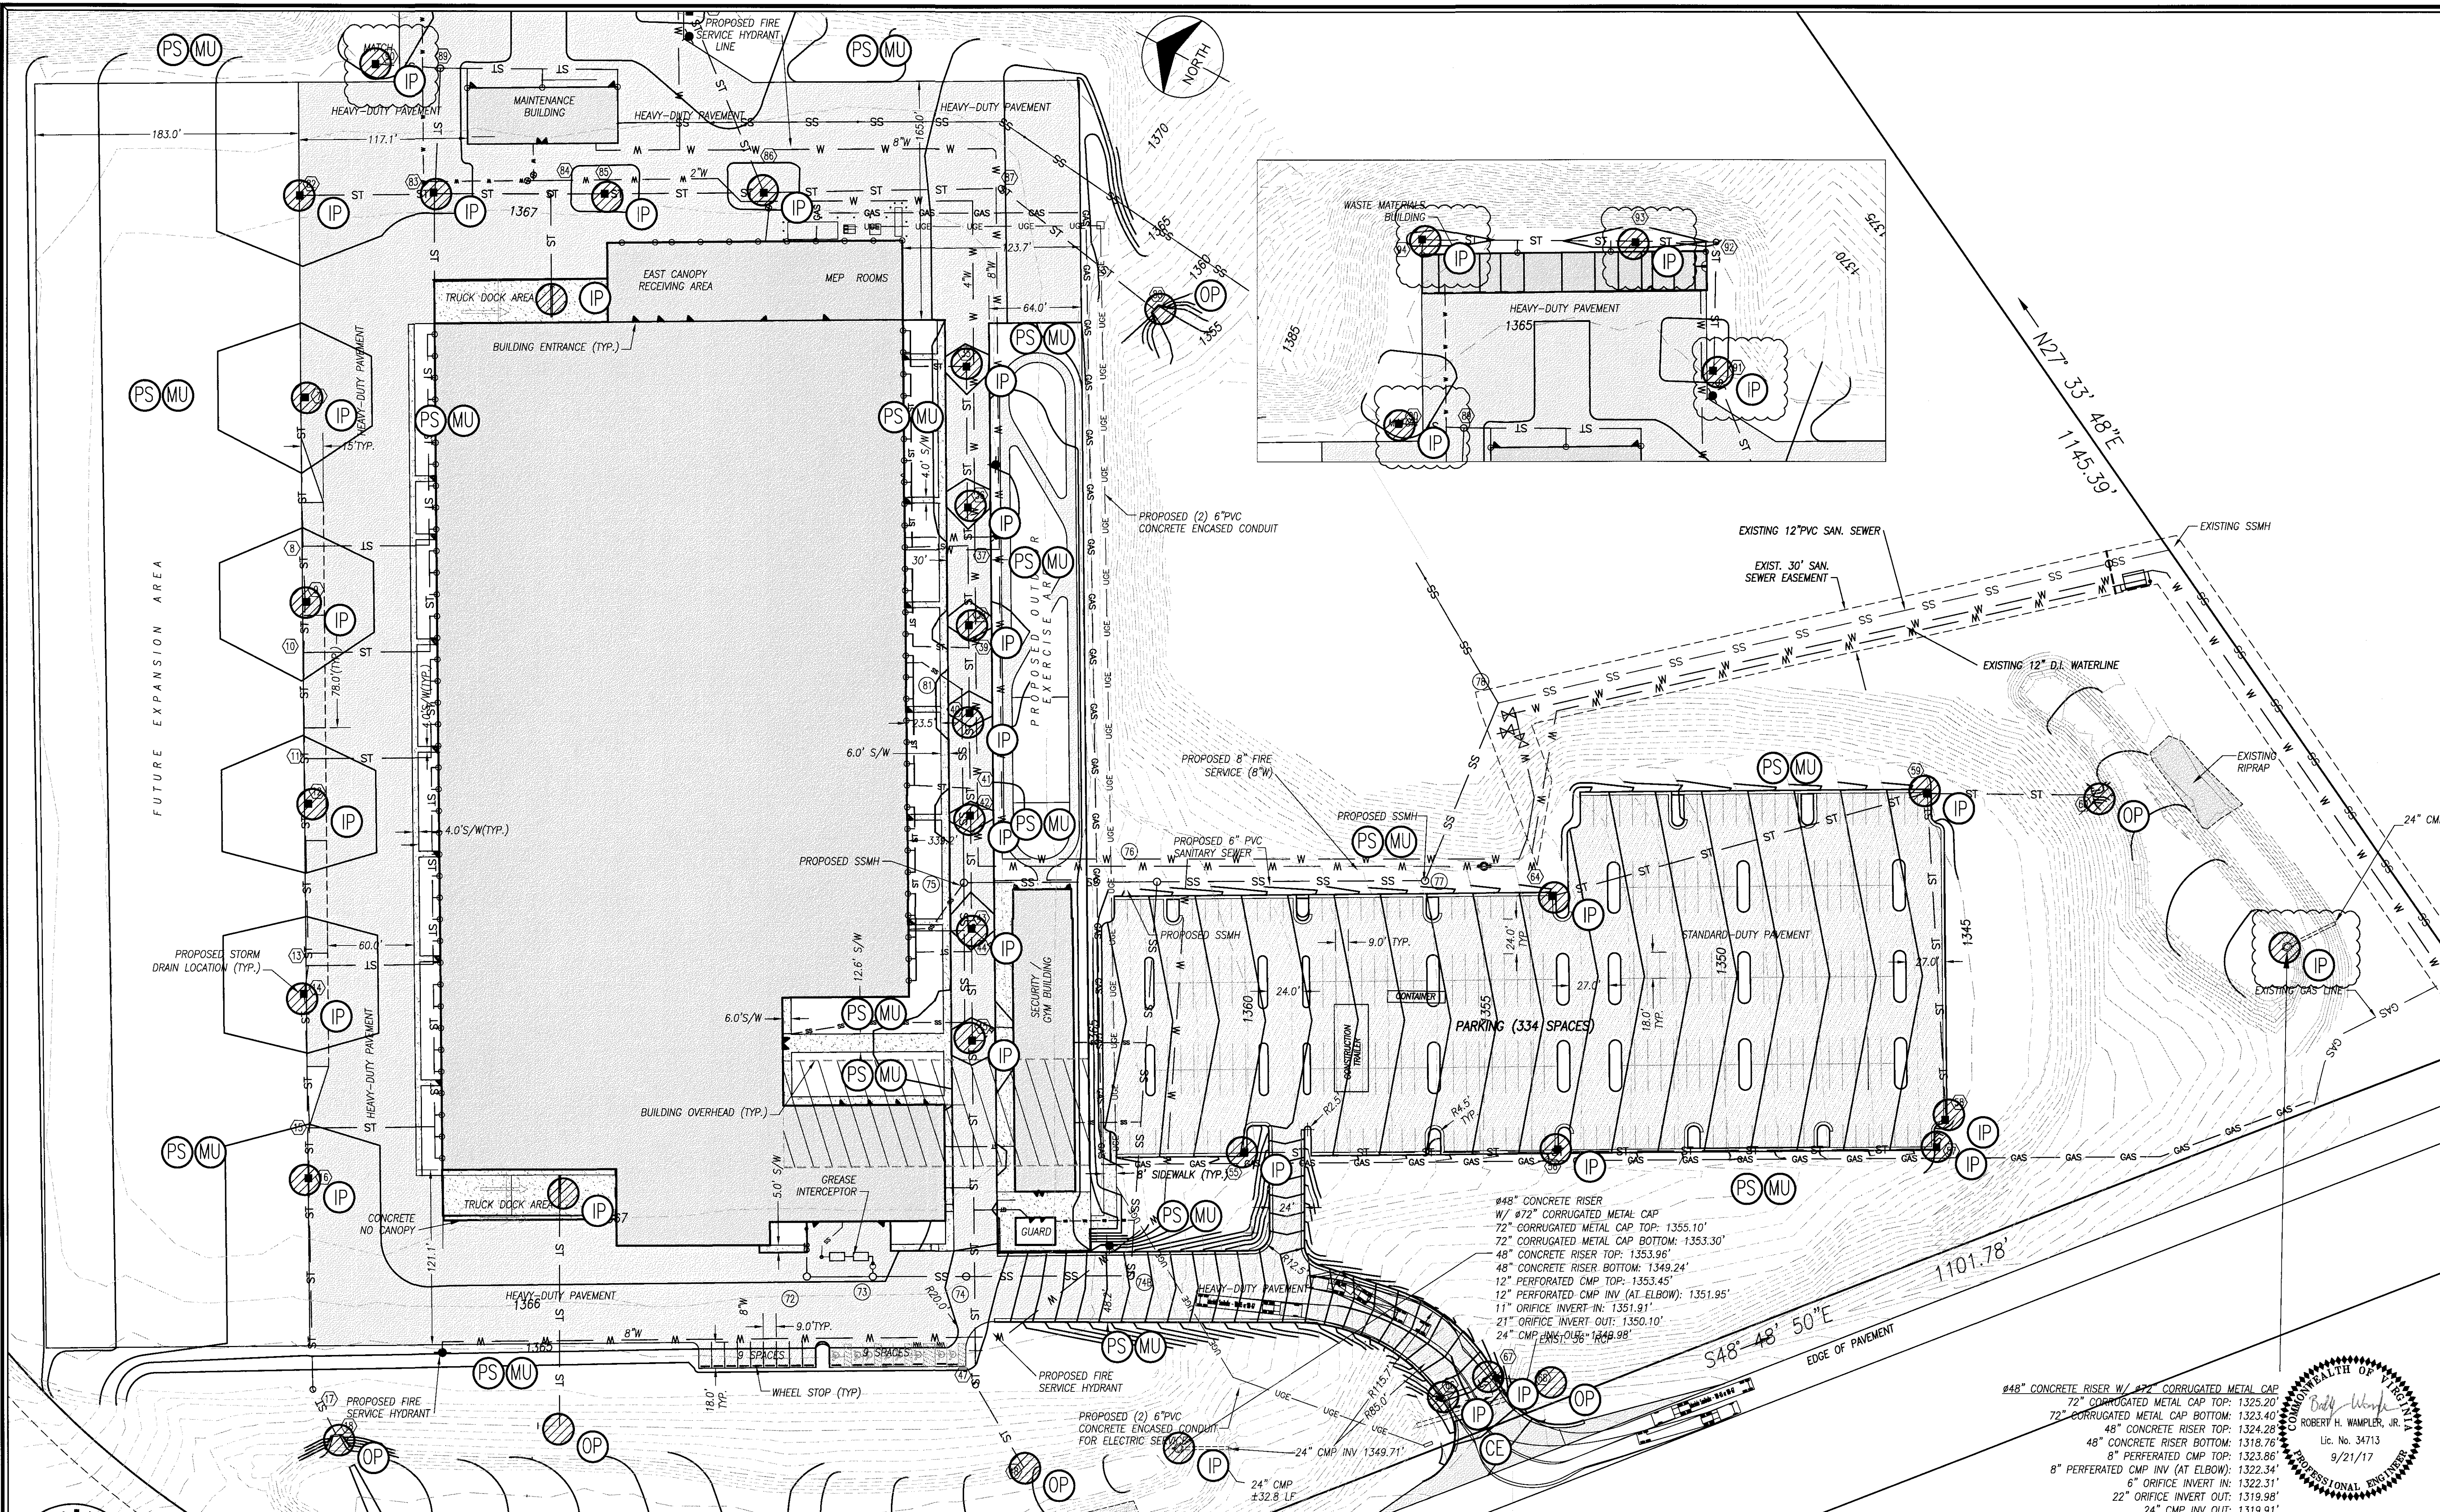

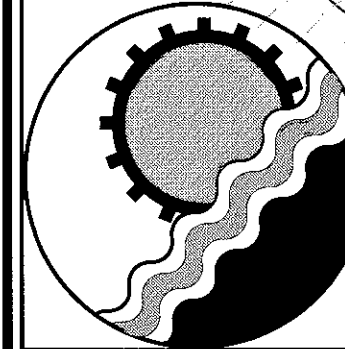

ENGINEERING CONCEPTS, INC.
94 GREENFIELD STREET
DALEVILLE, VIRGINIA 24083
540.473.1253 FAX: 540.473.1254

No.	Revision	By	Appd.	Date	Drawn
1	COORDINATION & COMMENTS	ECI	RHW	6/29/17	ECI
					ECI
					RHW
					RHW

EROSION CONTROL PLAN
ELDOR IGNITION MANUFACTURING
THE BOTETOURT CENTER AT GREENFIELD
BOTETOURT COUNTY - VIRGINIA

SCALE: 1"=50'
September 21, 2017
PROJECT: 16070
C18

