


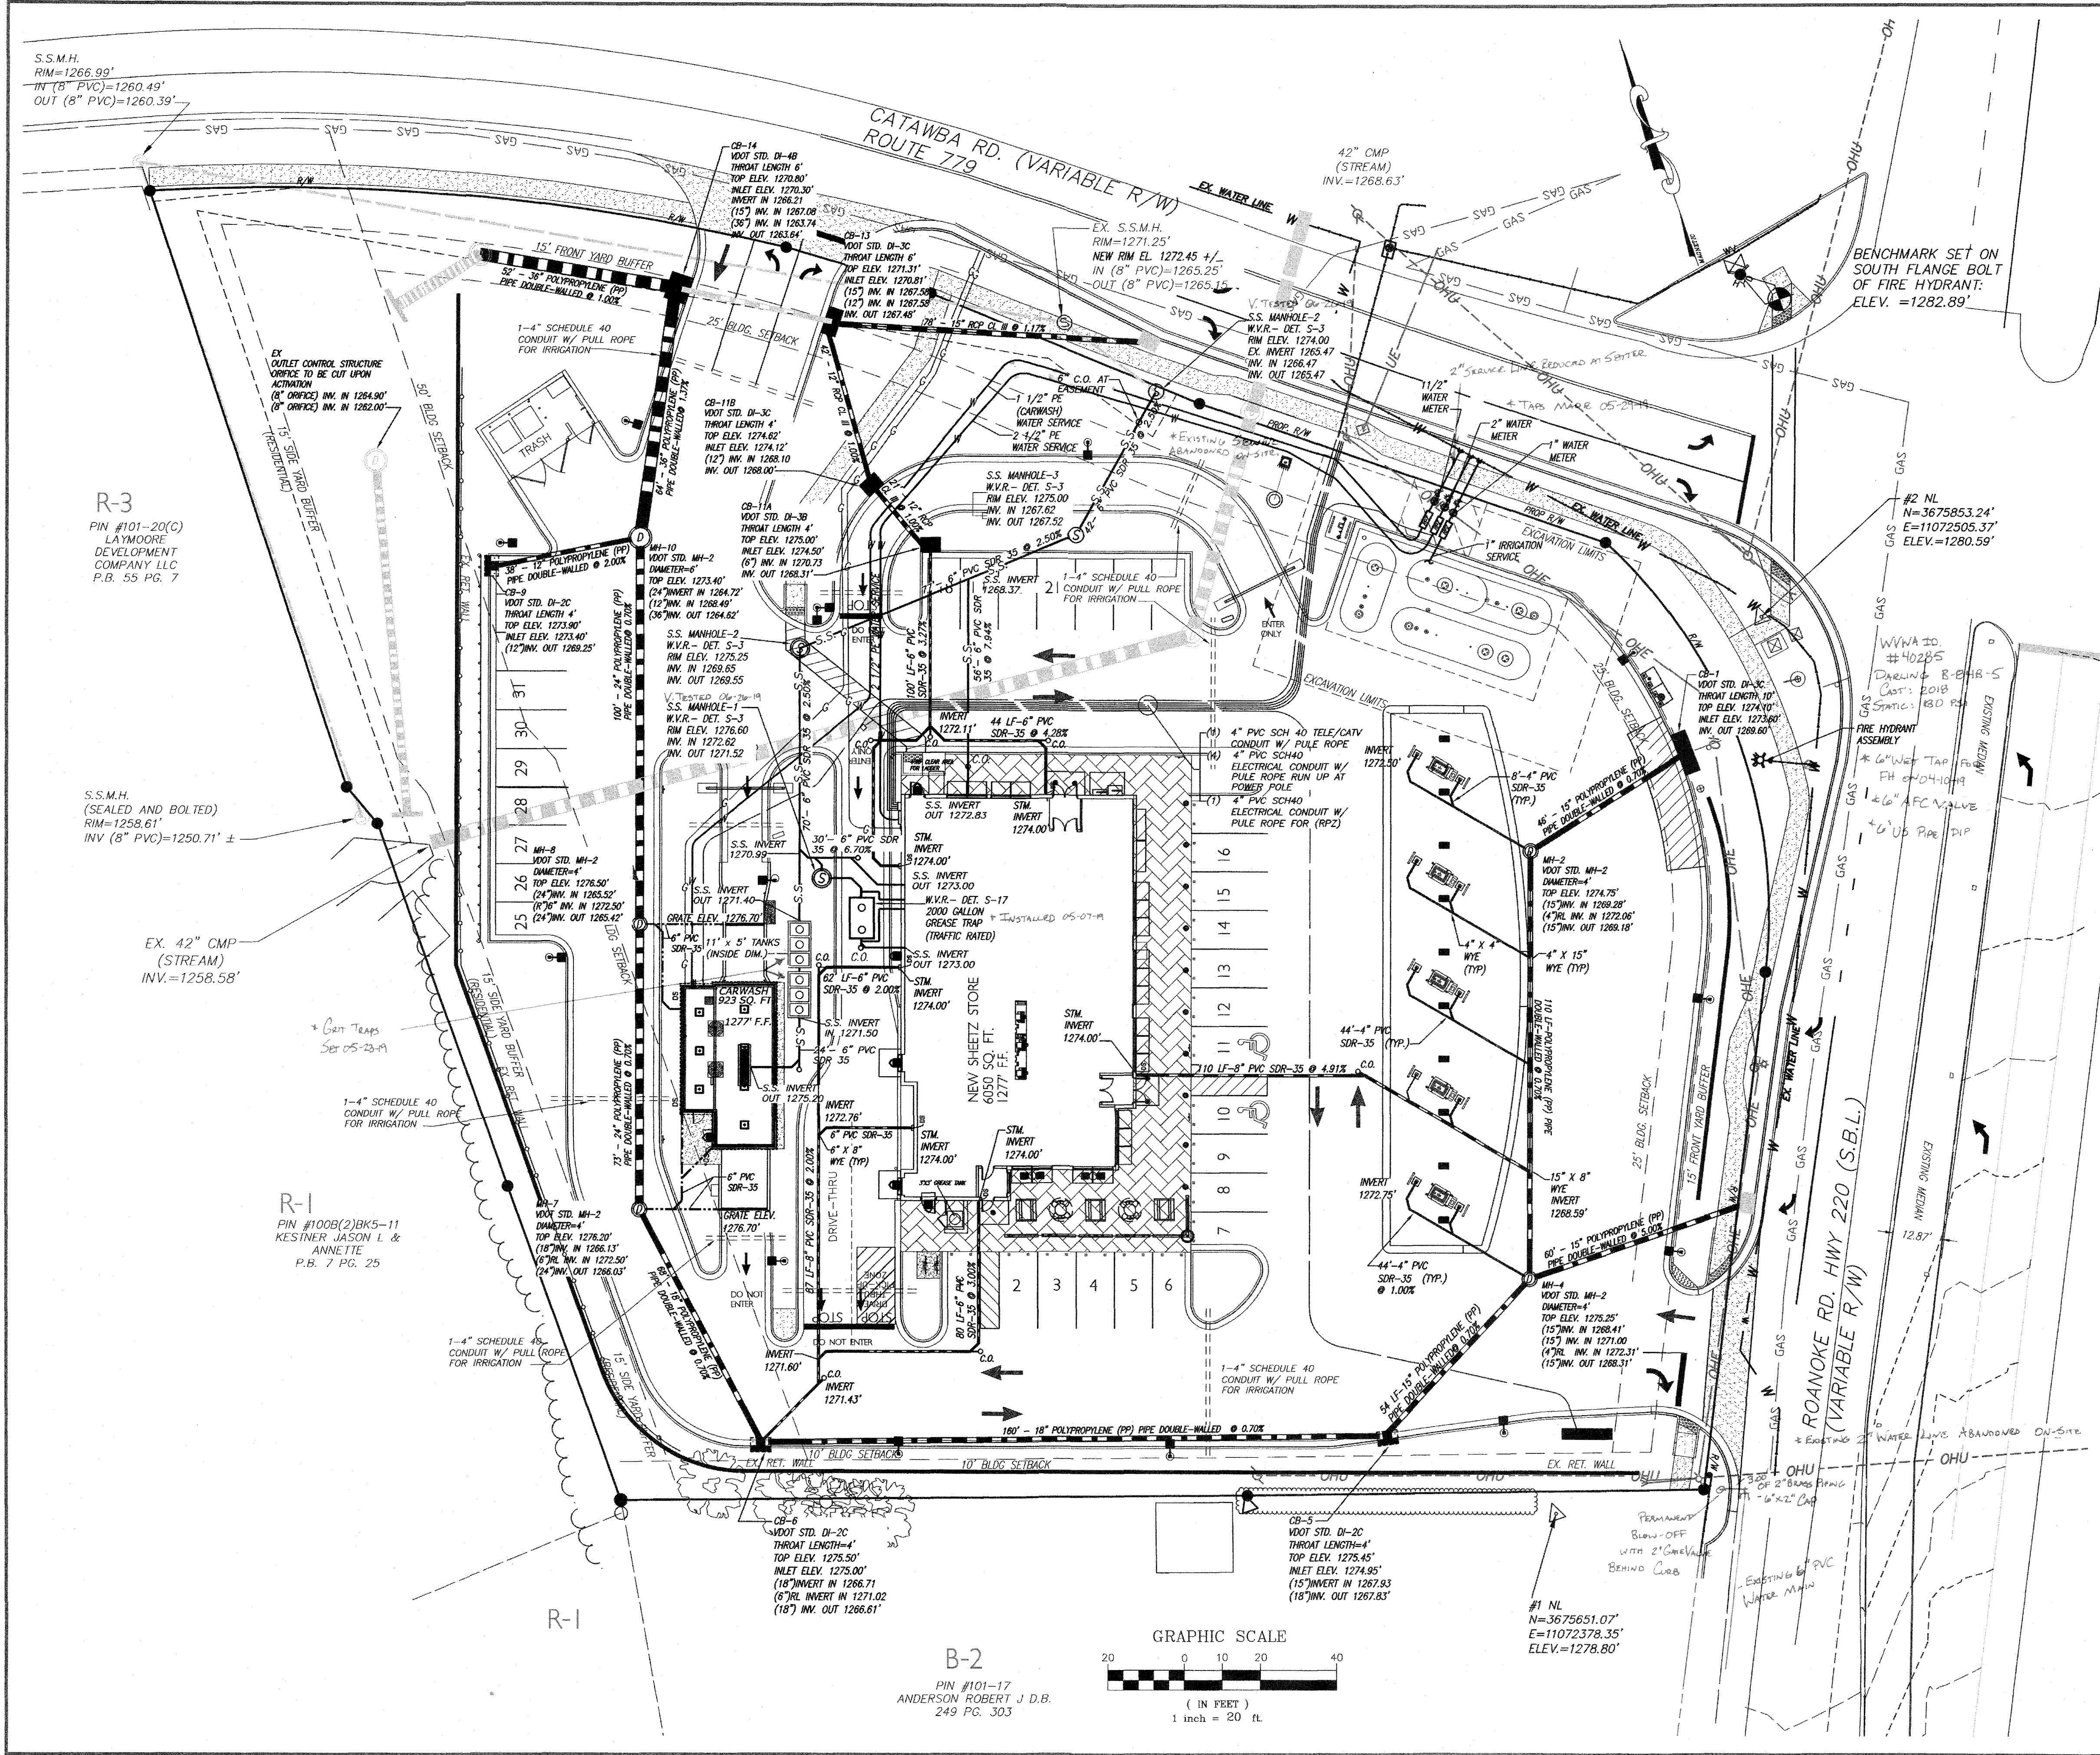

VICINITY MAP

NOT TO SCALE

va811.com
Dig With G.O.O.G.

Virginia 811
811 or
1-800-552-7001

LEED
PROFESSIONALS, P.C.

RIVER RUN EXECUTIVE OFFICES
SUITE-B
110 EXCHANGE STREET
DANVILLE, VA 24541

N.C. LICENSE: # C-2577
VA LICENSE: # 0404-001401

PHONE NO. (434) 792-3680
FAX NO. (434) 792-3685
www.landeng.com

PROPOSED SHEETZ STORE
SHEETZ, INC.
DALEVILLE-BOTETOURT COUNTY, VIRGINIA

UTILITY PLAN

COMMONWEALTH OF VIRGINIA
RYAN WILLIAM GATEWOOD
Lic. No. 055108
7/18/18
PROFESSIONAL ENGINEER

NO.	DATE	DESCRIPTION	BY
1	7-18-18	COUNTY COMMENTS	

Sheet No.
4 of 25

Date: MAY 4, 2018
Scale: 1" = 20'
Project No.
MFG-SZAL17(00)dwg(V-SZAL17-PLAN-1-REV-1)