


UTILITY PLAN NOTES
THIS SHEET IS FOR UTILITY PLAN INFORMATION. REFER TO UTILITY PROFILES AND DETAILS FOR MORE INFORMATION.


FHA: FIRE HYDRANT ASSEMBLY
[MV]: METER VAULT

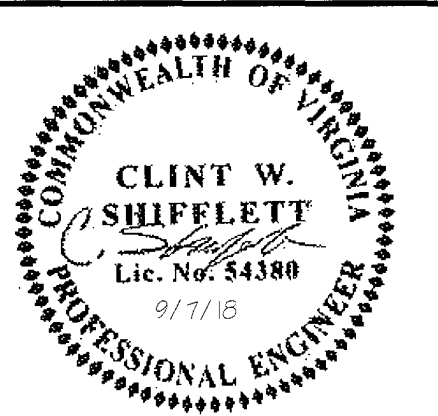

THIS DRAWING PREPARED AT THE
CHARLOTTEVILLE OFFICE
608 Preston Avenue, Suite 200 | Charlottesville, VA 22903
TEL 434.295.5624 FAX 434.295.5317 www.timmons.com

YOUR VISION ACHIEVED THROUGH OURS.

DATE	REVISION DESCRIPTION
2018-05-07	REVISED PER COMMENTS
2018-05-23	
DRAWN BY J WILSON	
DESIGNED BY J WILSON	
CHECKED BY C SHIFFLETT	
SCALE AS SHOWN	

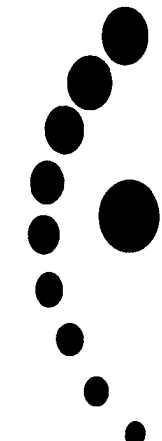


TIMMONS GROUP

THE RESERVE AT DALEVILLE
BOTETOURT COUNTY, VA

UTILITY PLAN

JOB NO.
40062
SHEET NO.
C4.1

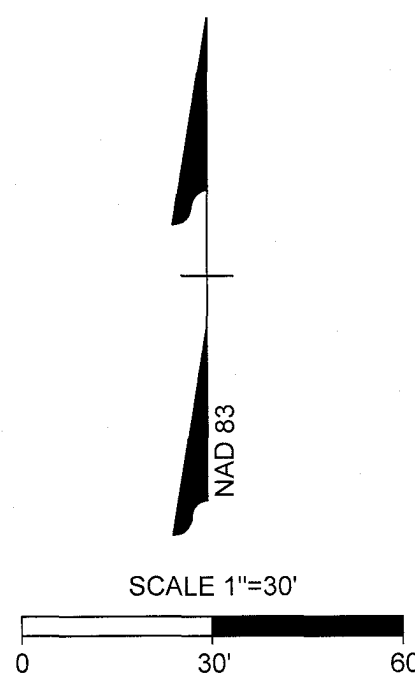

R:\103\0062\Calhoun\The Reserve at Daleville\DWG\Sheet\CD\Grading & Utility Plan.dwg | Plotted on 9/6/2018 4:10 PM | by John Wilson

These plans and associated documents are the exclusive property of TIMMONS GROUP and may not be reproduced in whole or in part and shall not be used for any purpose whatsoever, inclsuave, but not limited to construction, bidding, and/or construction taking without the express written consent of TIMMONS GROUP.