



R:\1034\082-Catbird-Daleville\DWG\Sheet\CD\Grading & UTILITY PLAN.dwg [Plotted on 9/8/2018 4:11 PM] by John Wilson

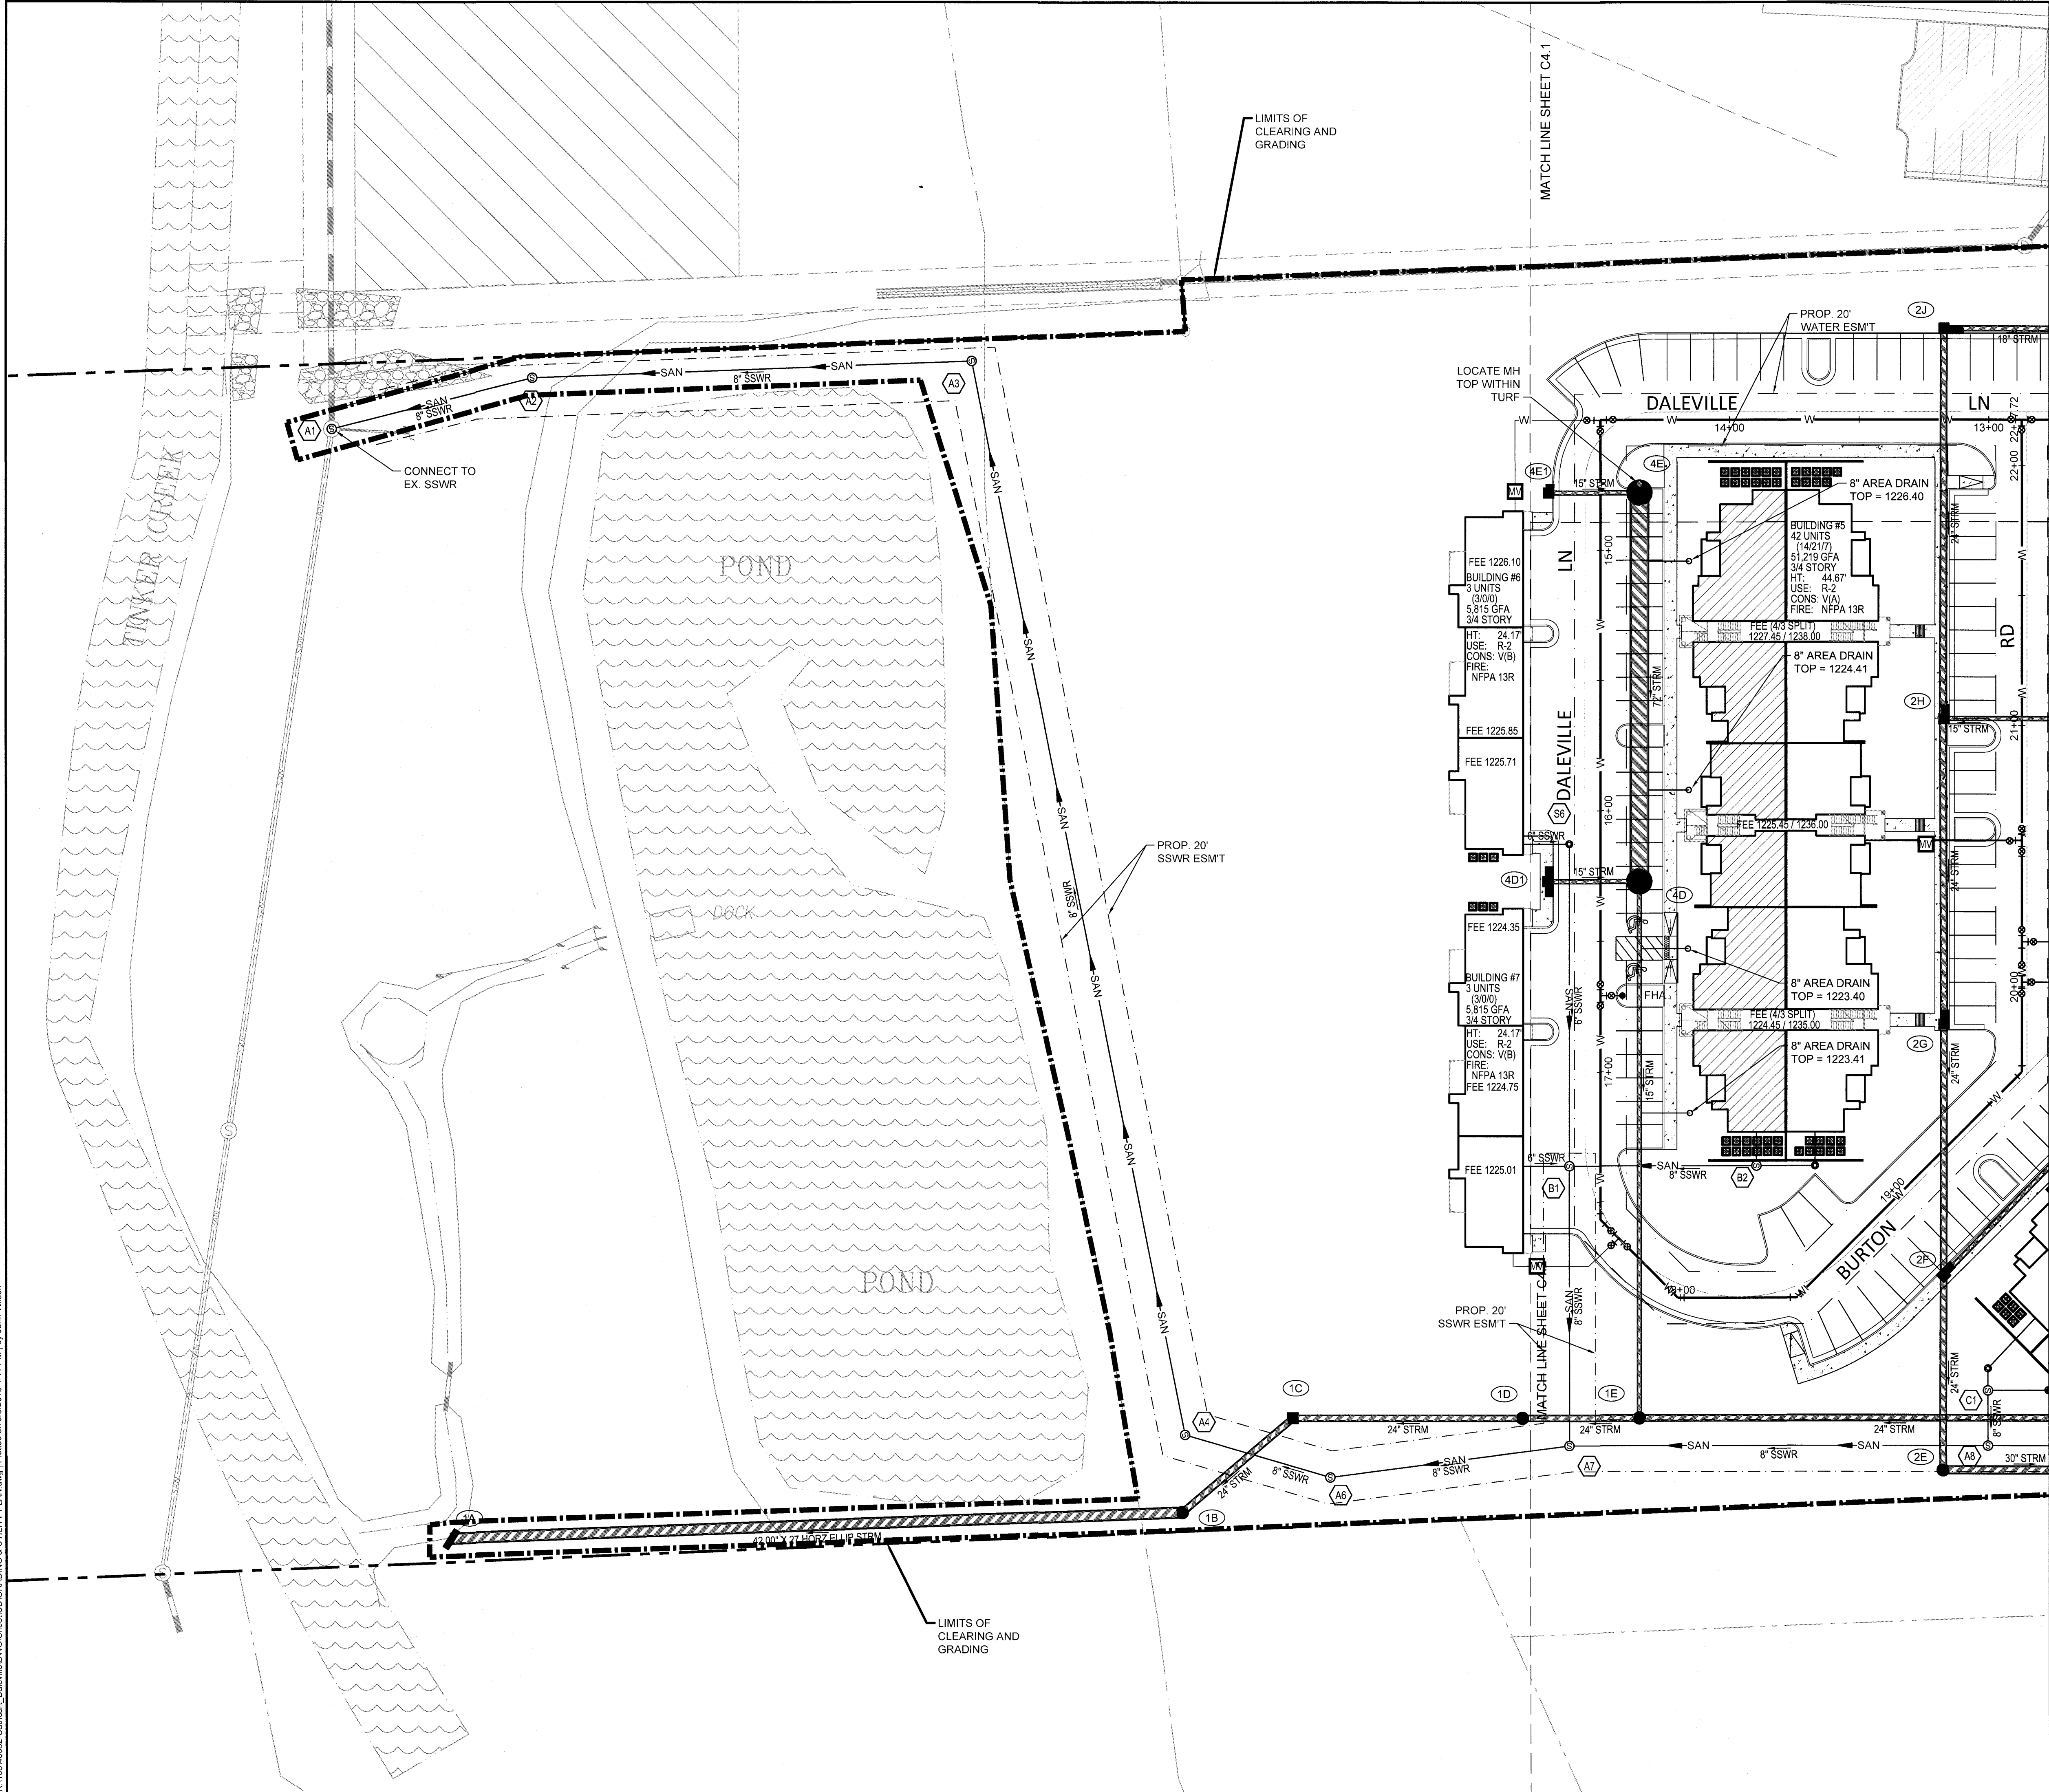

UTILITY PLAN NOTES
THIS SHEET IS FOR UTILITY PLAN INFORMATION. REFER
TO UTILITY PROFILES AND DETAILS FOR MORE
INFORMATION.

FHA: FIRE HYDRANT ASSEMBLY
[MV]: METER VAULT

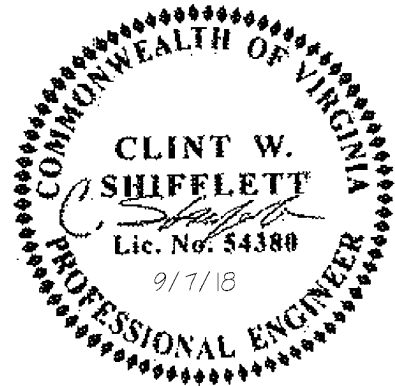

THIS DRAWING PREPARED AT THE
CHARLOTTEVILLE OFFICE
608 Preston Avenue, Suite 200 | Charlottesville, VA 22903
TEL 434.295.5624 FAX 434.295.8317 www.timmons.com

YOUR VISION ACHIEVED THROUGH OURS.

REVISION DESCRIPTION	
DATE	REVISED PER COMMENTS
2018-09-07	

DATE
2018-05-23
DRAWN BY
J WILSON
DESIGNED BY
J WILSON
CHECKED BY
C SHIFFLETT

SCALE
AS SHOWN

TIMMONS GROUP

THE RESERVE AT DALEVILLE

BOTEROURT COUNTY, VA

UTILITY PLAN

JOB NO.
40062
SHEET NO.
C4.3

These plans and associated documents are the exclusive property of TIMMONS GROUP and may not be reproduced in whole or in part and shall not be used for any purpose whatsoever, inclusive, but not limited to construction, bidding, and/or construction taking without the express written consent of TIMMONS GROUP.