

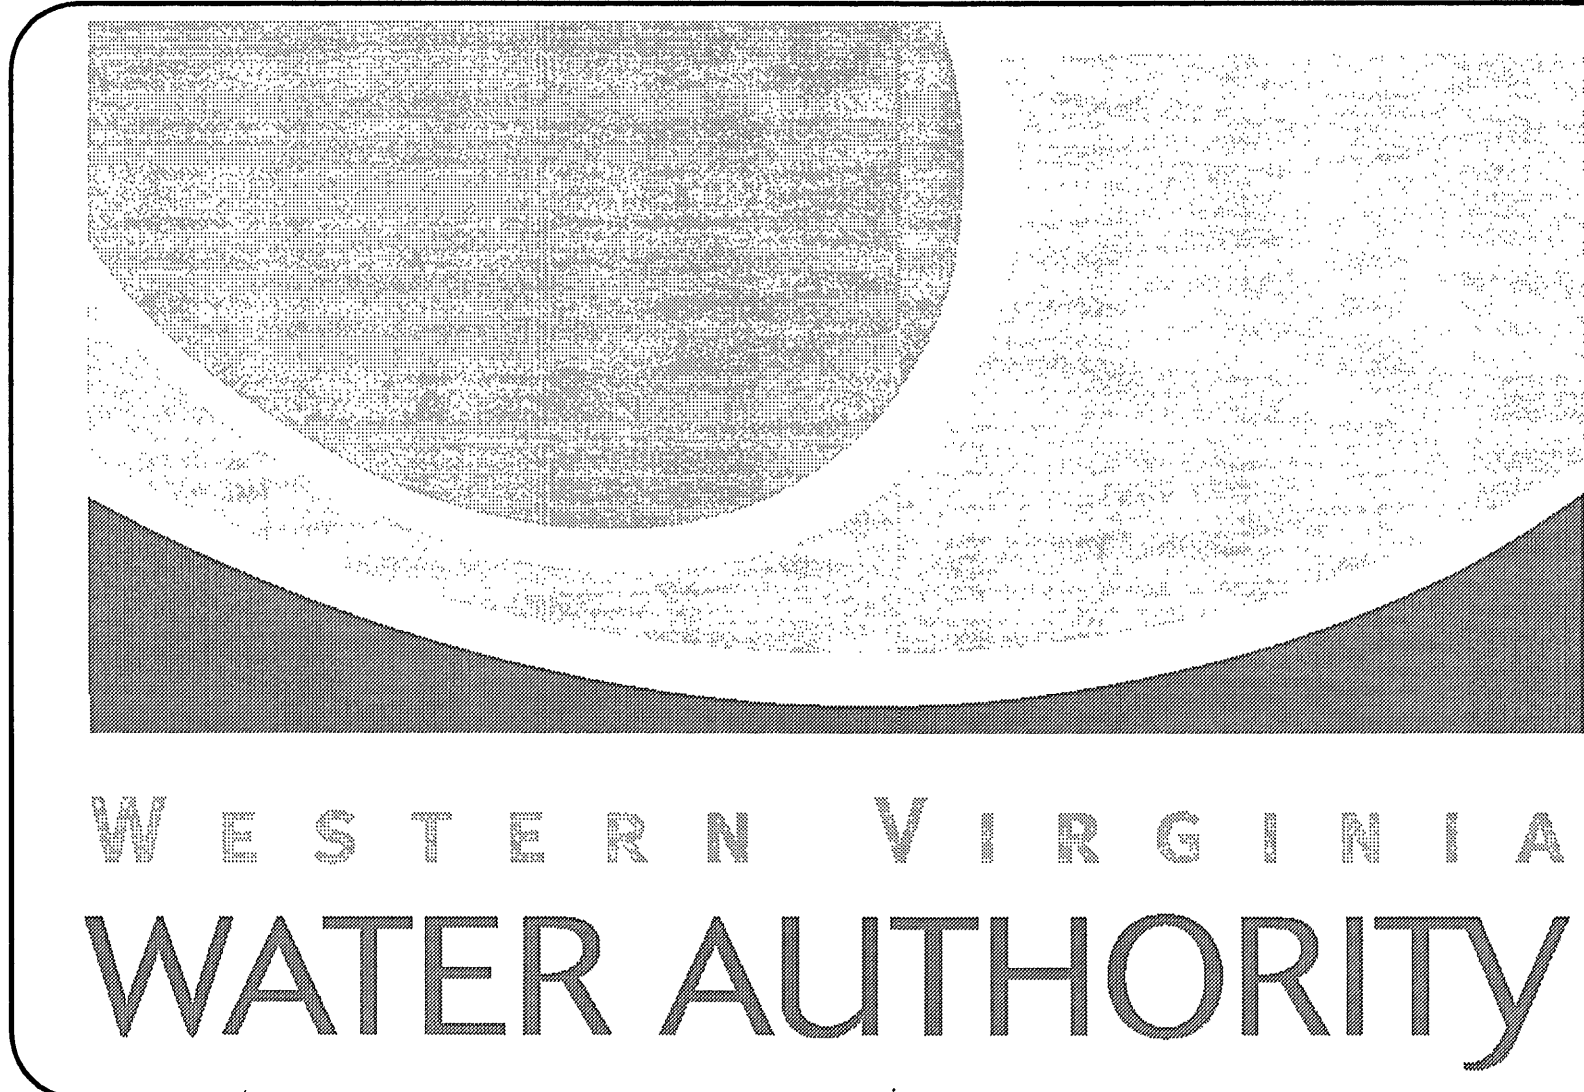


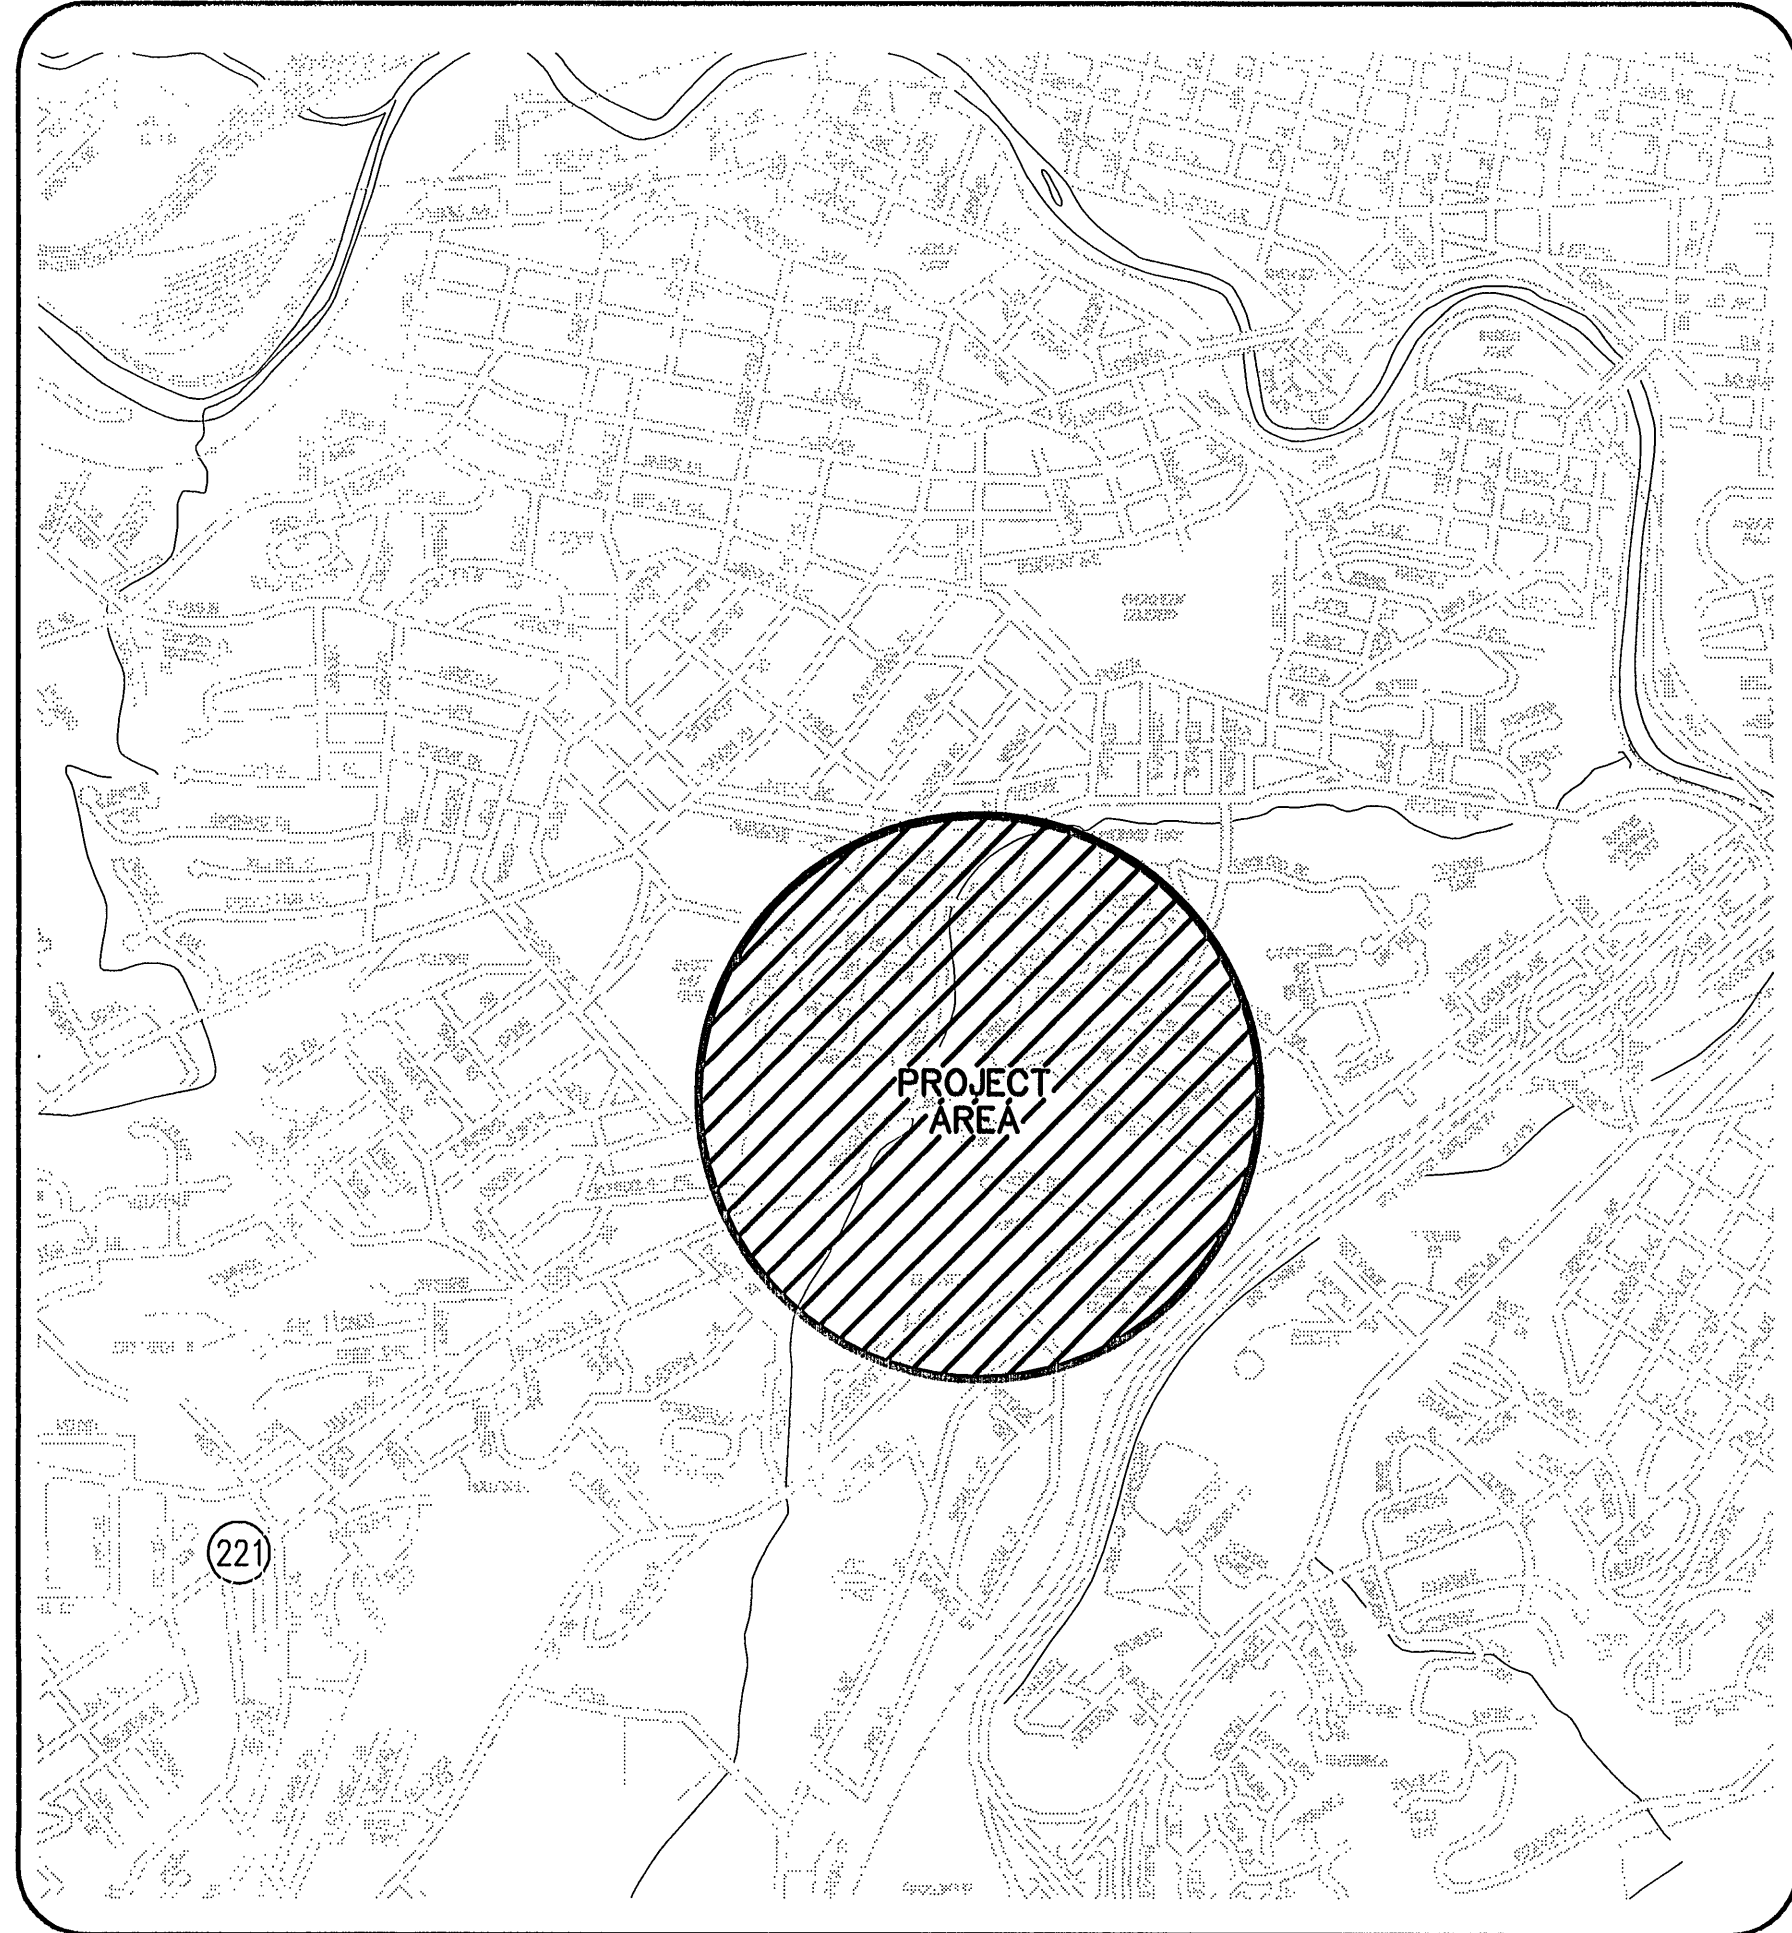

WESTERN VIRGINIA
WATER AUTHORITY
SUITE 200
2012 S. JEFFERSON STREET
ROANOKE, VIRGINIA 24014

INDEX OF SHEETS	
1	COVER SHEET
2	ABBREVIATIONS AND LEGEND
3	SHEET INDEX AND GENERAL NOTES
4	PLAN AND PROFILE- 12" WATERLINE
5	PLAN AND PROFILE- 12" WATERLINE
6	PLAN AND PROFILE- 12" WATERLINE
7	PLAN AND PROFILE- 12" WATERLINE
8	PLAN AND PROFILE- 12" WATERLINE

CONSULTING ENGINEERS

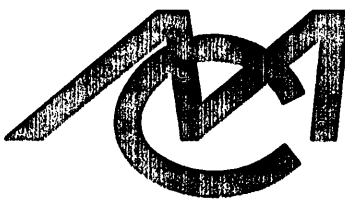


Mattern & Craig, Inc.

CONSULTING ENGINEERS
SURVEYORS

701 FIRST STREET, S.W.
ROANOKE, VIRGINIA 24016
(540) 345-9342
(540) 345-7691 FAX

COMMISSION NUMBER: 2120B

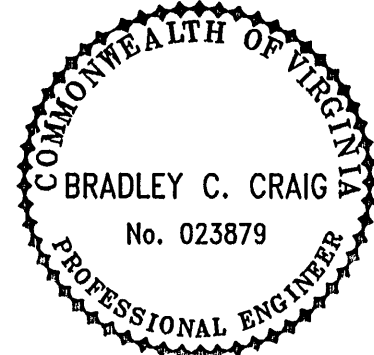

PROJECT NAME

BRAMBLETON AVE.
WATER LINE PROJECT
ROANOKE, VIRGINIA

PROJECT NUMBER: 04-05

REVISION BY	DESCRIPTION:	DATE
REVISION BY	DESCRIPTION:	DATE
REVISION BY	DESCRIPTION:	DATE
REVISION BY	DESCRIPTION:	DATE

APPROVED FOR CONSTRUCTION

MANAGER OF ENGINEERING SERVICES	DATE
AUTHORITY DIRECTOR	DATE
	DATE
	DATE
	DATE

ADVERTISED DATE: _____

SET NUMBER: _____

SHEET NUMBER: 1 OF 8