


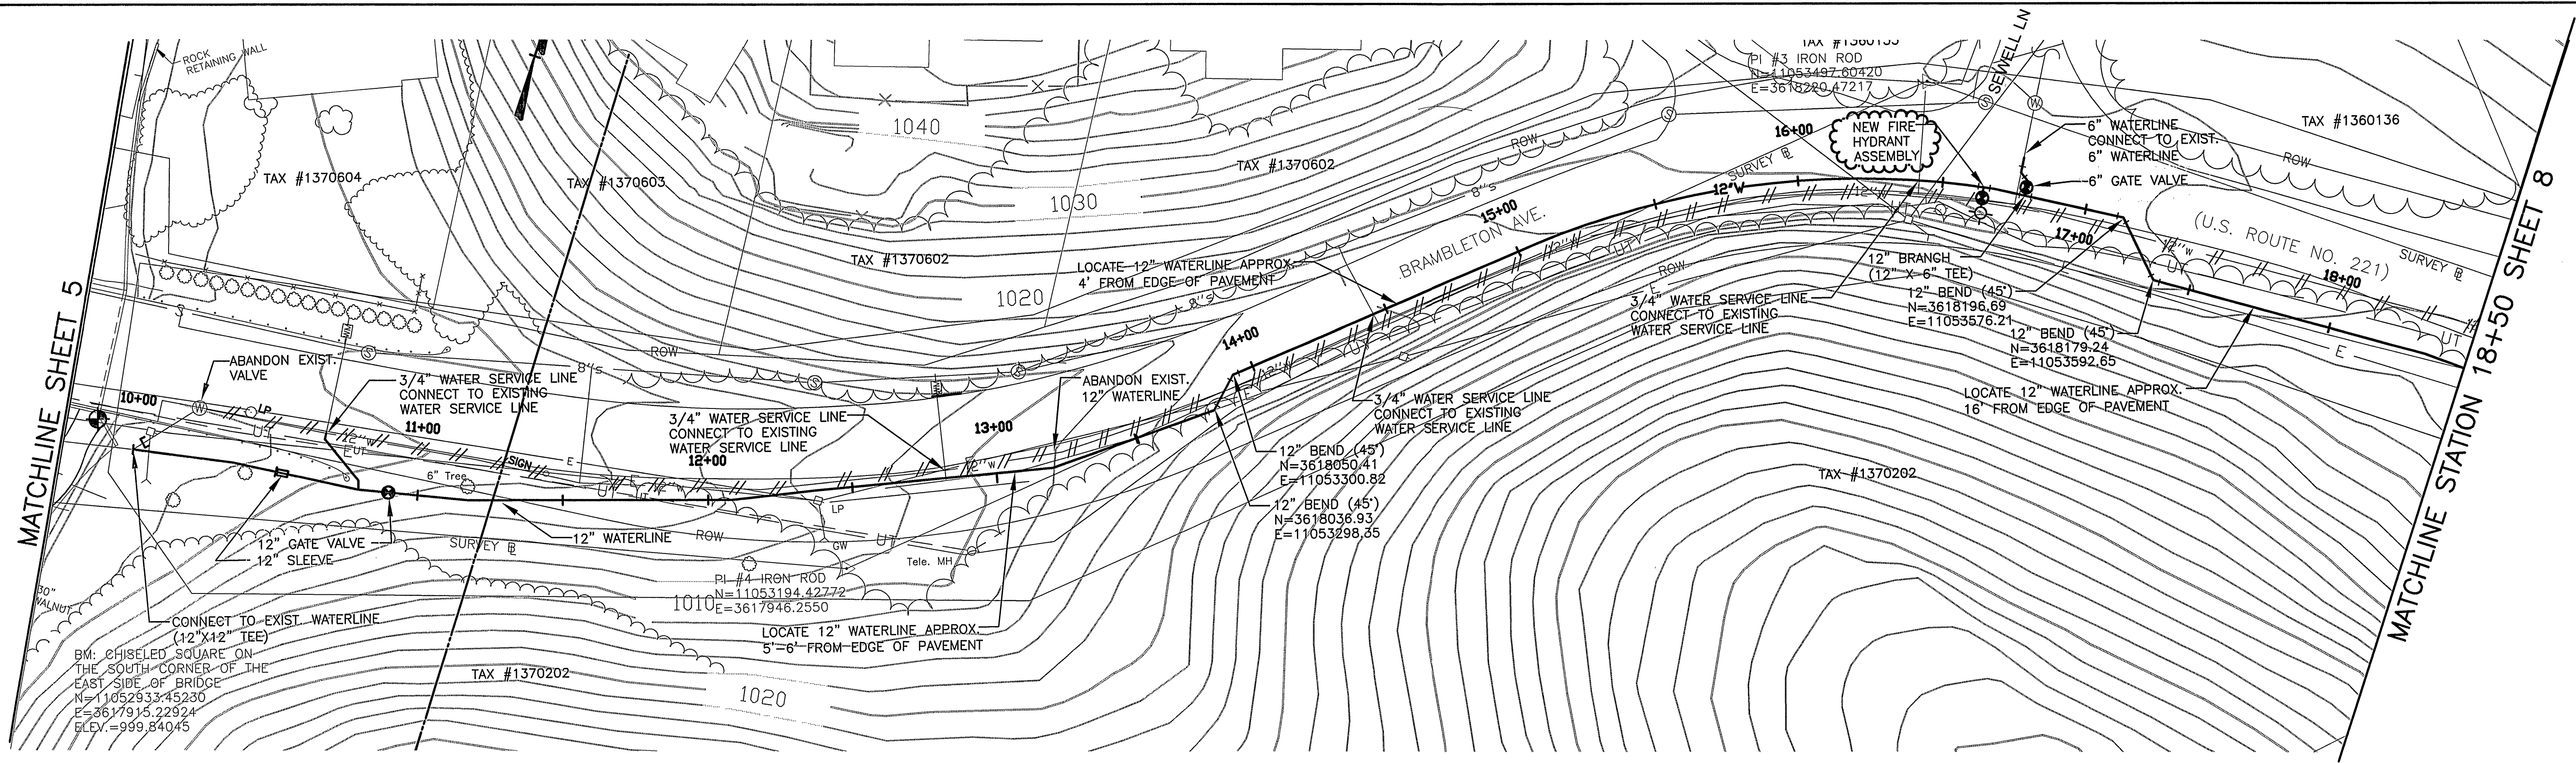


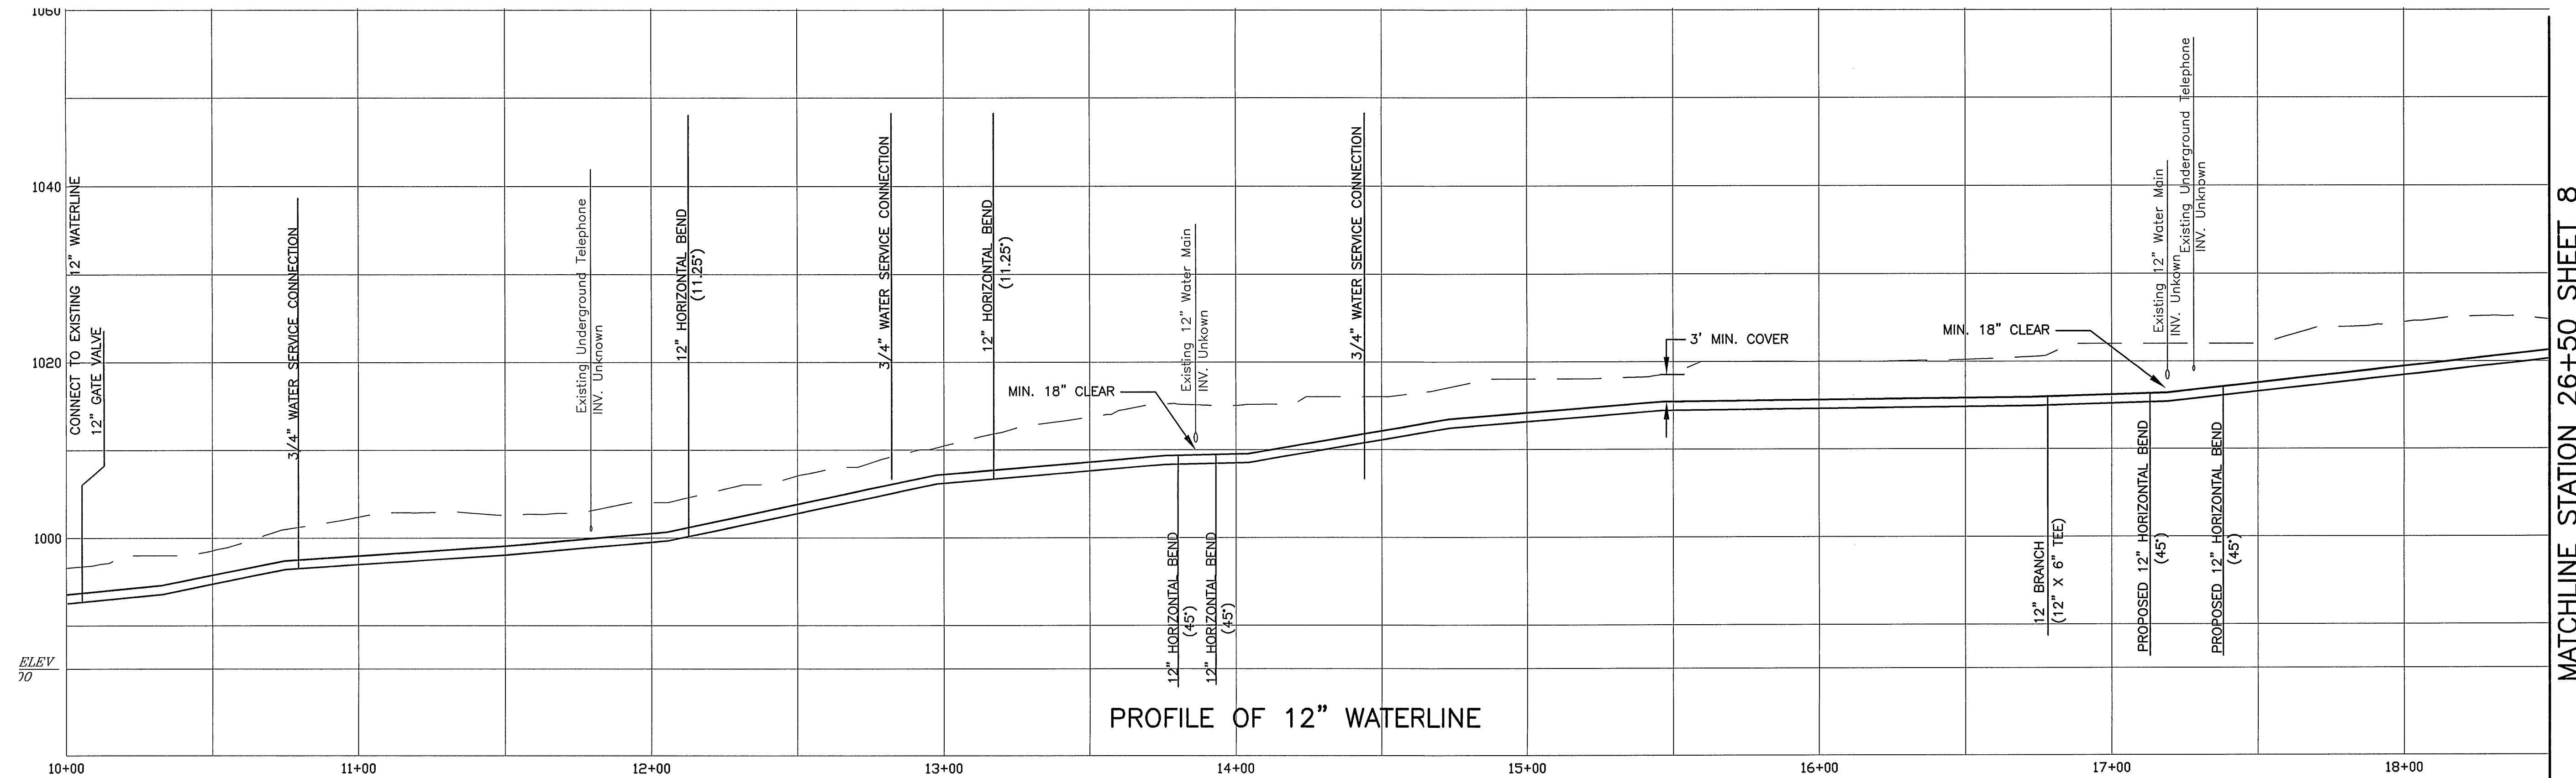

NOTE:
WATERLINE APPURTENANCES NOT
ON MAINLINE ARE NOT PROFILED.
VERTICAL BENDS NOT SHOWN IN
PLAN VIEW.

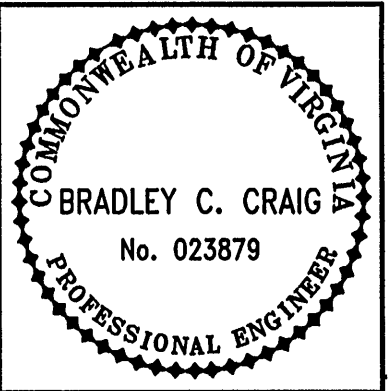

RECORD DRAWINGS

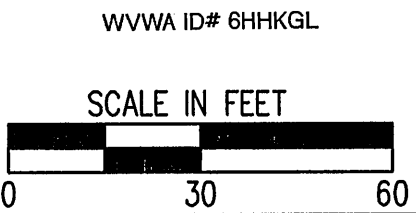

Revisions	Date

Issue Date: 6/11/04	Drawn By: DBL	Designed By: BCC	Checked By: BCC	Date: 6/10/04
------------------------	---------------	------------------	-----------------	---------------



Matter & Craig

CONSULTING ENGINEERS • SURVEYORS

701 FIRST STREET, S.W.
ROANOKE, VIRGINIA 24016
(540) 345-7882
FAX (540) 345-7881

BRAMBLETON AVE. WATER LINE PROJECT

PLAN AND PROFILE

12" WATERLINE

ROANOKE, VIRGINIA

Vertical Scale:
1" = 10'

Horizontal Scale:
1" = 30'

Commission Number:
2120B

Sheet No.:
6