
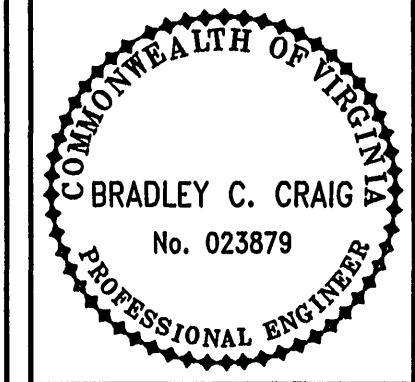
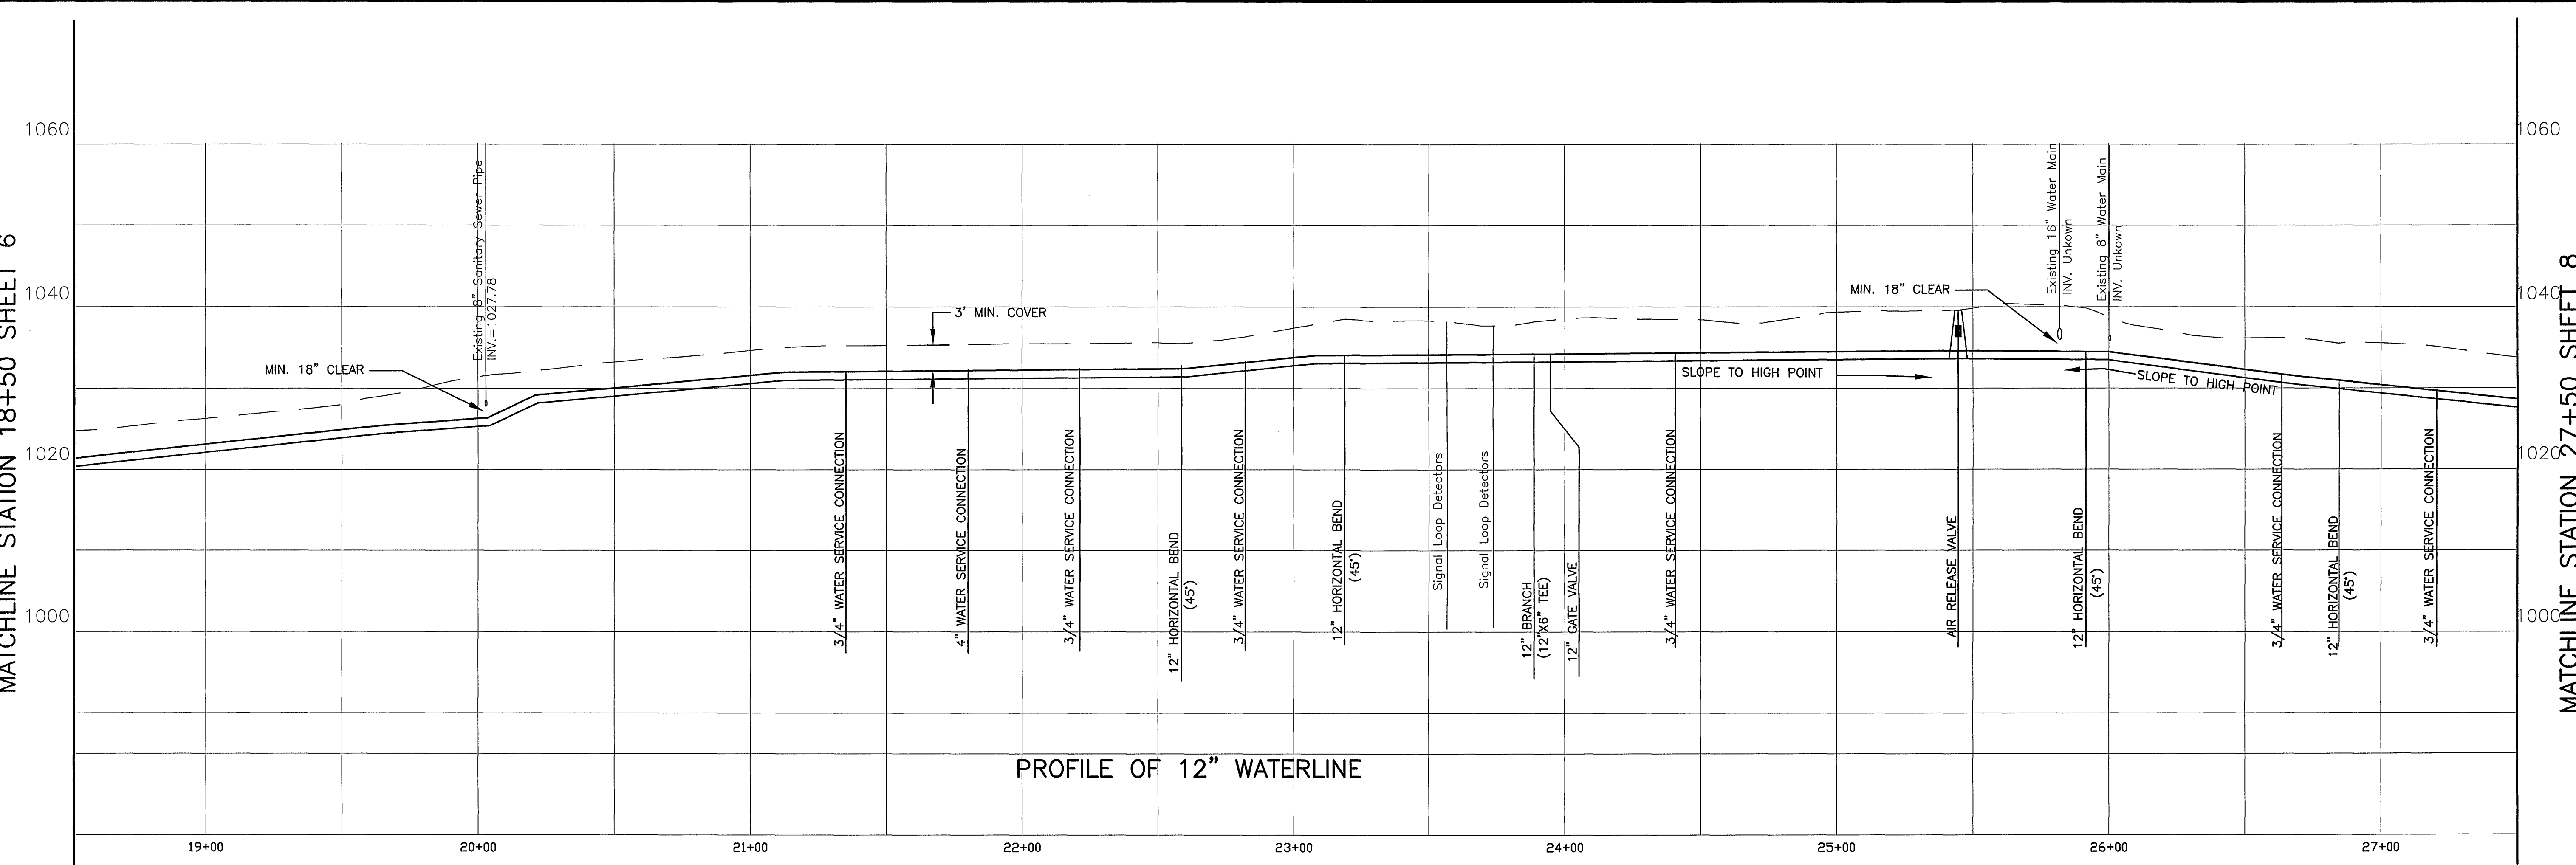


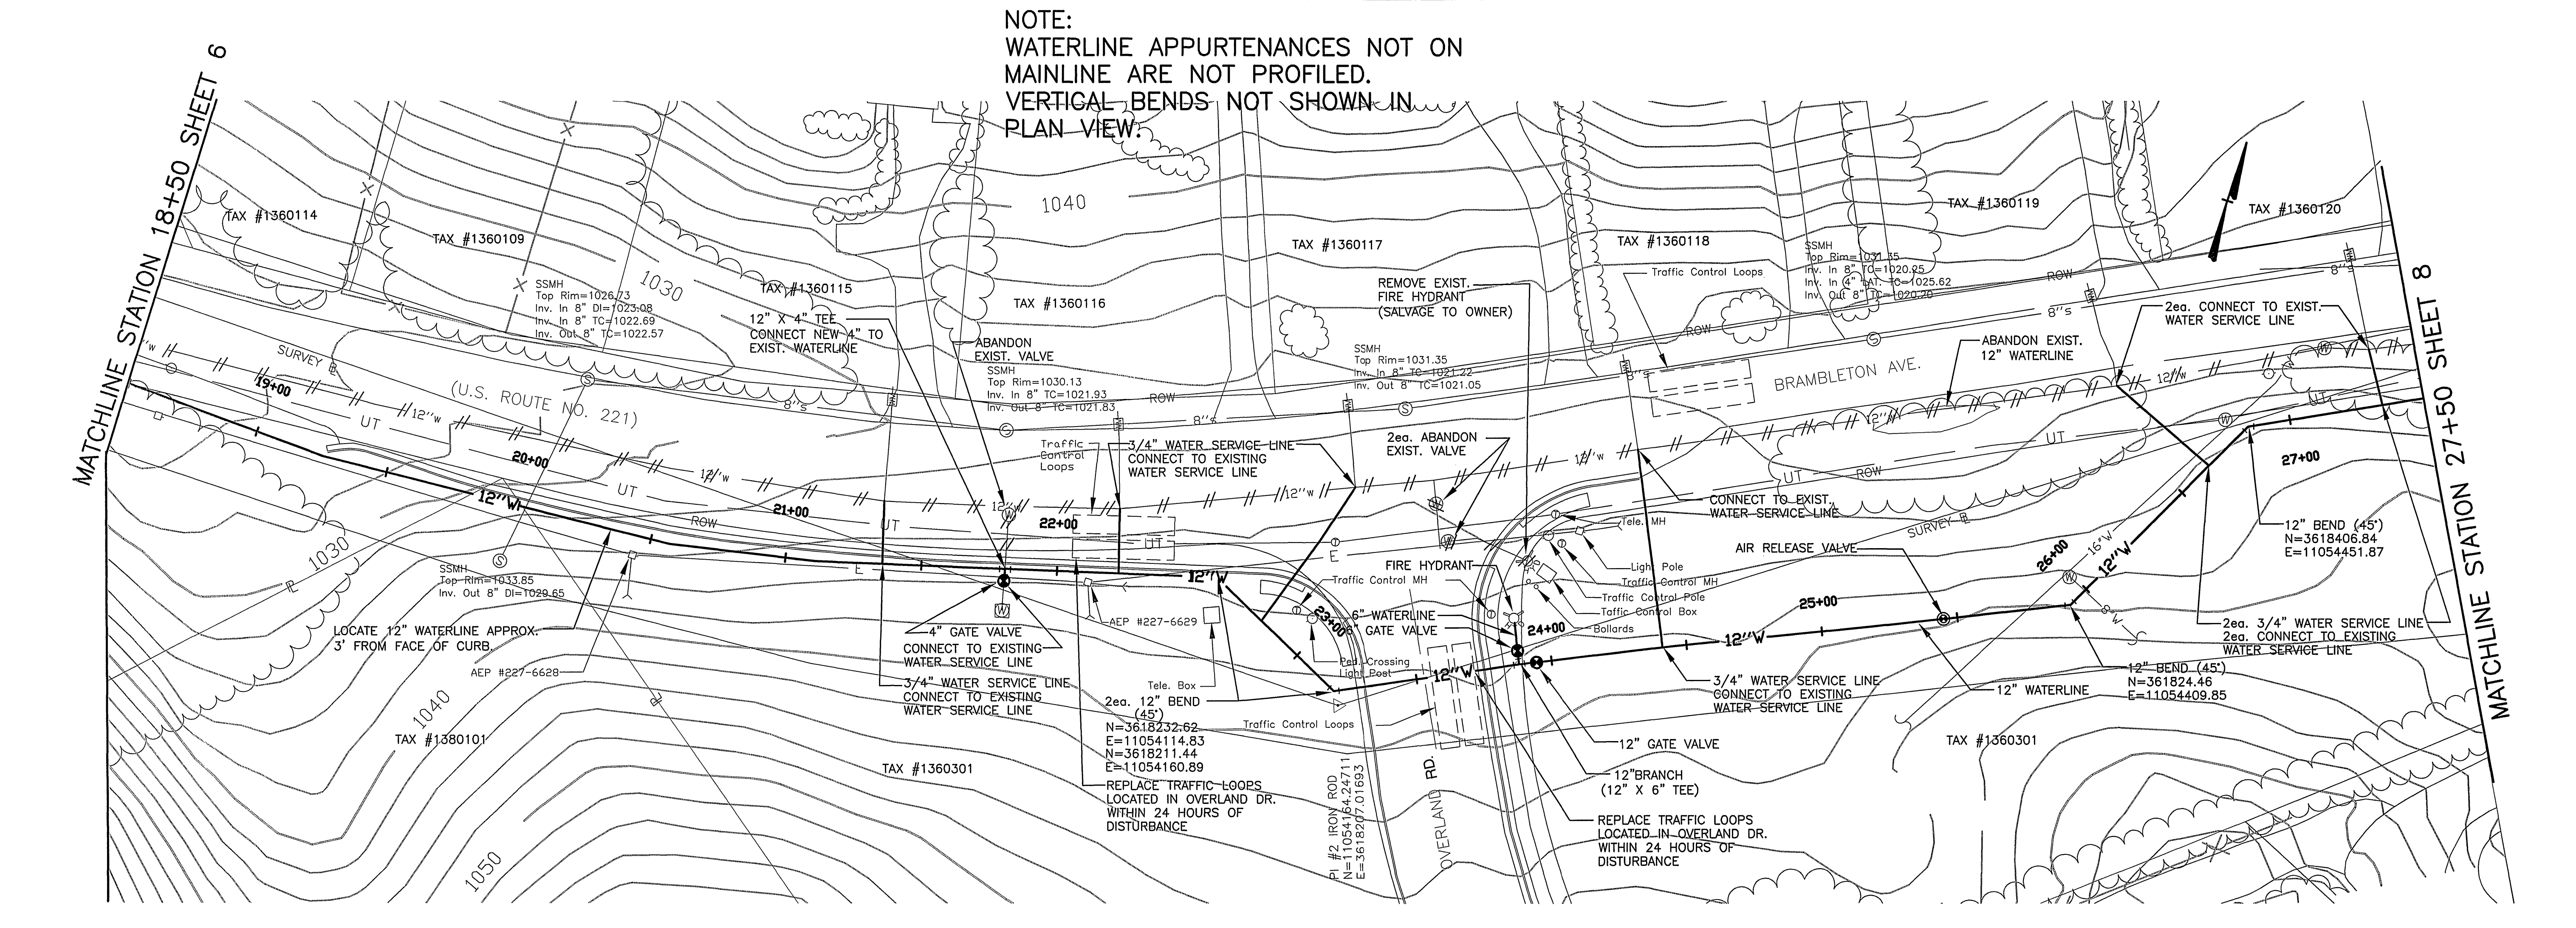

Revisions	Date

Issue Date: 6/11/04	Drawn By: DBL
Designed By: BCC	Checked By: BCC
Date: 6/10/04	

Mattem & Craig
CONSULTING ENGINEERS • SURVEYORS

701 FIRST STREET, S.W.
ROANOKE, VIRGINIA 24016
(540) 345-3542
FAX (540) 345-7691

BRAMBLETON AVE. WATER LINE PROJECT

**PLAN AND PROFILE
12" WATERLINE**

ROANOKE, VIRGINIA

Vertical Scale:
1" = 10'

Horizontal Scale:
1" = 30'

Commission Number:
2120B

Sheet No.:
7