



NOTE:
WATERLINE APPURTENANCES NOT ON
MAINLINE ARE NOT PROFILED.
VERTICAL BENDS NOT SHOWN IN
PLAN VIEW.


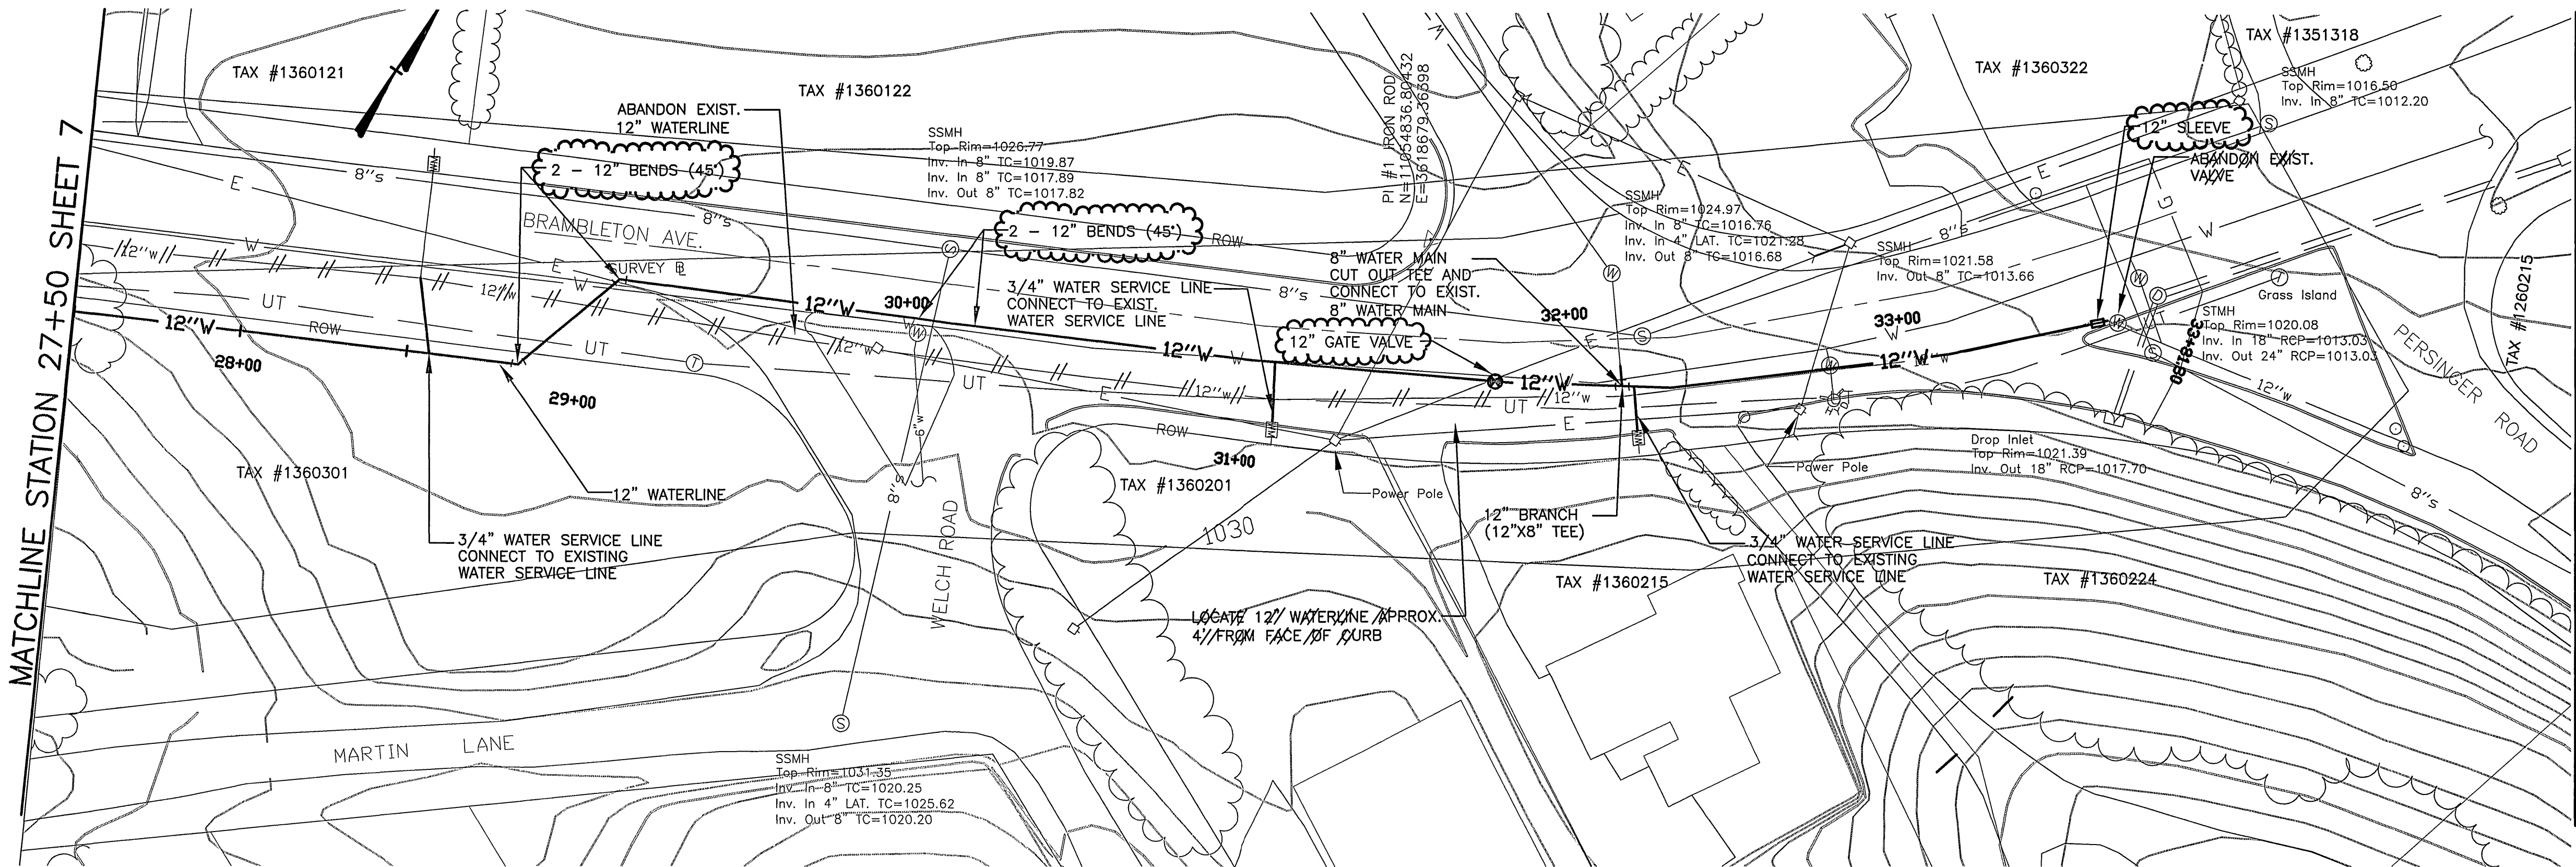


MATCHLINE STATION 27+50 SHEET 7

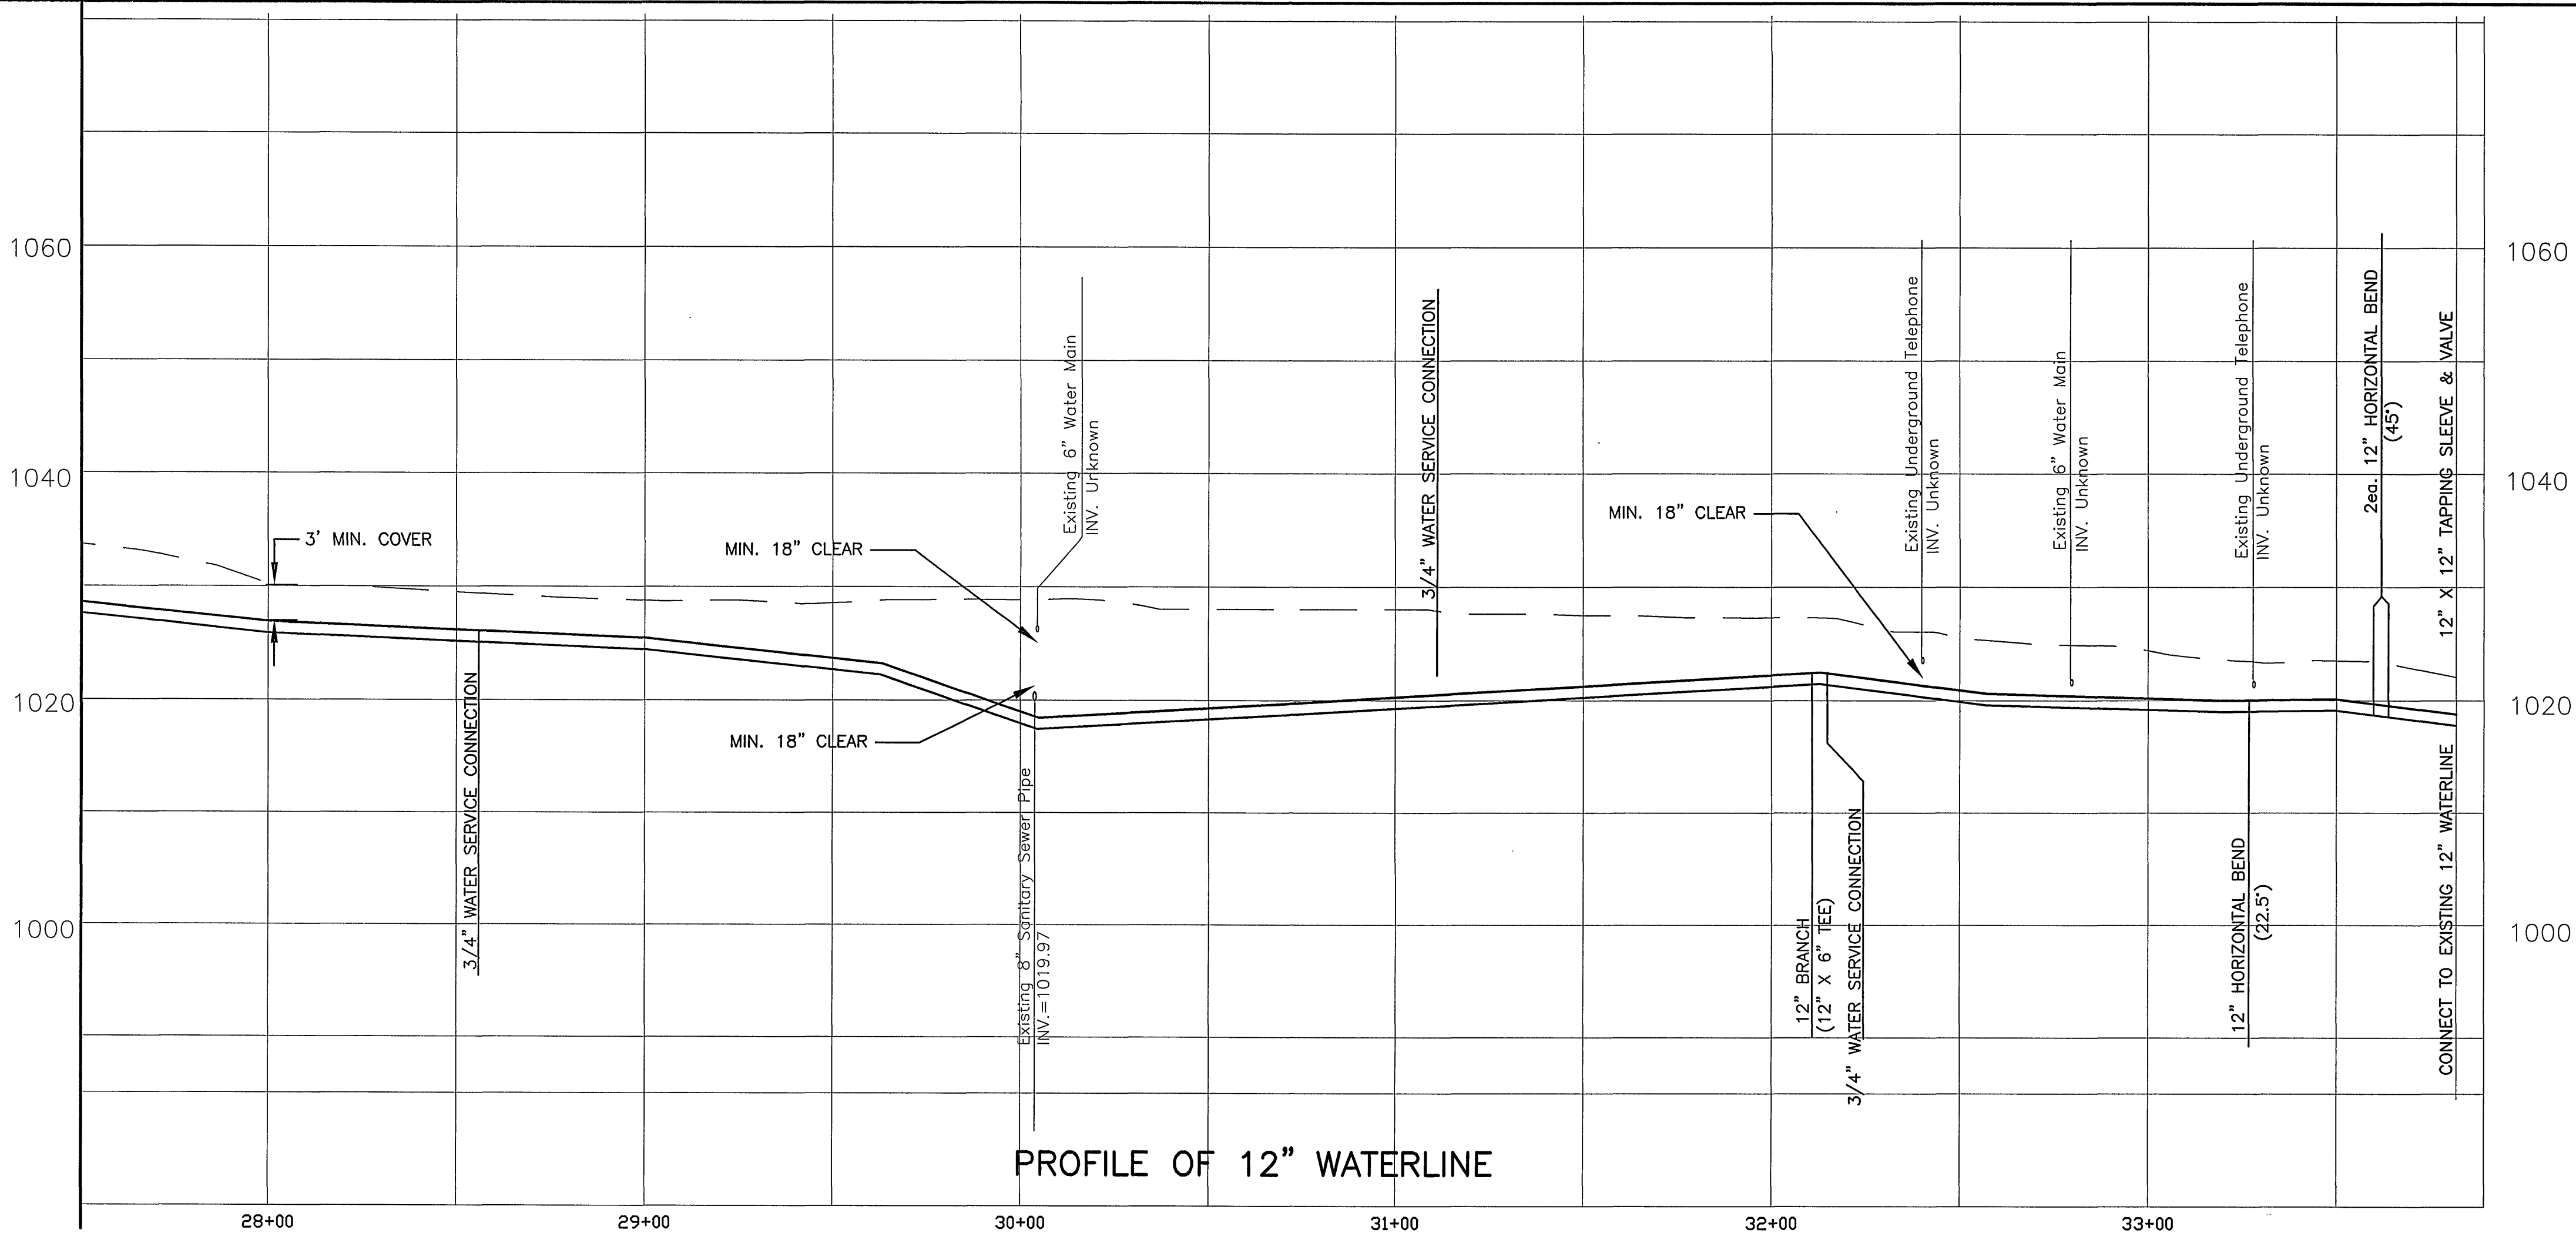

PROFILE OF 12" WATERLINE

RECORD DRAWINGS

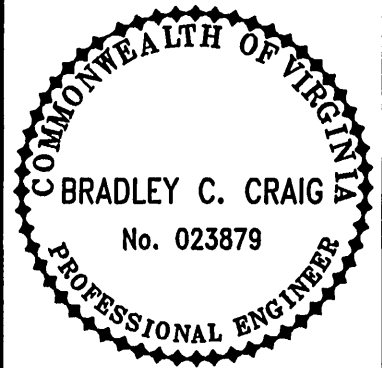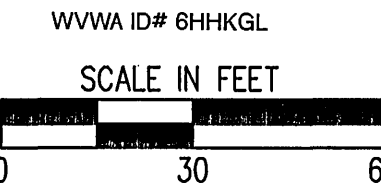

Revisions	Date

Issue Date:	6/11/04
Drawn By:	DBL
Designed By:	BCC
Checked By:	BCC
Date:	6/10/04

Mattem & Craig
CONSULTING ENGINEERS • SURVEYORS
701 FIRST STREET, S.W.
ROANOKE, VIRGINIA 24016
PHONE (540) 345-9342
FAX (540) 345-7891

BRAMBLETON AVE. WATER LINE PROJECT
PLAN AND PROFILE
12" WATERLINE
ROANOKE, VIRGINIA

Vertical Scale:
1"= 10'

Horizontal Scale:
1"= 30'

Commission Number:
2120B

Sheet No.:
8