
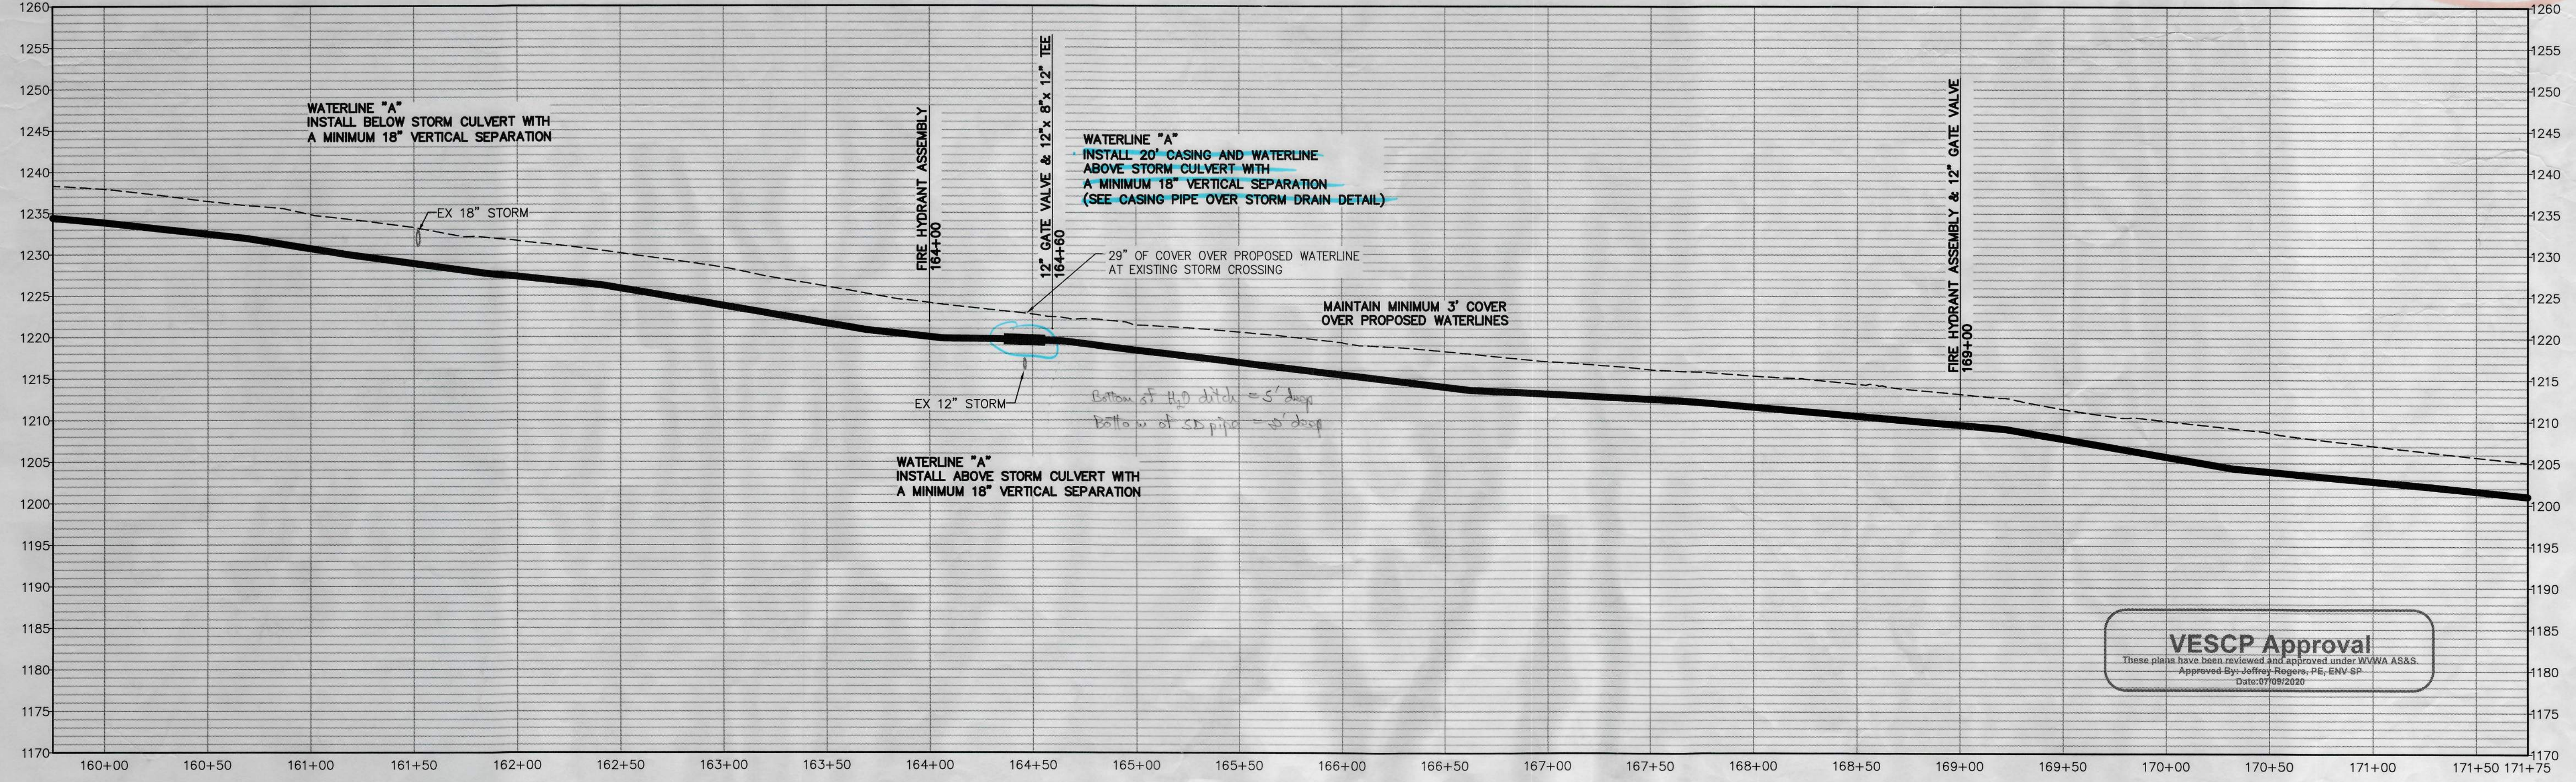


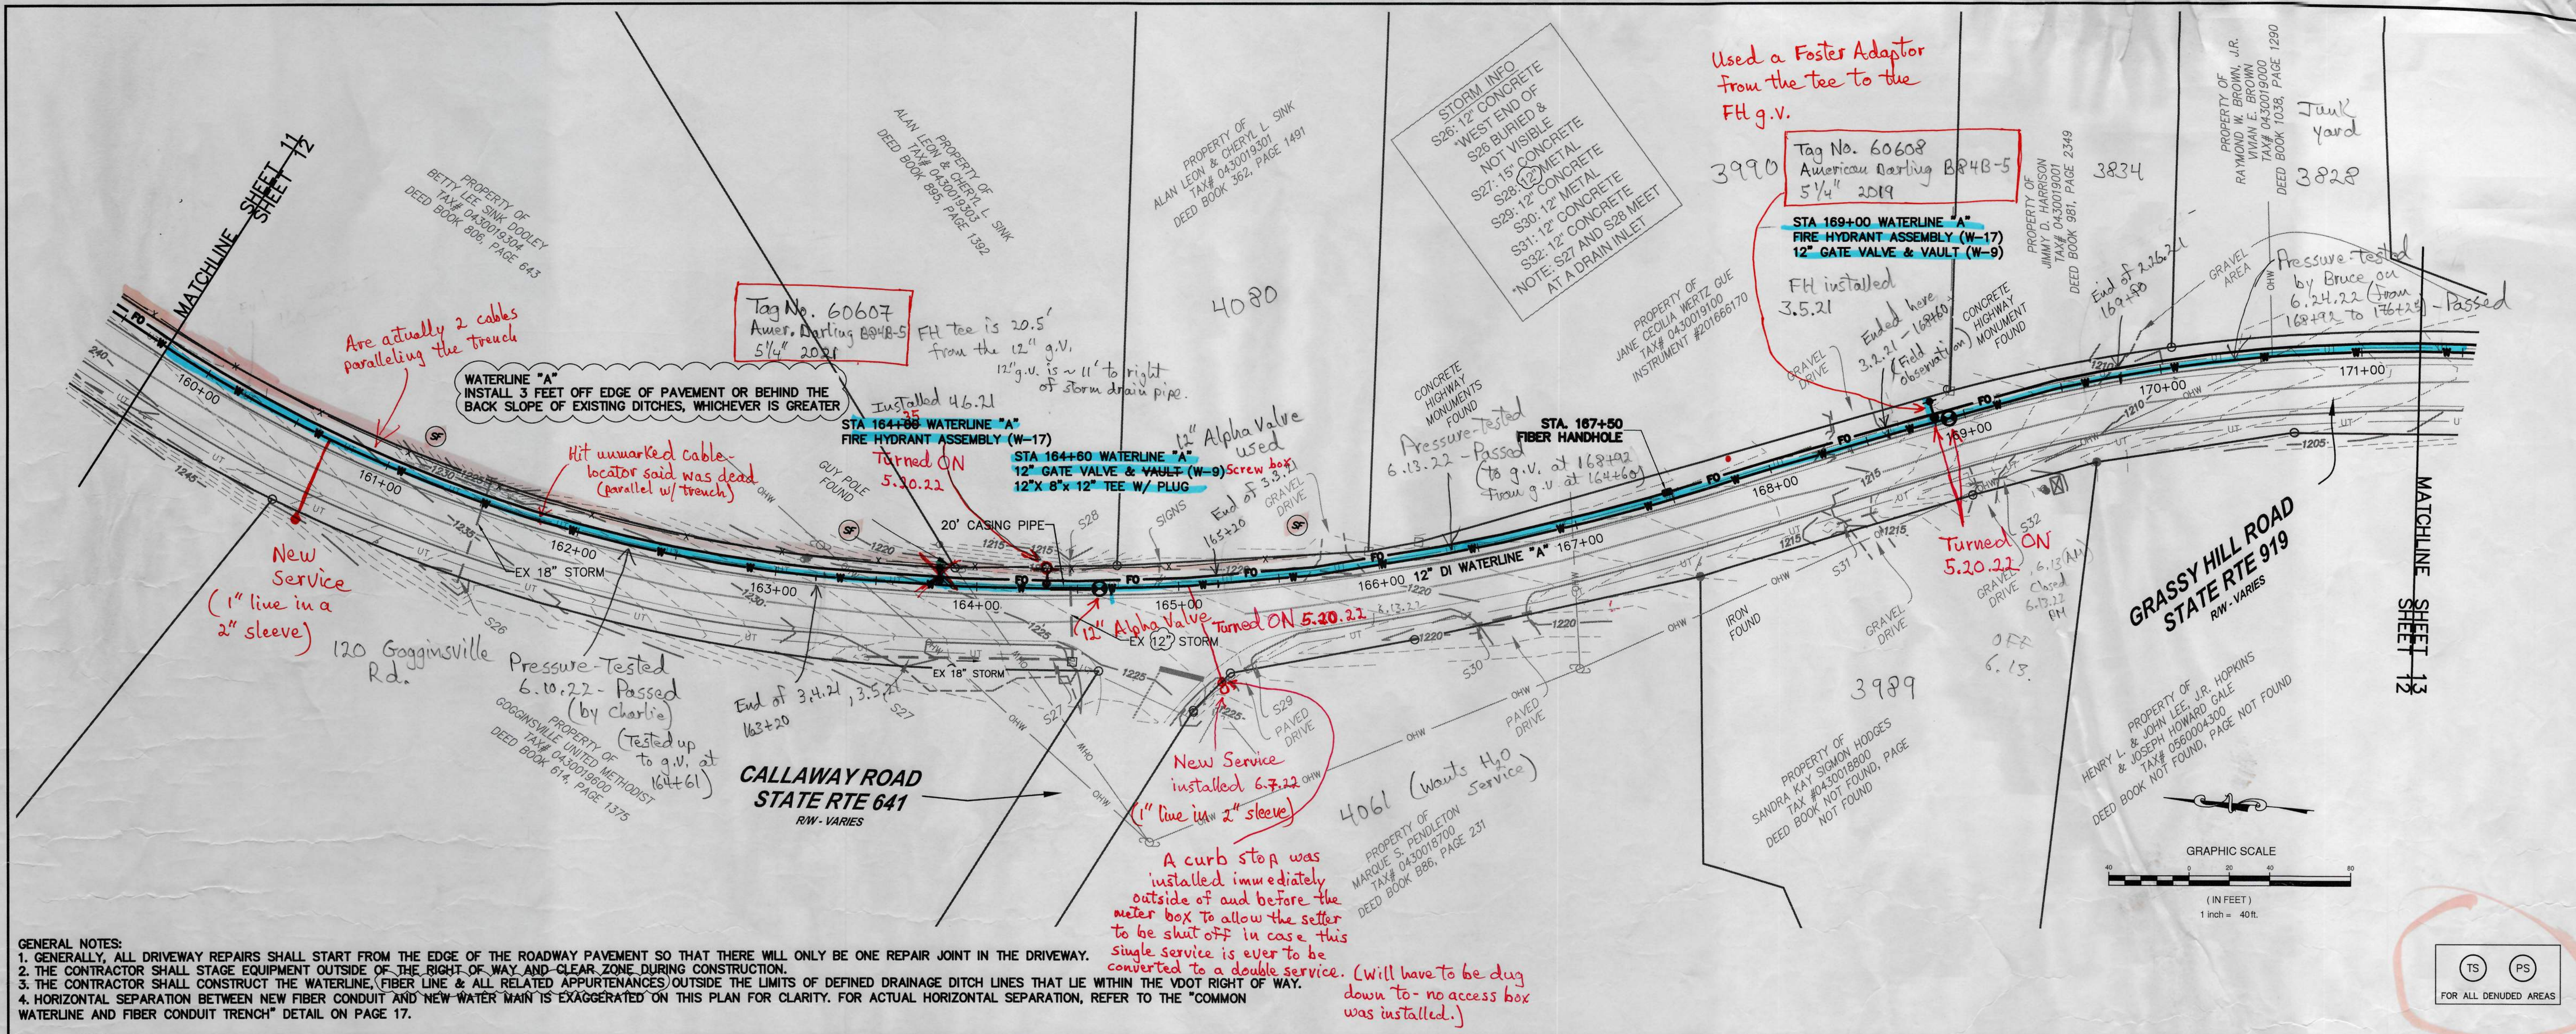

COMMONWEALTH OF VIRGINIA
IAN A. SMITH
Lic. No. 57410
06/12/2020
PROFESSIONAL ENGINEER

WESTERN VIRGINIA WATER AUTHORITY

GRASSY HILL ROAD WATERLINE EXTENSION
FRANKLIN COUNTY, VIRGINIA

REVISIONS

NO.	DATE	DESCRIPTION
1.	5/11/20	ADDRESS VDOT REVIEW COMMENTS - DRJ
2.	5/11/20	PLAN CHANGES PER WCB & IAS - DRJ
3.	6/08/20	DRJ

DESIGNED BY: IAS
DRAWN BY: PDG, DRJ
CHECKED BY: WCB
SCALE: 1" = 40'
DATE: FEB 6 2020
PROJECT NUMBER: WCIP
SHEET TITLE: PLAN AND PROFILE

12
12 OF 19