
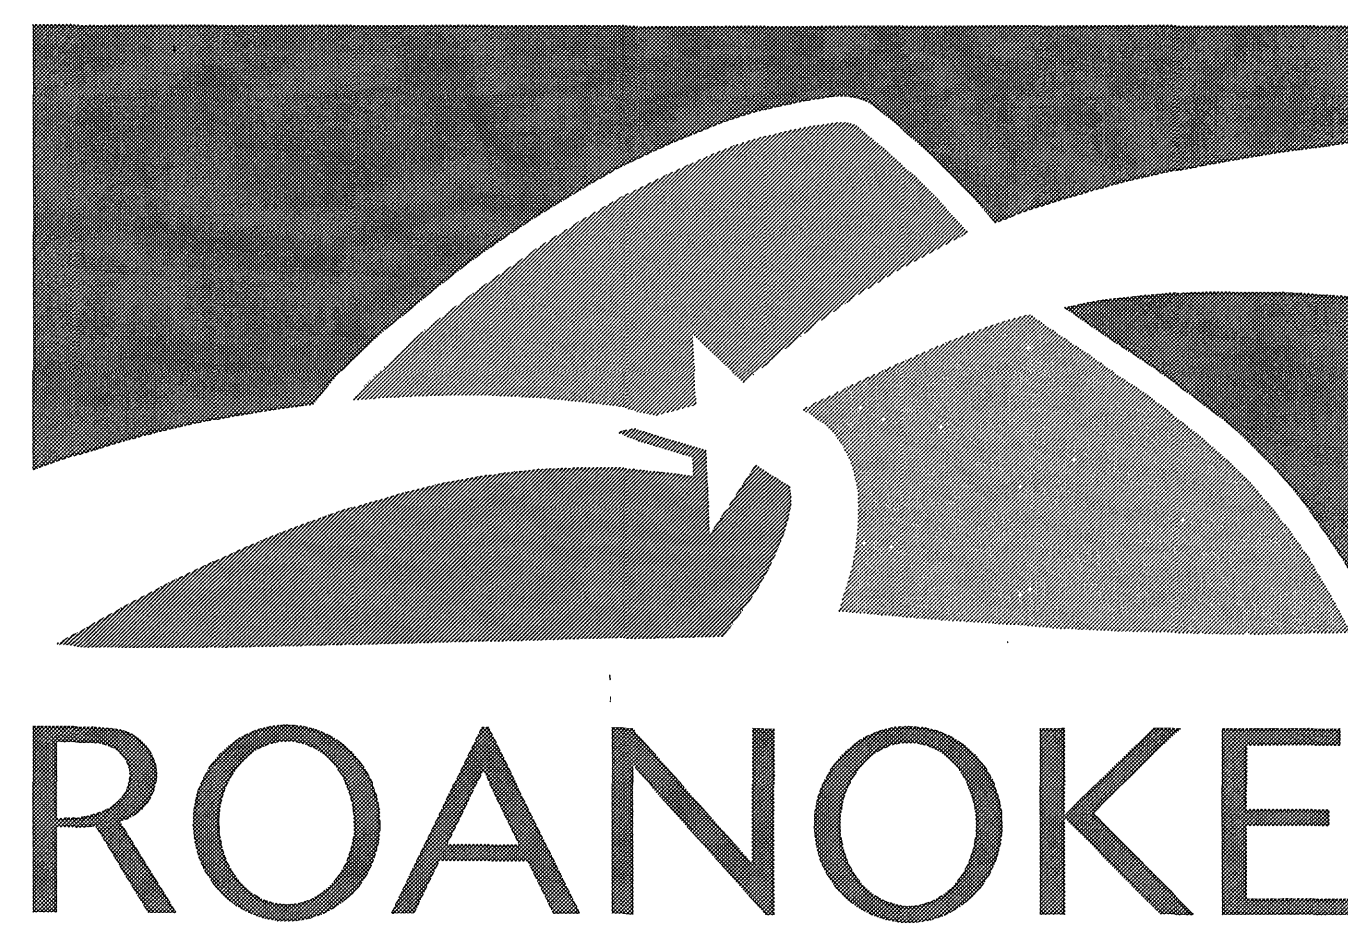


PROJECT LOCATION MAP

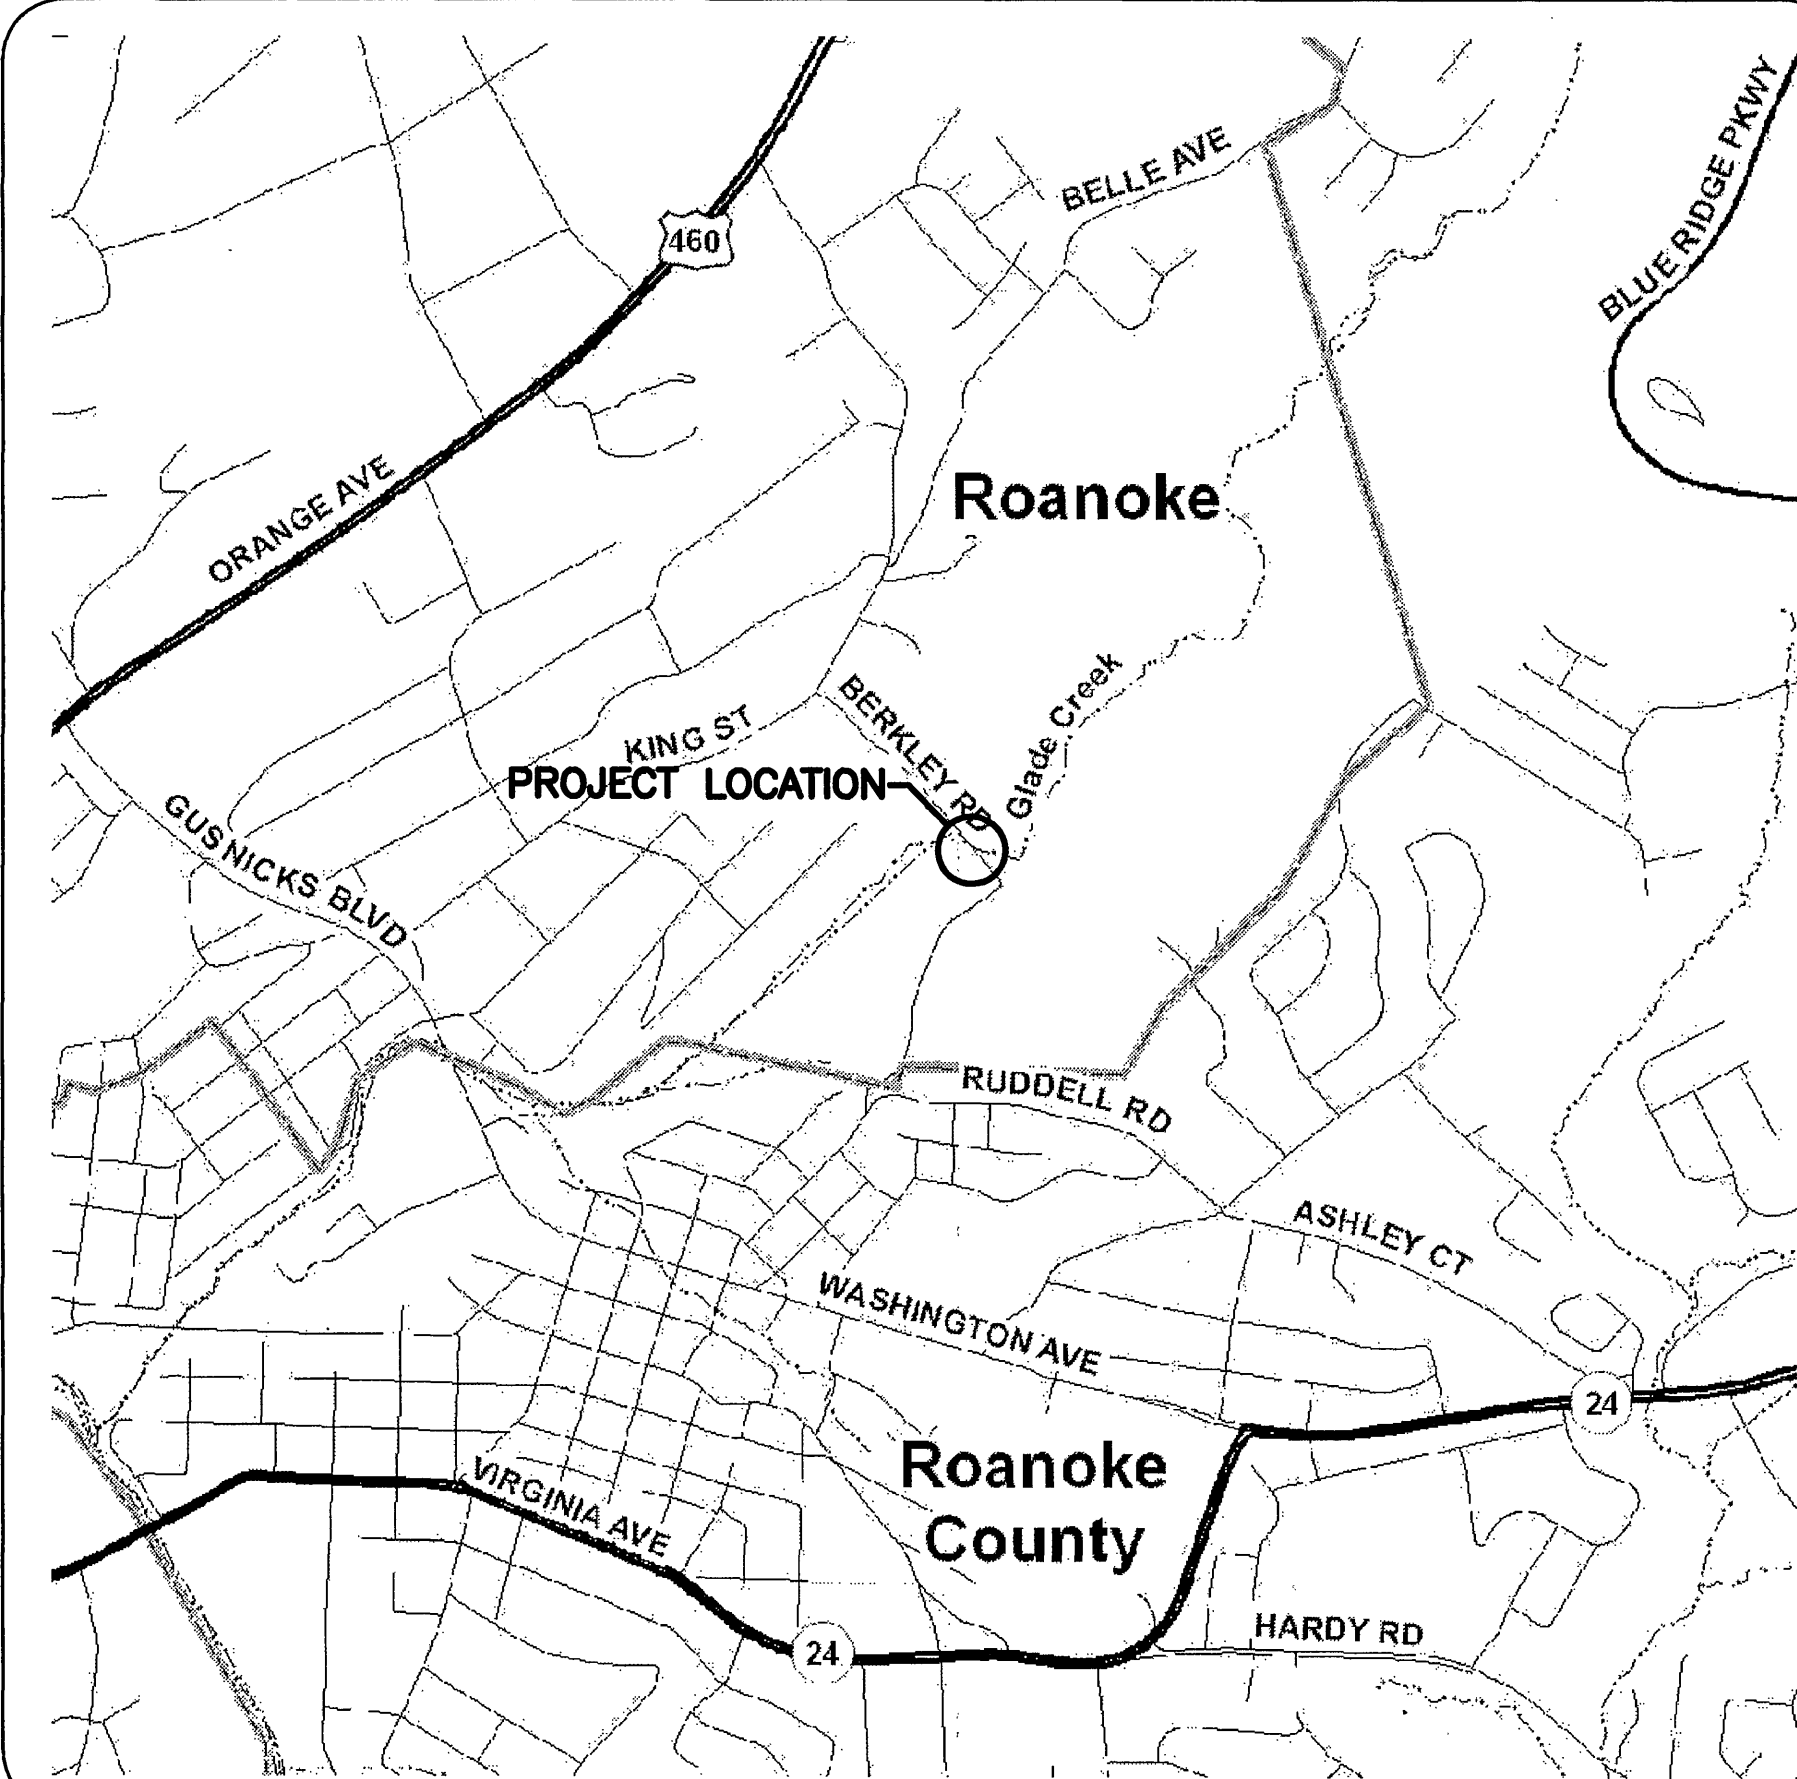

OFFICE OF THE CITY ENGINEER
215 CHURCH AVENUE, SW
ROOM 350
ROANOKE, VIRGINIA 24011-1587
PHONE: (540) 853-2731
FAX: (540) 853-1364
ENGINEER@ROANOKEVA.GOV

INDEX OF SHEETS

| SHEET NO. | SHEET TITLE |
|-----------|--|
| G1 | COVER SHEET |
| B1 | GENERAL PLAN AND ELEVATION |
| B2 | ABUTMENT A PLAN AND ELEVATION |
| B3 | ABUTMENT A DETAILS (1 OF 2) |
| B4 | ABUTMENT A DETAILS (2 OF 2) |
| B5 | ABUTMENT B PLAN AND ELEVATION |
| B6 | ABUTMENT B DETAILS |
| B7 | PIER DETAILS |
| B8 | TRANVERSE SECTION AND SLAB PLAN |
| B9 | BEARING DETAILS |
| B10 | FRAMING PLAN |
| B11 | BEAM DETAILS |
| B12 | SEMI-INTEGRAL BACKWALL DETAILS |
| B13 | RAILING DETAILS (1 OF 2) |
| B14 | RAILING DETAILS (2 OF 2) |
| B15 | ENGINEERING GEOLOGY |
| C1 | ROADWAY PLAN |
| C2 | ROADWAY PROFILE, E&SC AND SURVEY NOTES, ALIGNMENT AND CONTROL DATA |
| C3 | DETOUR PLAN |
| C4 | ROADWAY CROSS SECTIONS |

CONSULTING ENGINEERS



1315 FRANKLIN ROAD
ROANOKE, VIRGINIA 24016

AECOM PROJECT NO.: 60098105.3

Daniel R Dean
2011.04.13 15:01:53 -04'00'

Chad A Van Hyning
2011.04.13 15:24:32 -04'00'

PROJECT NAME

BERKLEY ROAD BRIDGE RECONSTRUCTION
STRUCTURE NUMBER 8015

CITY OF ROANOKE, VIRGINIA

CITY PROJECT NUMBER: 6659

VDOT PROJECT NUMBER: U000-128-311 (UPC 94730)

| | | |
|-------------|--------------|------|
| REVISION BY | DESCRIPTION: | DATE |
| REVISION BY | DESCRIPTION: | DATE |
| REVISION BY | DESCRIPTION: | DATE |
| REVISION BY | DESCRIPTION: | DATE |

APPROVED FOR CONSTRUCTION

| | |
|--------------------------|------|
| ROANOKE CITY ENGINEER | DATE |
| DIRECTOR OF PUBLIC WORKS | DATE |

ADVERTISED DATE:

SET NUMBER:

SHEET NUMBER: G1