

MATCHLINE SEE SHEET C1.3 - STA: 16+00.00

TAX MAP
NO. 15-56.3

TAX NO. 15-56.3


TAX NO. 15-56.1

TAX NO. 15-58

THE RECORD DRAWING INDICATED
HEREIN WAS CREATED FROM AN
ACTUAL FIELD SURVEY PERFORMED BY
ACS DESIGN IN SEPTEMBER AND
OCTOBER 2005.

THE RECORD DRAWING IS REFLECTIVE
OF THE FINAL DESIGN PERFORMED BY
ACS DESIGN AND APPROVED BY VDH
AND FRANKLIN COUNTY.

EXHIBIT "C"
RECORD
DRAWING
10/28/05

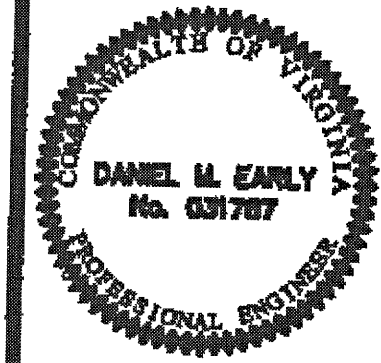

**ACS
DESIGN**
Engineering-Planning-Surveying
Construction Management
2203 Polare Creek Road, NW
Roanoke, Virginia 24017
Phone: 540 582 2345
Fax: 540 582 2344
Email: info@acsdesignllc.com
www.acsdesignllc.com

BRIDGEWATER PLAZA
CENTRAL SEWER SYSTEM
FRANKLIN COUNTY, VIRGINIA

DRAWN BY: C.E.K.
DESIGNED BY: C.E.K.
CHECKED BY:
DATE: OCT. 28, 2005
SCALE: HORIZ. 1"=30'

REVISIONS	
NO.	DESCRIPTION

SHEET No.
C1.4
FORCEMAIN
PLAN AND PROFILE
JOB No. 04007

6" FORCE MAIN


6" FORCE MAIN

6" FORCE MAIN

ROW LINE

ROW LINE

STATE ROUTE 122

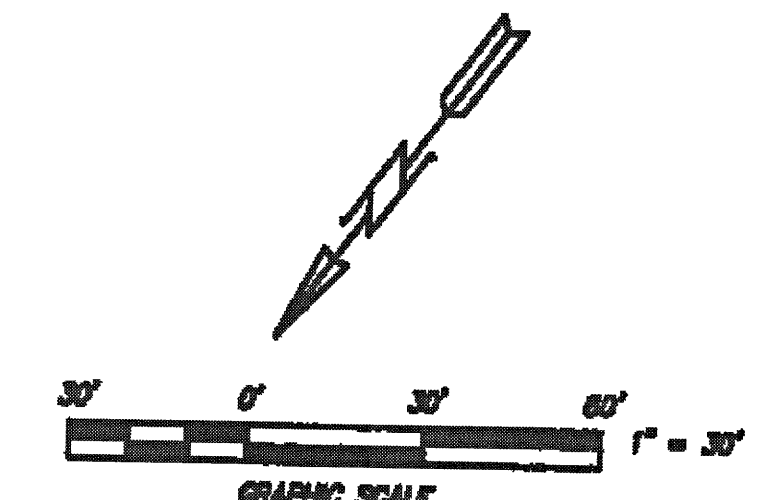

SCALE HORIZ. 1"=30'
VERT. 1"=10'

6" SEWER FORCEMAIN

EXISTING GROUND

MATCHLINE SEE SHEET C1.3 - STA: 16+00.00

MATCHLINE SEE SHEET C1.5 - STA: 26+00.00

828.1 842.4 846.2 848.8 852.0 854.1 853.9 853.0 854.5 854.1 853.0 853.2 853.9 873.0 873.9 881.2

17+00 18+00 19+00 20+00 21+00 22+00 23+00 24+00