


ACS DESIGN

Engineering Planning - Surveying
Construction Management

2203 Peters Creek Road, NW
Roanoke, Virginia 24017
Phone: 540 562 2345
Fax: 540 562 2344
Email: info@acsdesignllc.com
www.acsdesignllc.com

BRIDGEWATER PLAZA
CENTRAL SEWER SYSTEM
FRANKLIN COUNTY, VIRGINIA

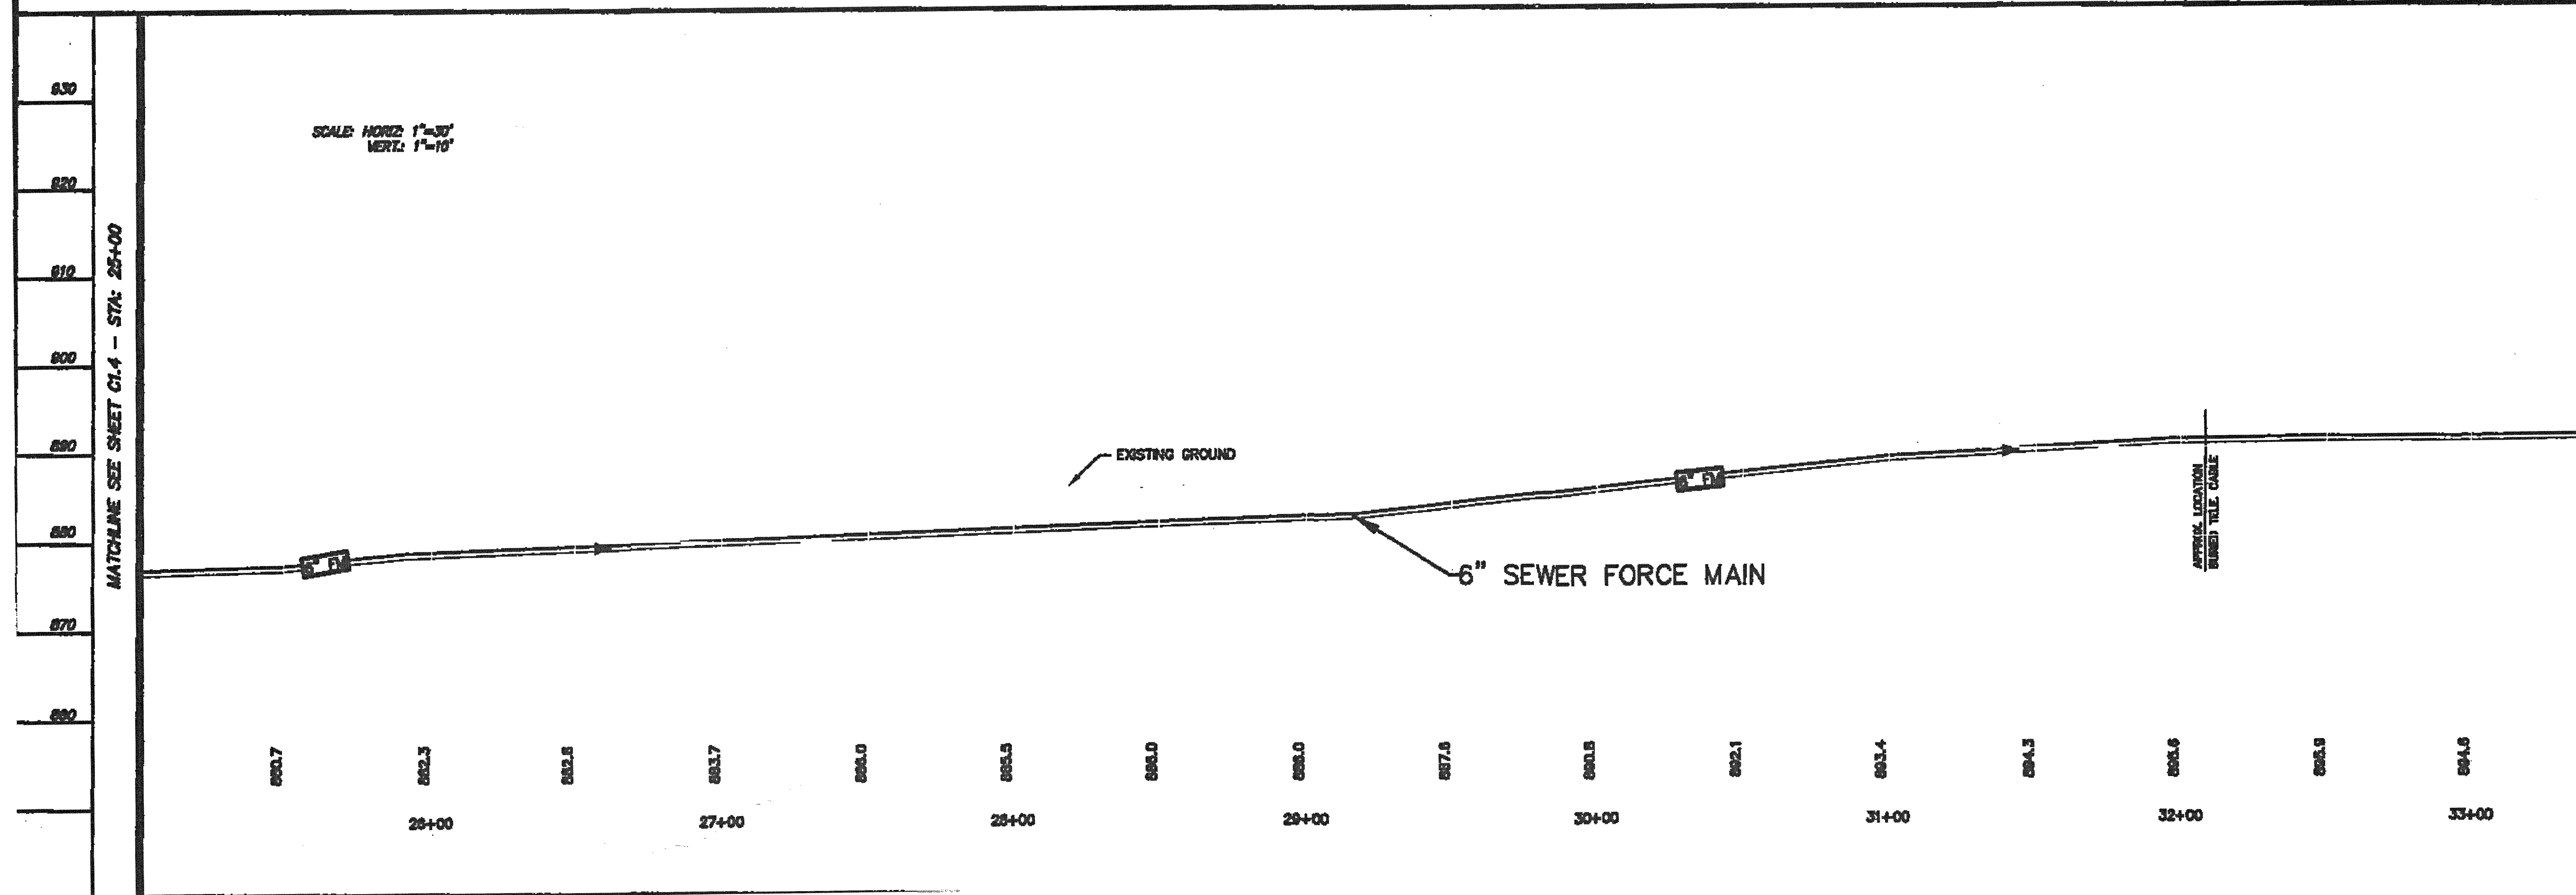

DRAWN BY: C.E.K.
DESIGNED BY: C.E.K.
CHECKED BY:
DATE: OCT. 25, 2005
SCALE: HORIZ. 1"=30'

REVISIONS	
NO.	DESCRIPTION

SHEET No.
C1.5
FORCE MAIN
PLAN AND PROFILE
JOB No. 04007