



SS MANHOLE # 5
 TOP 72.0
 INV IN 66.0
 NEW PIPE SHALL ENTER AT THE TOP
 OF THE BENCH (FIELD VERIFY)

PROPOSED VARIABLE WIDTH WATER,
 SEWER AND STORM WATER
 MANAGEMENT AREA ACCESS
 EASEMENT

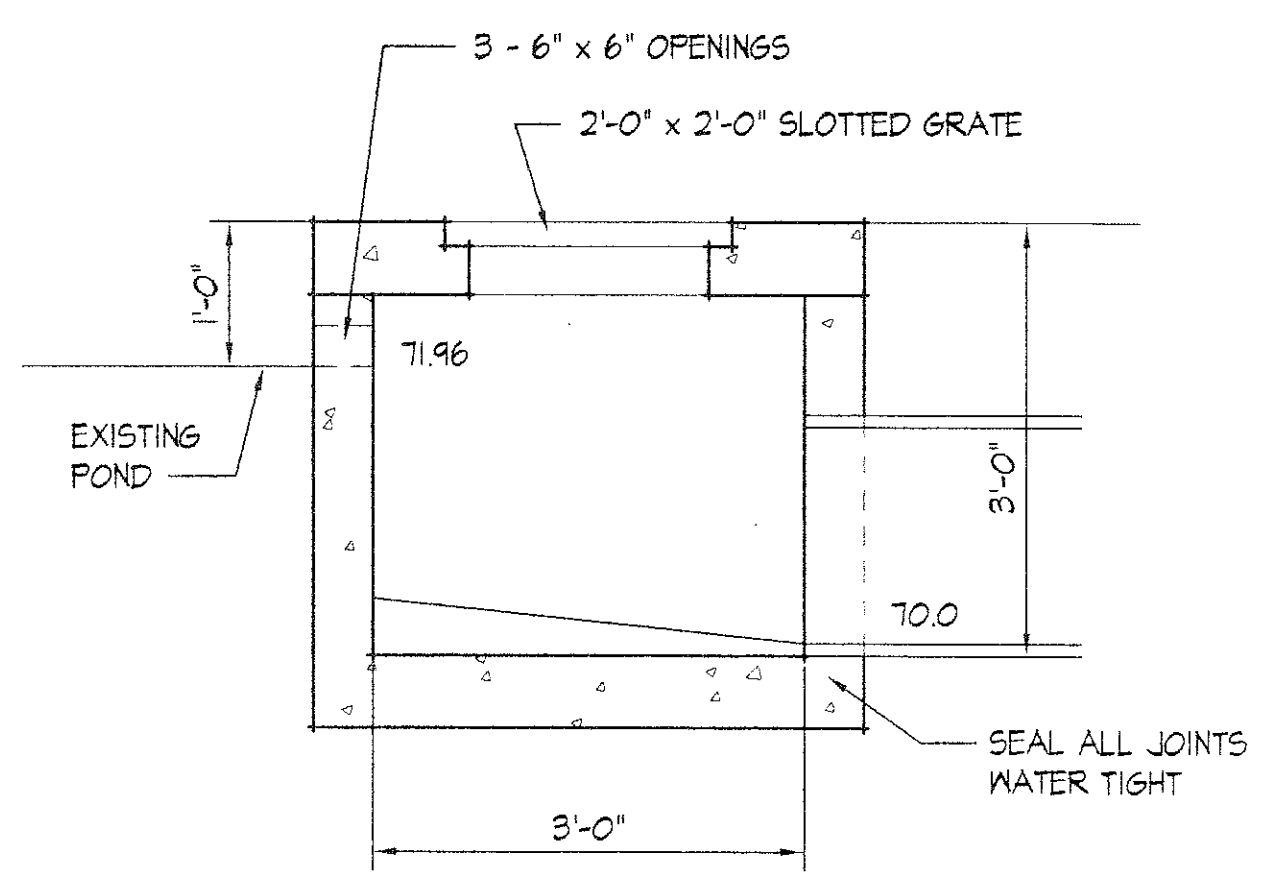

SECTION
 SCALE 3/4" = 1'-0"
 C4.1
 C4

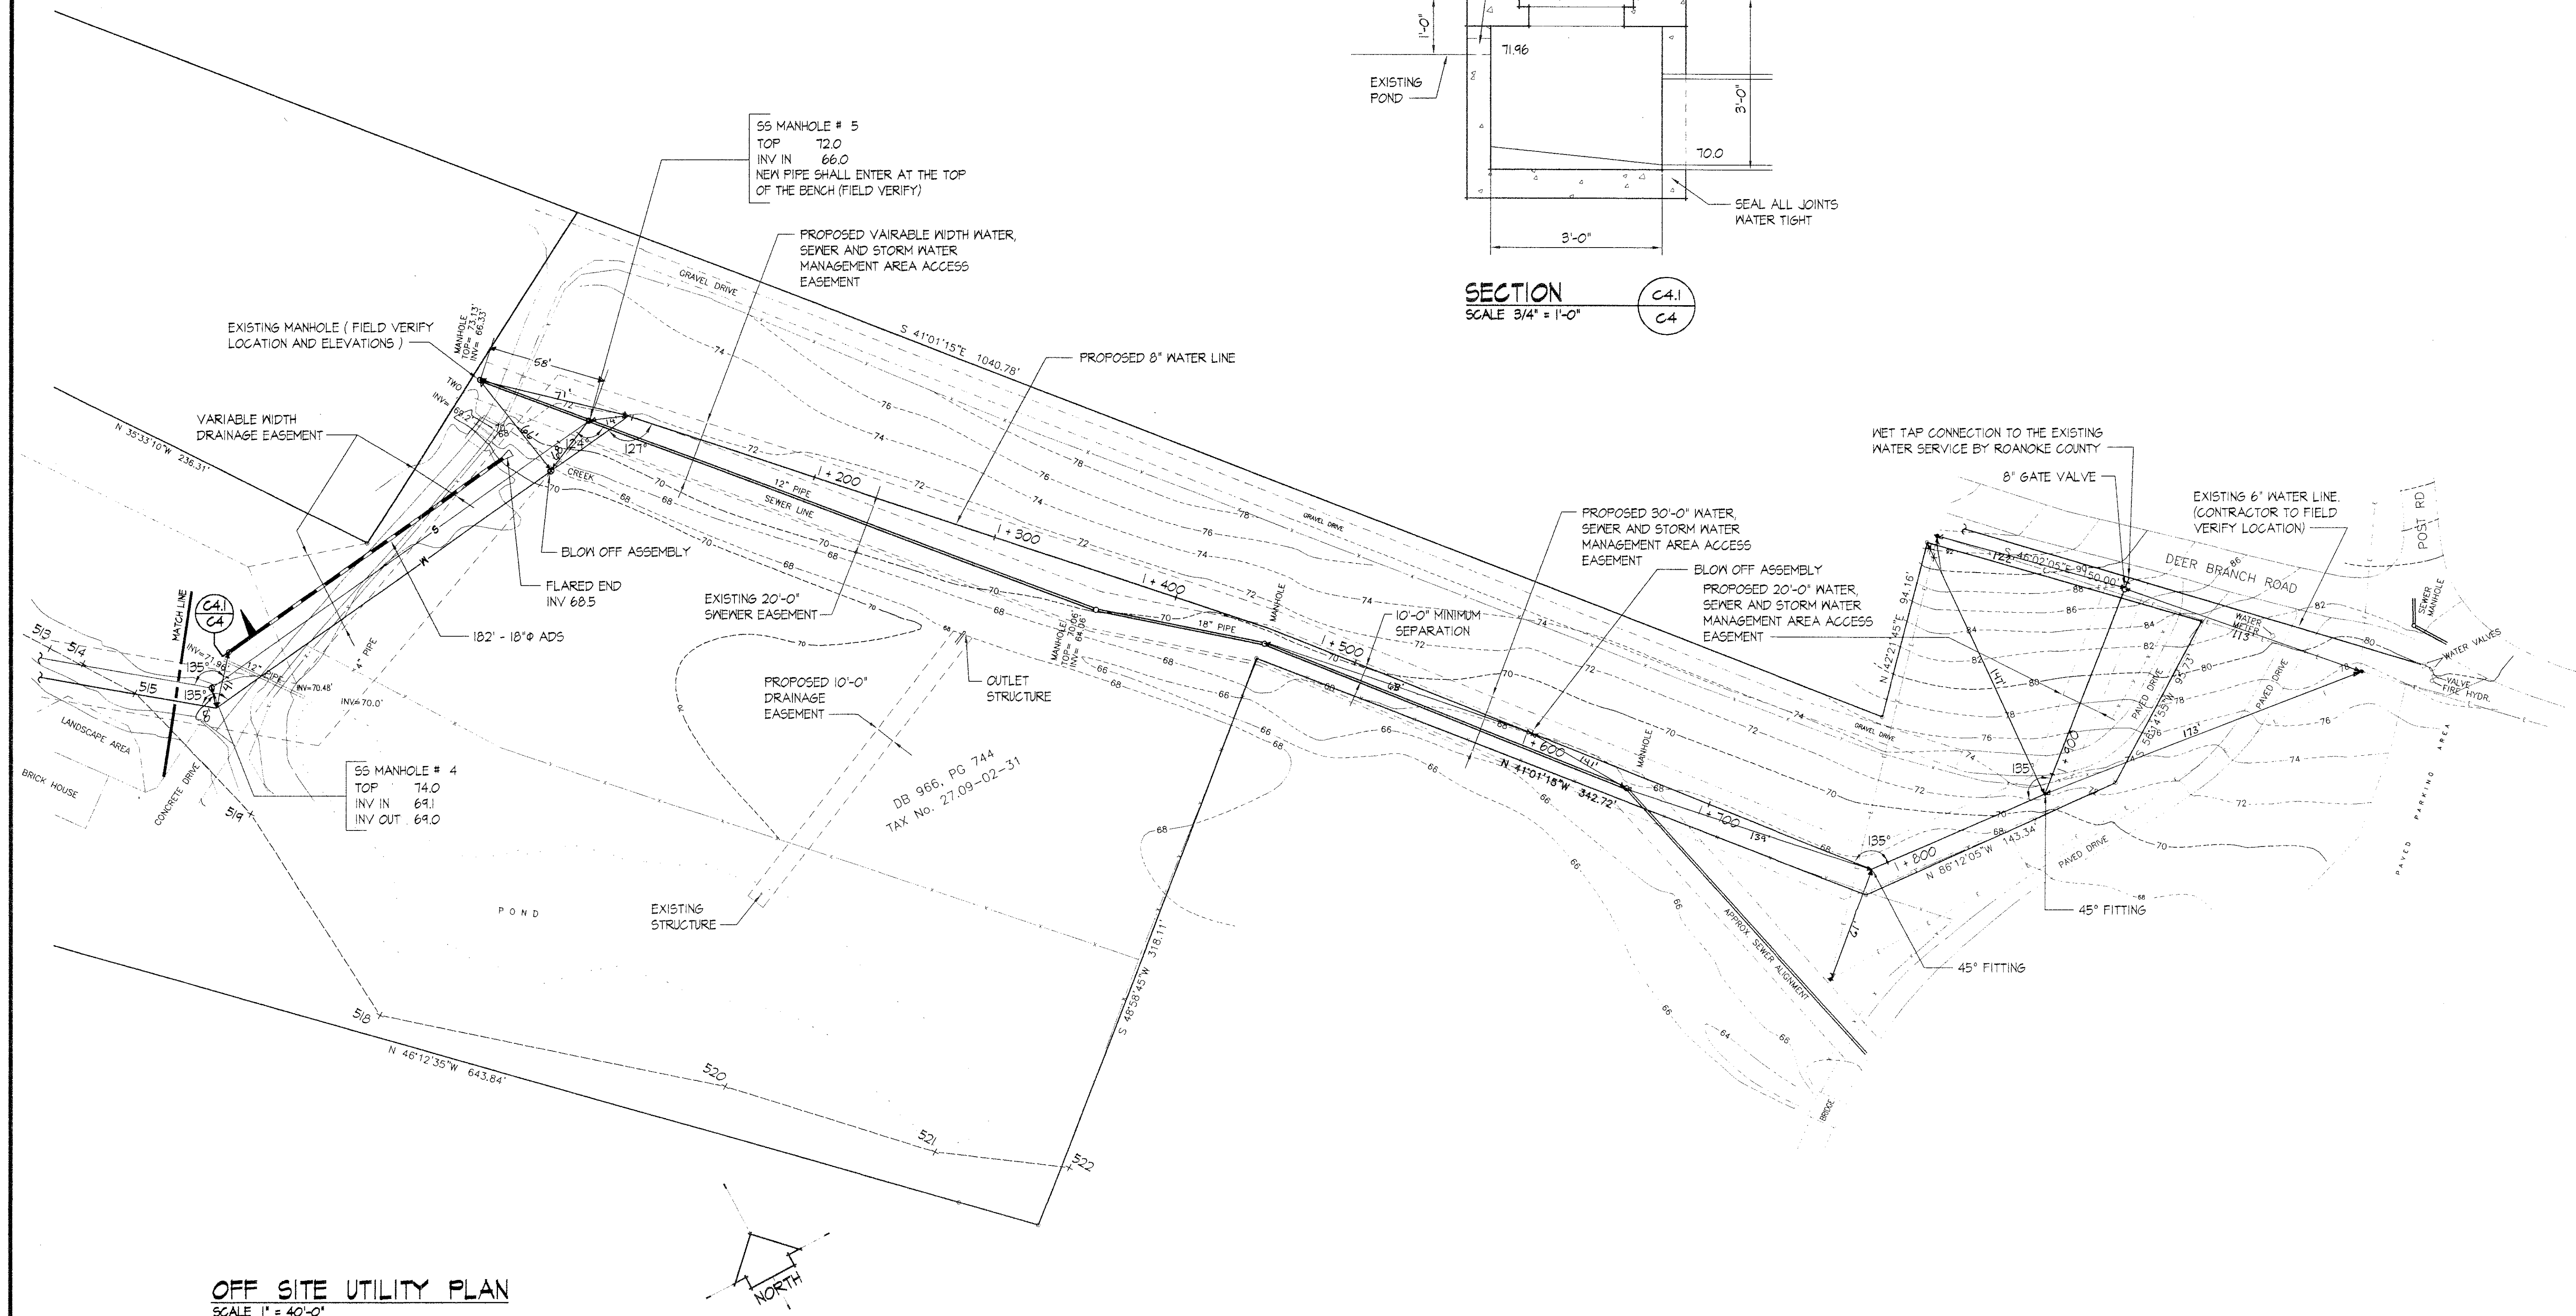

OFF SITE UTILITY PLAN
 SCALE 1" = 40'-0"

REVISION DATE
 4 DEC 2002

BROOKFIELD COURT
 RESIDENTIAL COMMUNITY
 ROANOKE COUNTY, VIRGINIA

PROJECT ARCHITECT
 RLJ JR

COMMISSION NUMBER
 2095

TECHNICIANS
 RWT

DATE
 17 APR 2002

C4