


Spell checked by JAW on 04/26/2007 11:05am

H:\P\2426\CAD\Sheets\C\CG101.dwg Fri, 15 Jun 2007 - 11:54am jaw

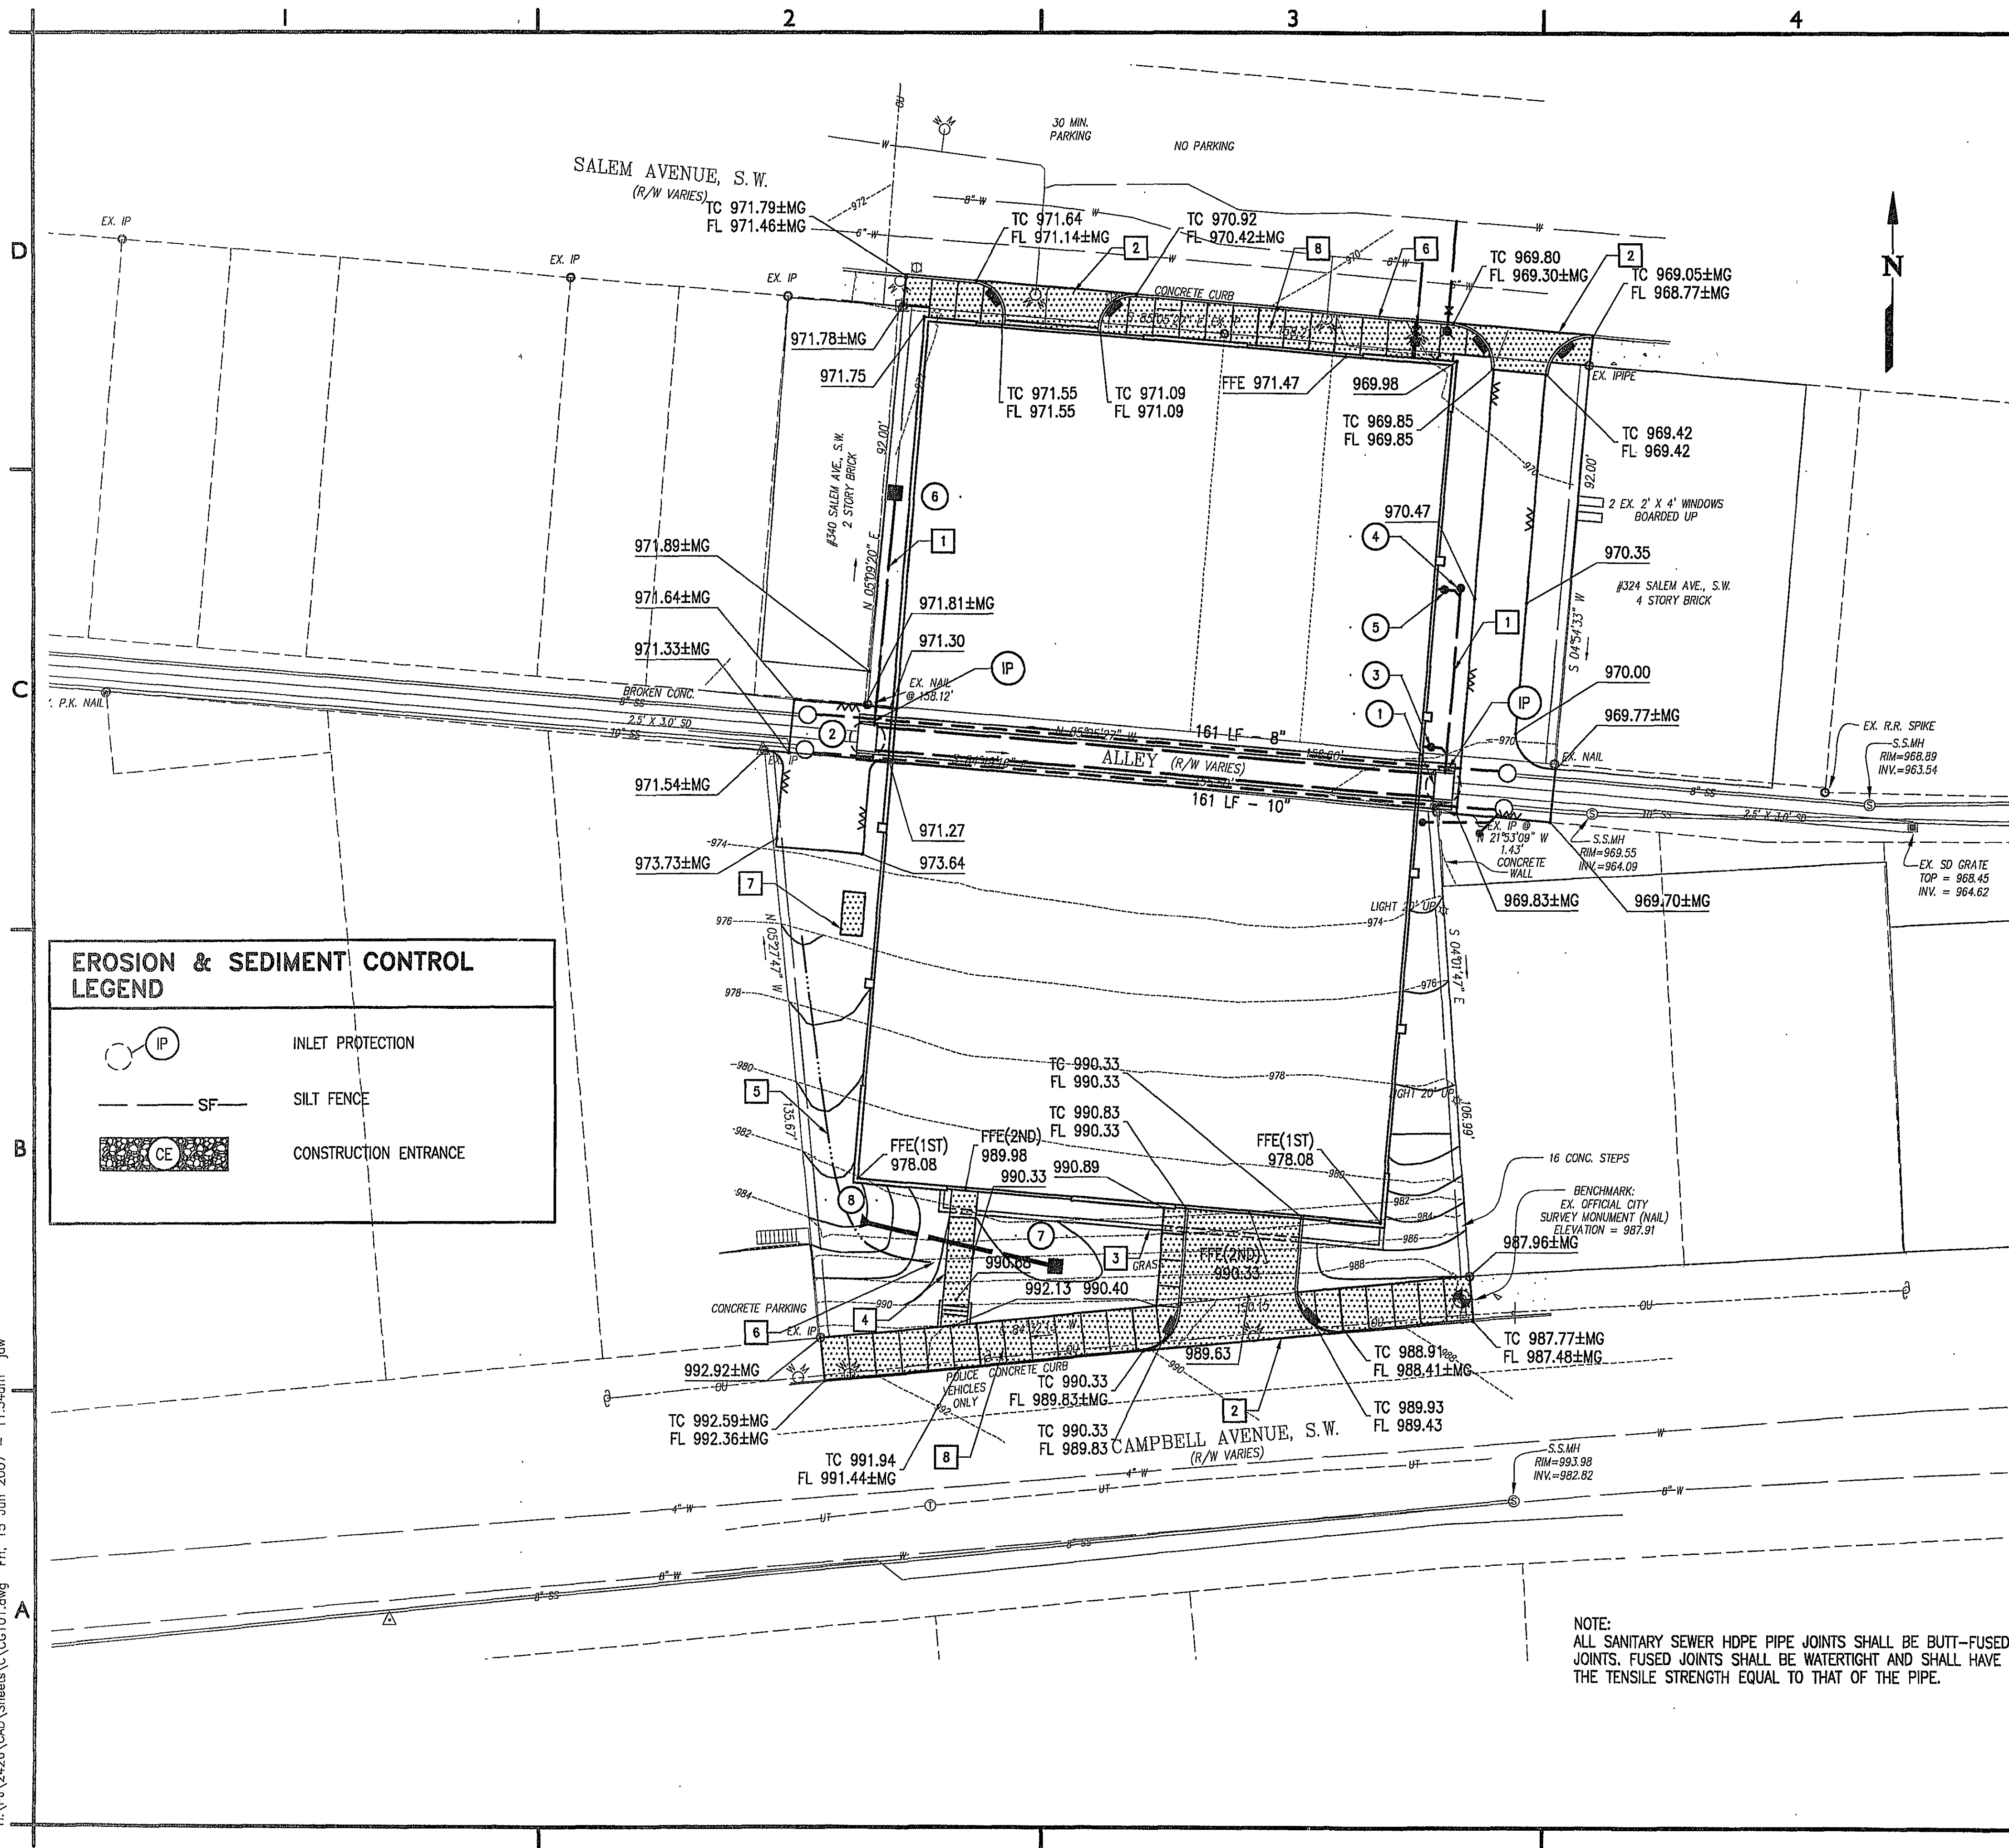

CONSTRUCTION NOTES

- 1 8" PVC DRAIN LINE @ 1.04% SLOPE
- 2 VDOT STD. CG-13
- 3 RETAINING WALL
- 4 PEDESTRIAN WALKWAY, SEE STRUCTURAL PLANS FOR DETAILS.
- 5 GRASS SWALE
- 6 VDOT STD. CG-2
- 7 GENERATOR PAD
- 8 CONCRETE SIDEWALK

STORM STRUCTURE DATA

- 1 VDOT STD. JB-1 WITH VDOT T-DI-7 TYPE A III GRATE
RIM=970.10
INV(W)=964.43
INV(E)=965.76
INV(N)=967.40
- 1 TO 2 133' - 4' X 4' VDOT STD. BOX CULVERT
- 2 VDOT STD. JB-1 WITH VDOT T-DI-7 TYPE A III GRATE
RIM=971.15
INV(E)=965.48
INV(W)=967.12
INV(N)=968.75
- 3 SCO
RIM=970.00
INV=968.00
- 4 SCO
RIM=970.50
INV=967.90
- 5 SCO
RIM=970.65
INV=968.40
- 6 NDS 12" X 12" CATCH BASIN WITH A LIGHT DUTY GRATE
RIM=971.30
INV=969.30
- 7 NDS 24" X 24" CATCH BASIN WITH A LIGHT DUTY GRATE
RIM=989.50
INV=986.50
- 7 TO 8 46' - 12" HDPE @ 5.43%
- 8 HDPE END SECTION
INV=984.00


GRAPHIC SCALE(S)



NOTE:
ALL SANITARY SEWER HDPE PIPE JOINTS SHALL BE BUTT-FUSED JOINTS. FUSED JOINTS SHALL BE WATERTIGHT AND SHALL HAVE THE TENSILE STRENGTH EQUAL TO THAT OF THE PIPE.

CLARK NEXSEN
Architecture & Engineering

6160 KEMPSVILLE CIRCLE
NORFOLK, VIRGINIA 23502
757-455-5800 FAX 757-455-5638
WWW.CLARKNEXSEN.COM

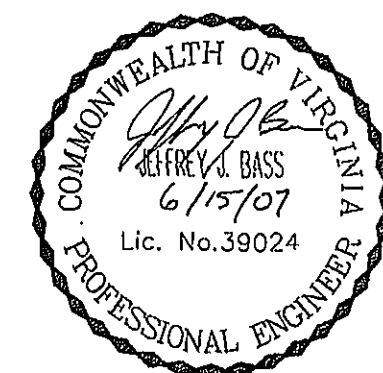

DESMAN
ASSOCIATES
A DIVISION OF DESMAN, INC.
NEW YORK CHICAGO WASHINGTON, D.C. HARTFORD BOSTON CLEVELAND LAS VEGAS

Donley's
Design/Build + General Contracting
Construction Management

CAMPBELL AVENUE
PARKING DECK
ROANOKE, VIRGINIA

CN NO: 2426.2
DATE: 6/15/07
DESIGN: JJB
DRAWN: JAW
REVIEW: TAR
REVISIONS

No.	Date	Description	By
-----	------	-------------	----

GRADING AND
DRAINAGE PLAN

CG101
SHEET 6 OF 11